



NOTE:
NO SERVICE ON LINES DEEPER THAN 10'

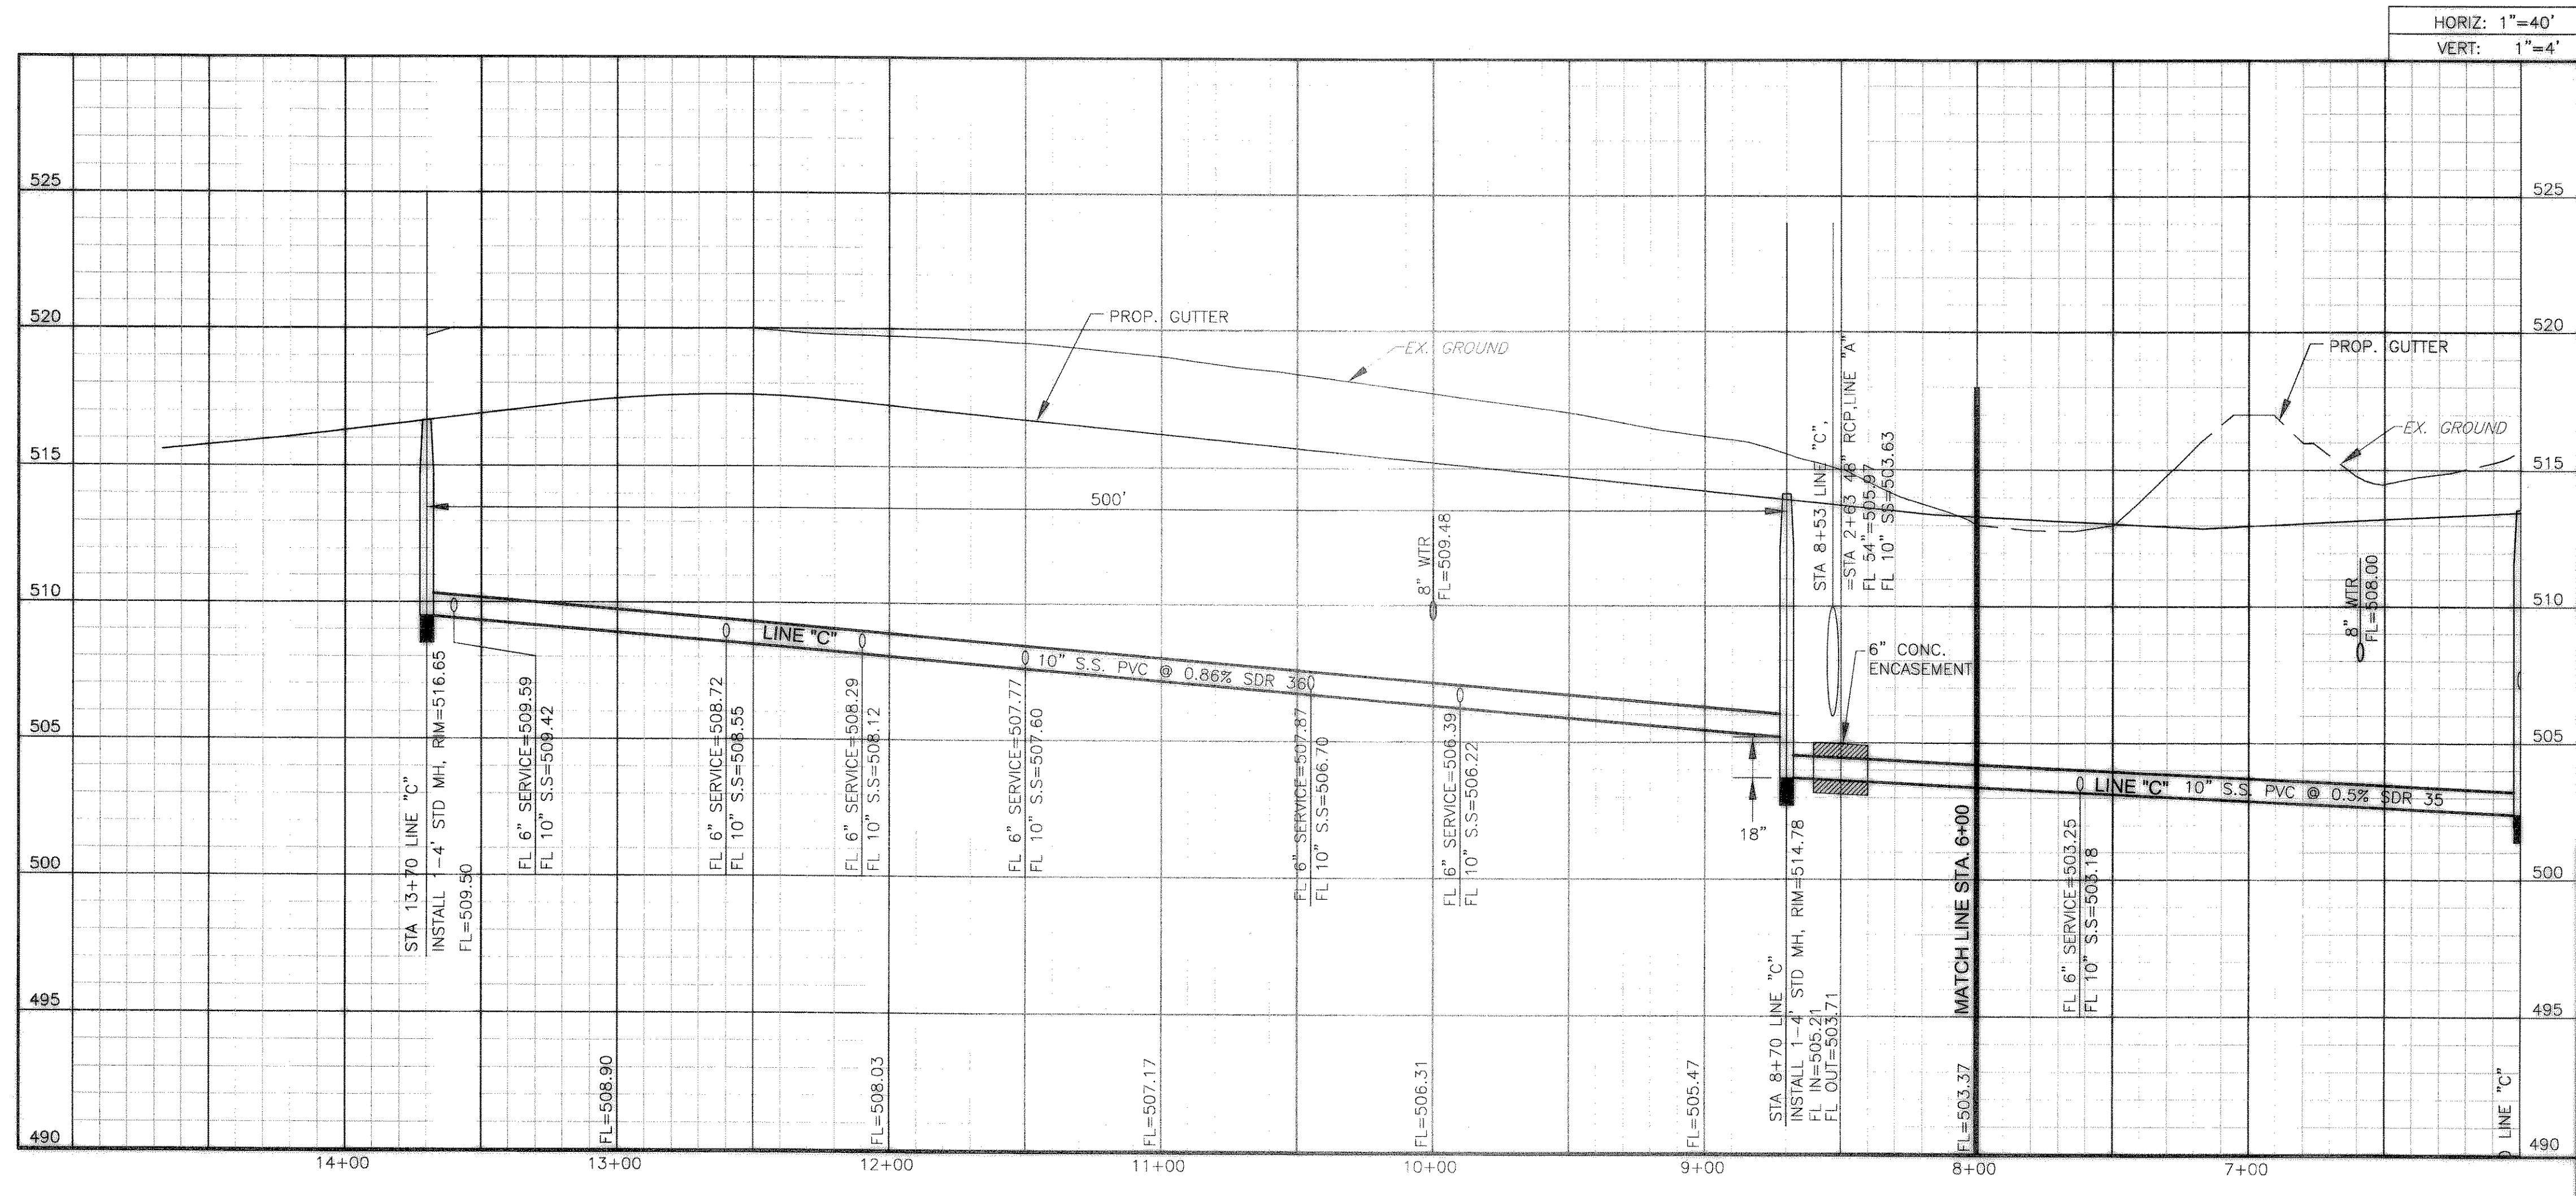

HORIZ: 1"=40'
VERT: 1"=4'

AS BUILT
THIS IS TO CERTIFY THAT CHANGES AND CORRECTIONS HAVE BEEN MADE TO CONFORM TO THE CONTRACTOR'S RECORD OF THIS PROJECT.

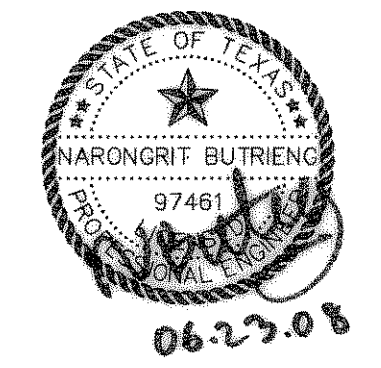

PLAN AND PROFILE SANITARY SEWER LINE "C" STA. 8+00 TO 13+70						
HORIZON RIDGE MEDICAL PARK						
CITY OF ROCKWALL, TEXAS						
PSA ENGINEERING						
17819 DAVENPORT ROAD, SUITE 215 DALLAS, TX 75262 (972) 246-9651						
DESIGN	DRAWN	DATE	SCALE	CHECK	FILE	NO.
PSA	PSA	06/23/08	AS SHOWN	PSS	2616.HRM	C-15

Y:\2008\2616.HRM\AS-BUILT\SET 1\C-15.dwg

AS BUILT