




3 90° HANDICAP PARKING
SCALE: 1/4" = 1'-0"

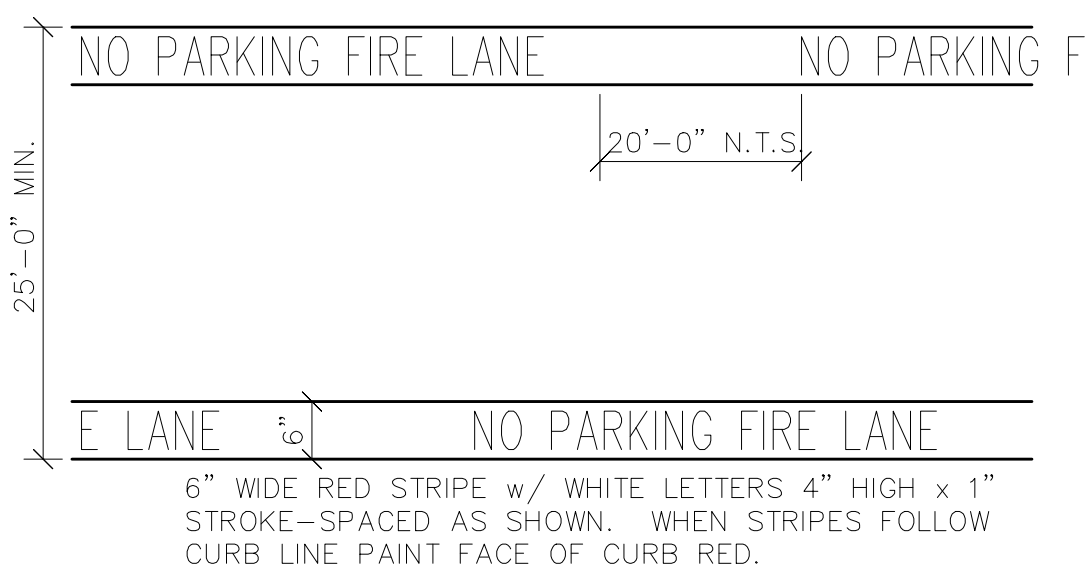


4 FIRE LANE STRIPES
SCALE: 3/4" = 1'-0"

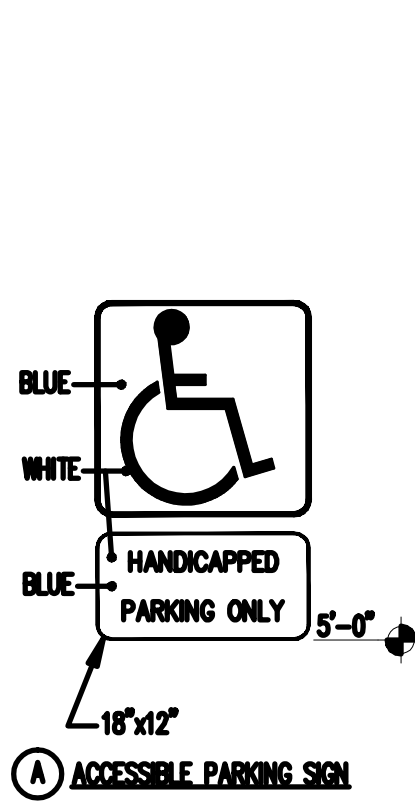

8 SIGNS
SCALE: N.T.S.

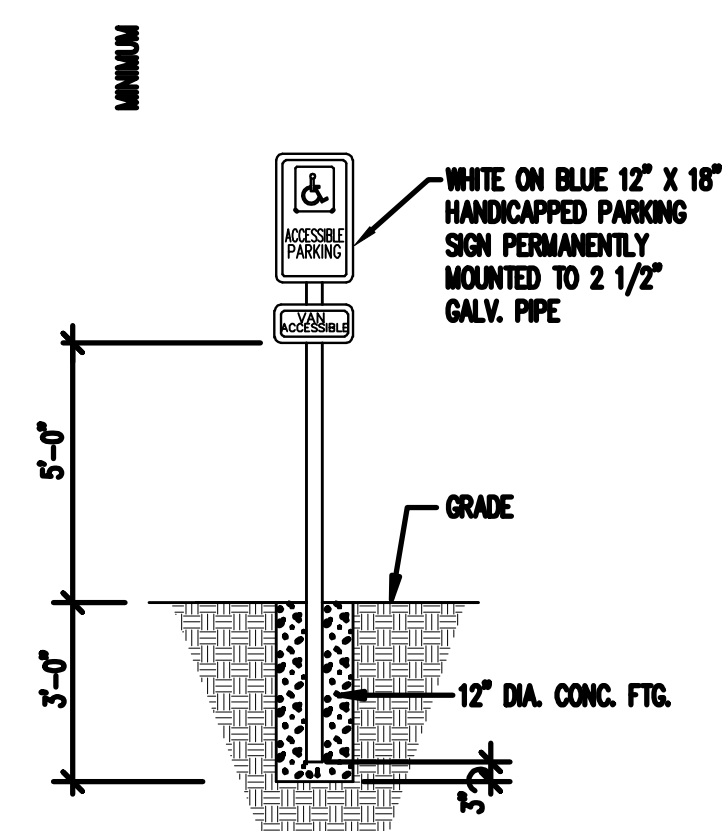


9 ACCESSIBLE PARKING SYMBOL
SCALE: N.T.S.

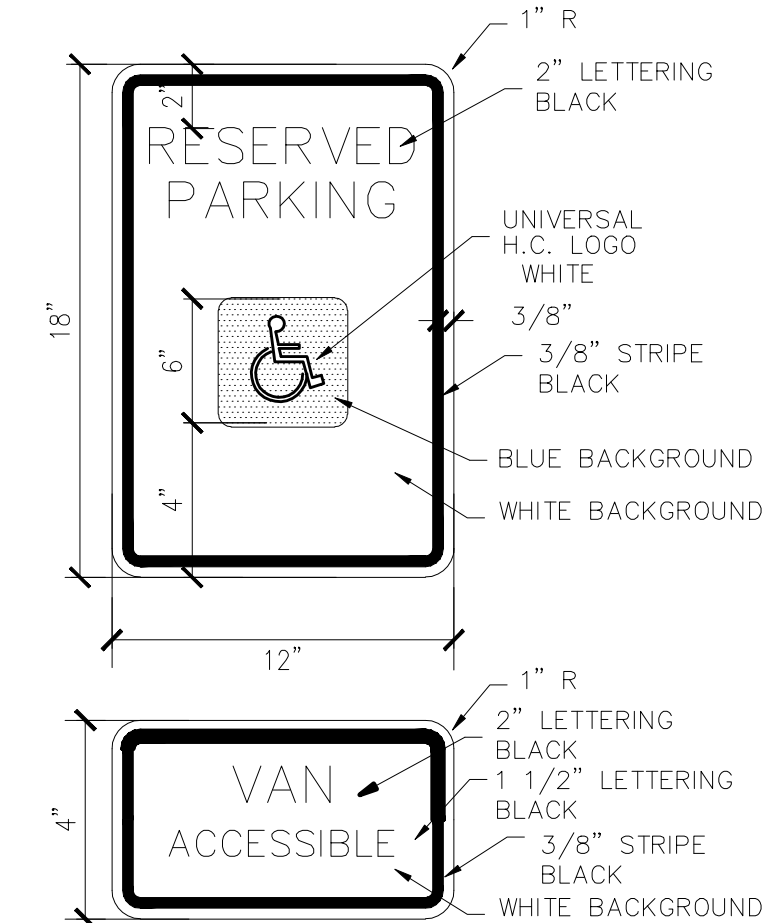

RESERVED PARKING SIGN

PRIOR TO ANY WORK LOCATE EX. SEWER STUB OUT AND DETERMINE EX. FLOW LINE. IF FLOW LINE AS SHOWN ON THE UTILITY PLAN (ELEV. 563.00) OR LOWER PROCEED WITH CONSTRUCTION, IF HIGHER NOTIFY THE ENGINEER. CONFIRM EXACT LOCATION OF EX. LIGHT POLE ON NORTH SIDE OF PROJECT.

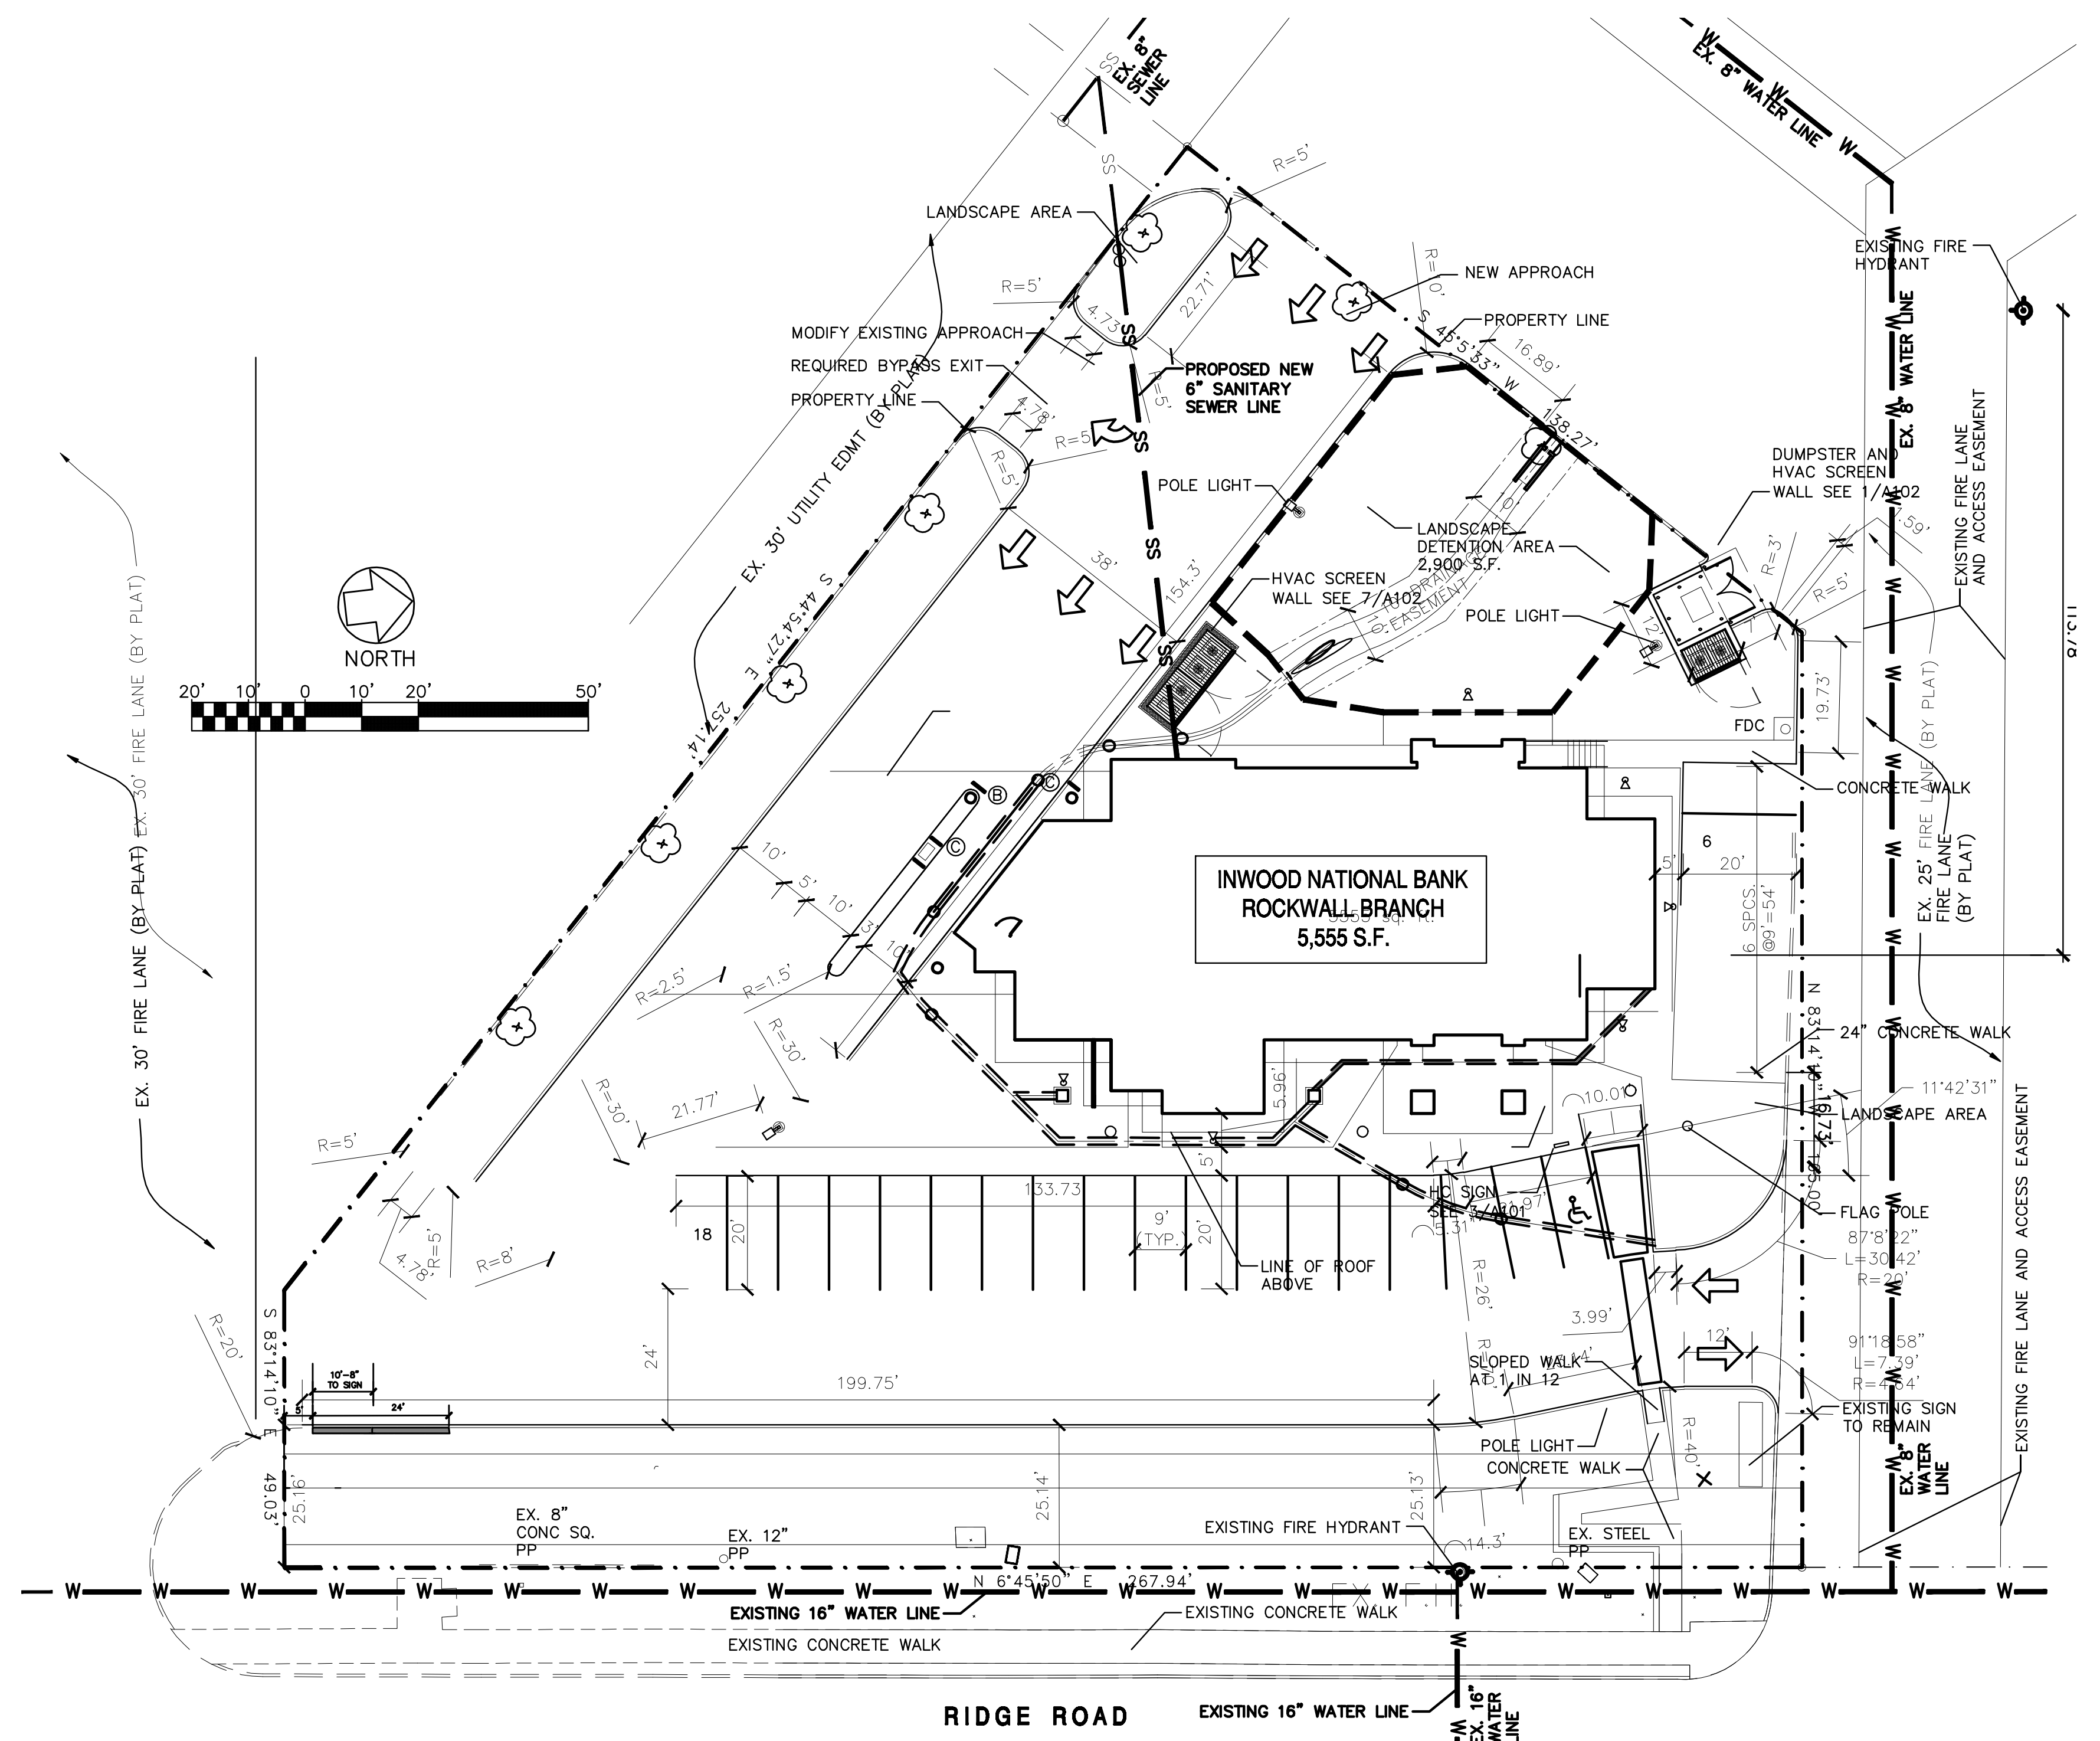

NO.	DATE	REVISION	REFLECTS CITY COMMENTS THROUGH 12-11-12	MNP BY
RECORD DRAWINGS 12-19-13				
DIMENSION CONTROL PLAN				
INWOOD NATIONAL BANK				
CITY OF ROCKWALL, TEXAS				
MP MICHAEL PEEPLES		1930 E. Rosemeade Suite 205 Engineers and Planners Firm Number: F-3754		
		Carrollton, Texas 75007 (214) 731-9948		
DATE PLOTTED: 12/23/2013		DRAWN BY: MNP		
DRAWING NO.		SCALE: AS SHOWN		
CE-1				