



LIGHT FIXTURE SCHEDULE	
A-	NEW 27.5' POLE WITH (2) 1000W. METAL HALIDE HEADS, TYPE V SQUARE LIGHT DISTRIBUTION, 480V. LITHONIA (2) #KVE3 1000M SYMC 480 SPV04 DDB/SSS 27.5 56 DM28 DDB
B-	NEW 27.5' POLE WITH (1) 1000W. METAL HALIDE HEAD, TYPE FORWARD THROW LIGHT DISTRIBUTION, 480V. LITHONIA #KVE3 1000M PFTC 480 SPV04 DDB/SSS 27.5 5C DM19 DDB
C-	NEW 27.5' POLE WITH (1) 1000W. METAL HALIDE HEAD, TYPE III ASYMMETRIC LIGHT DISTRIBUTION, 277V. LITHONIA (1) #KVE3 1000M ASYC 277 SPV04 DDB/SSS 27.5 56 DM 19 DDB
D-	EXISTING 40' POLE WITH EXISTING (2) 400W. METAL HALIDE HEADS, TYPE III ASYMMETRIC LIGHT DISTRIBUTION, 277V. NEW LOCATION - STERNER LIGHTING SYSTEM.


NEW CHILDREN'S EDUCATION BUILDING - ELECTRICAL SERVICE

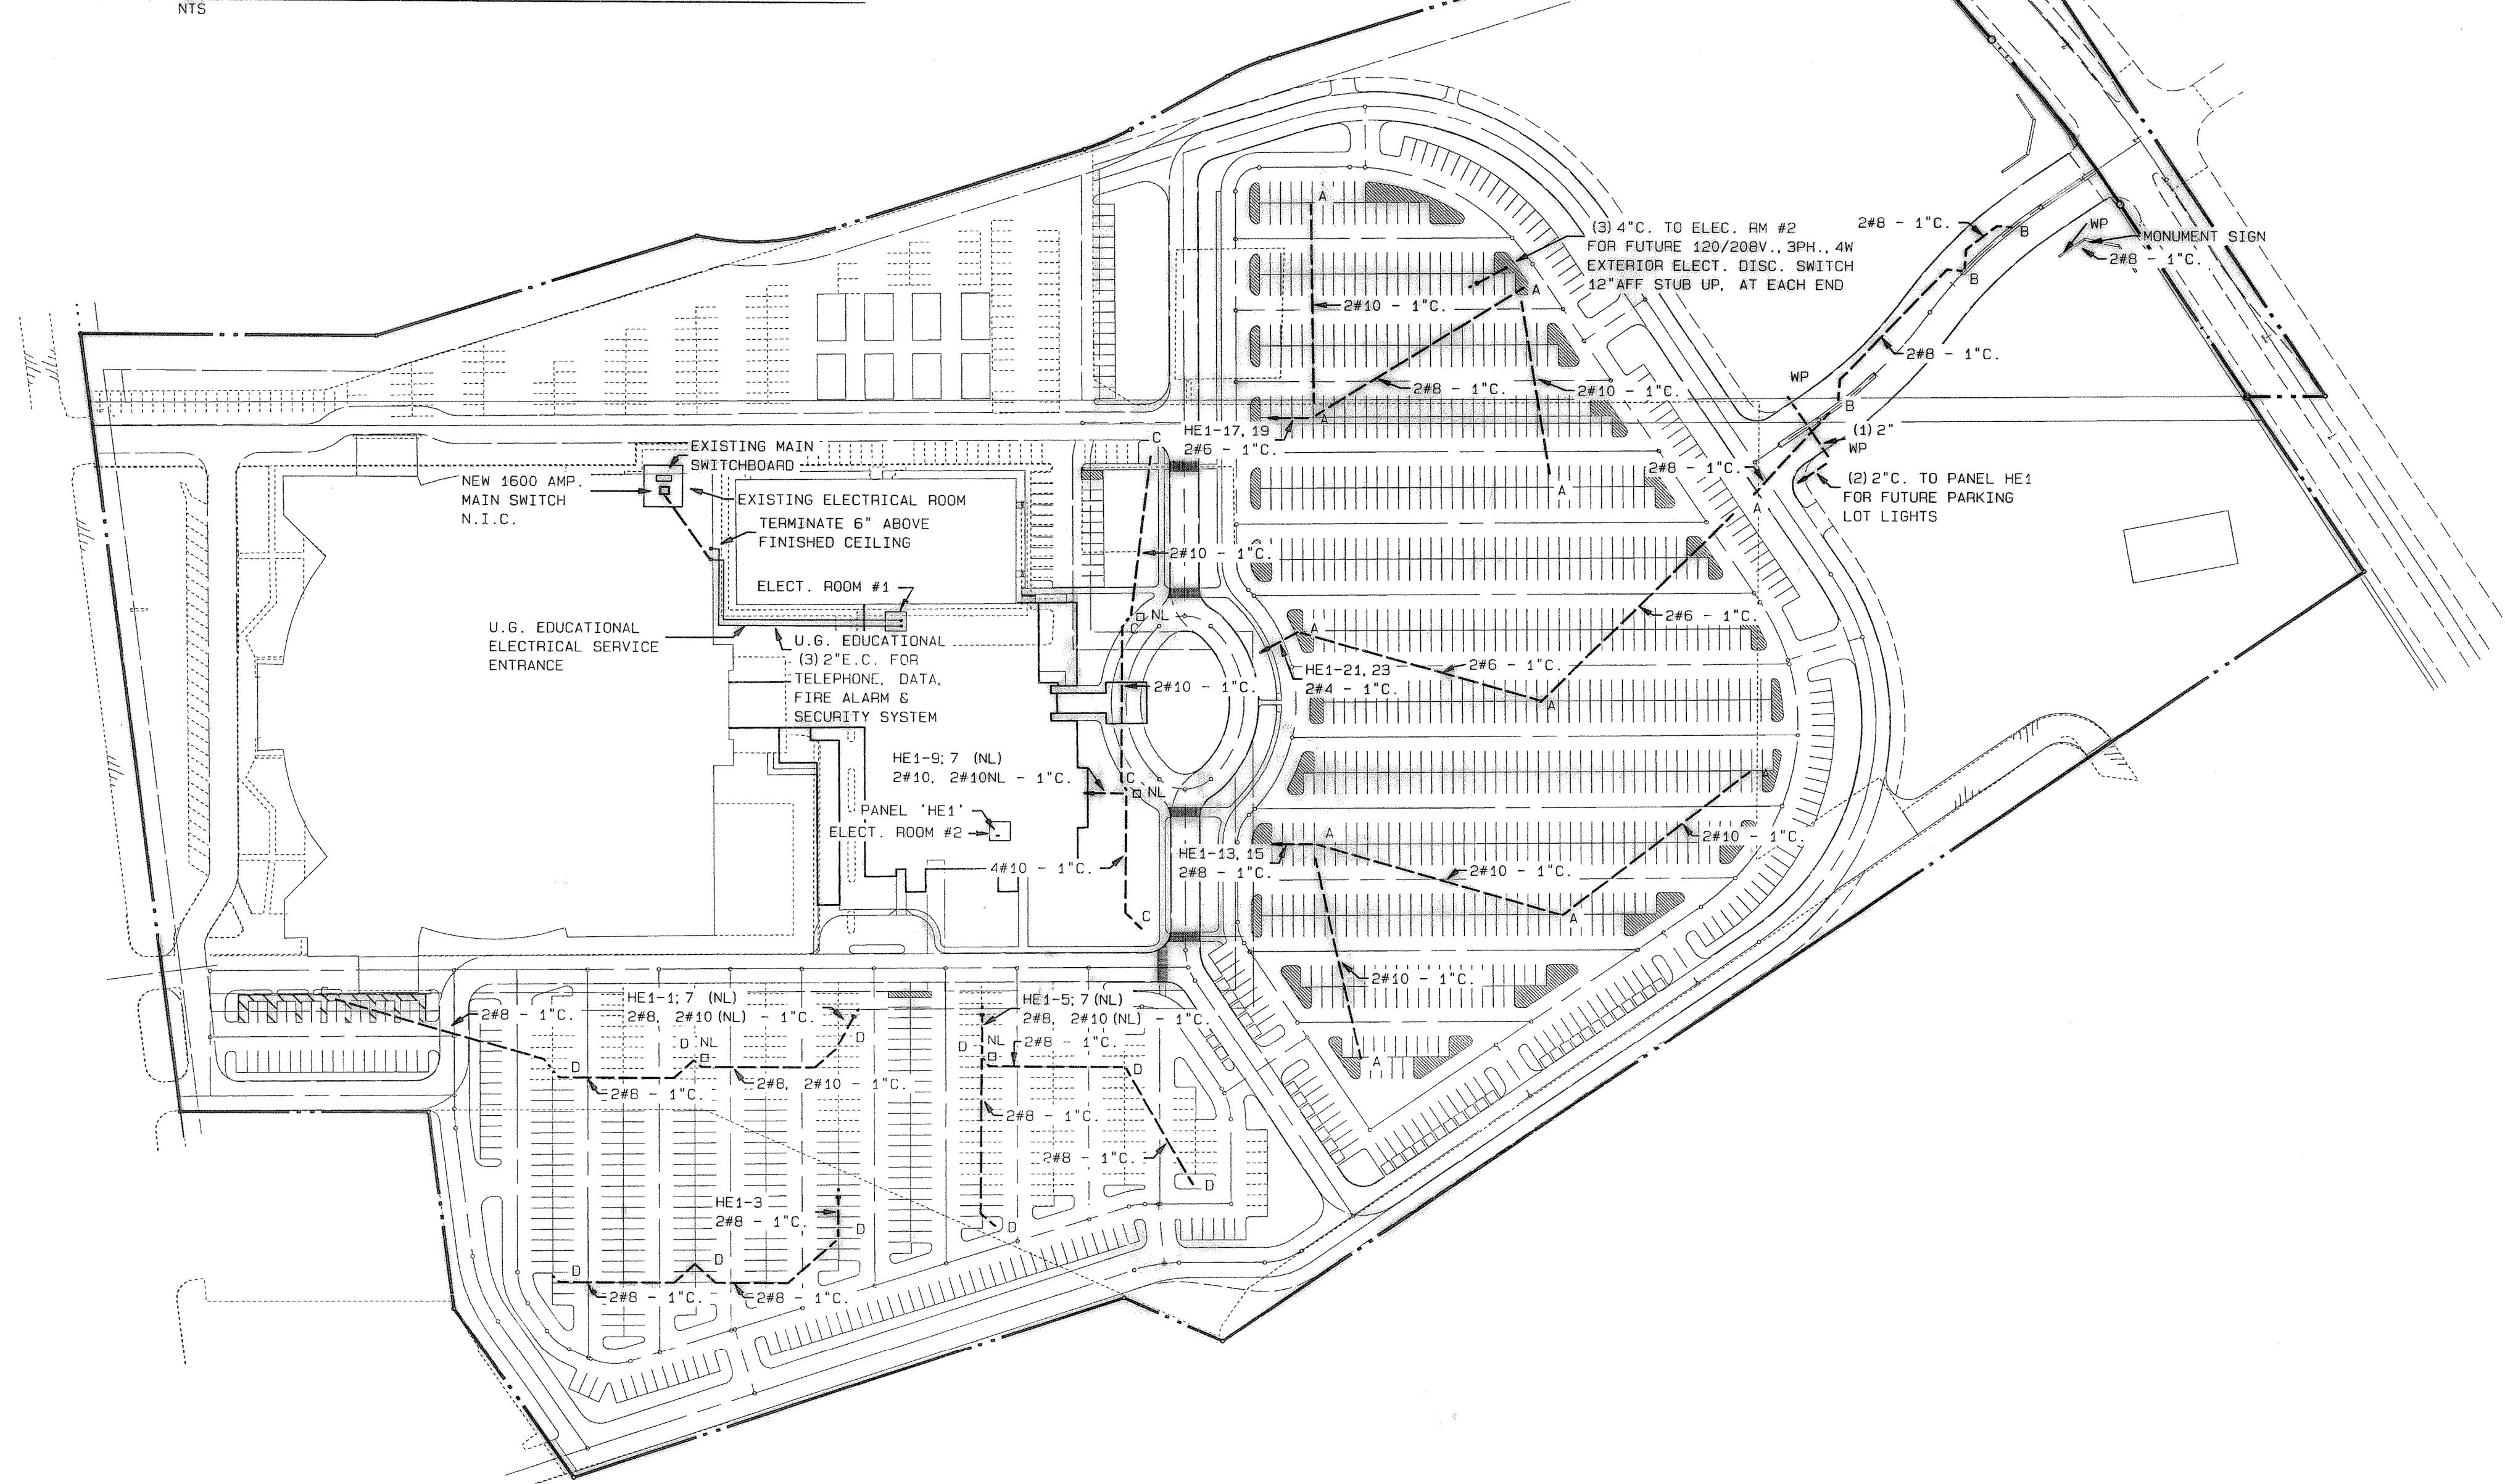

**RECORD DRAWING**  
 This is to certify that changes and corrections have been made to conform to the contractor's record of this project.  
 4/12/00  
 Graham Associates, Inc.  
 CONSULTING ENGINEERS & PLANNERS

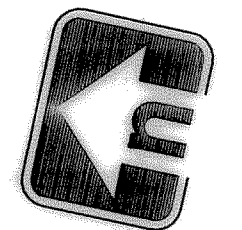

2.50

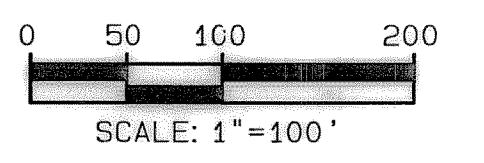

LIGHTING LAYOUT	
LOT 1, BLOCK A LAKE POINTE BAPTIST CHURCH	
CITY OF ROCKWALL ROCKWALL COUNTY, TEXAS	
Graham Associates, Inc. CONSULTING ENGINEERS & PLANNERS	
616 SIX FLAGS DRIVE, SUITE 400 ARLINGTON, TEXAS 76011 (817) 640-8535	Date JAN., 1998
Drawn By: G.A.I.	File 9762 -1011
Sheet 25 Of 27	