


STORM SEWER CURVE DATA		
CURVE NO.	①	②
Δ	45° 02' 59"	30° 00' 00"
R	625.00'	65.00'
T	259.20'	17.42'
L	491.42'	34.03'

- LEGEND**
- ⓑ - BLOCK LABEL
  - Ⓢ - INLET NUMBER
  - ① - CURVE NUMBER
  - - SANITARY SEWER
  - ⊕ - WATER
  - ▬ - PROPOSED STORM SEWER
  - ▬▬▬ - EXISTING STORM SEWER

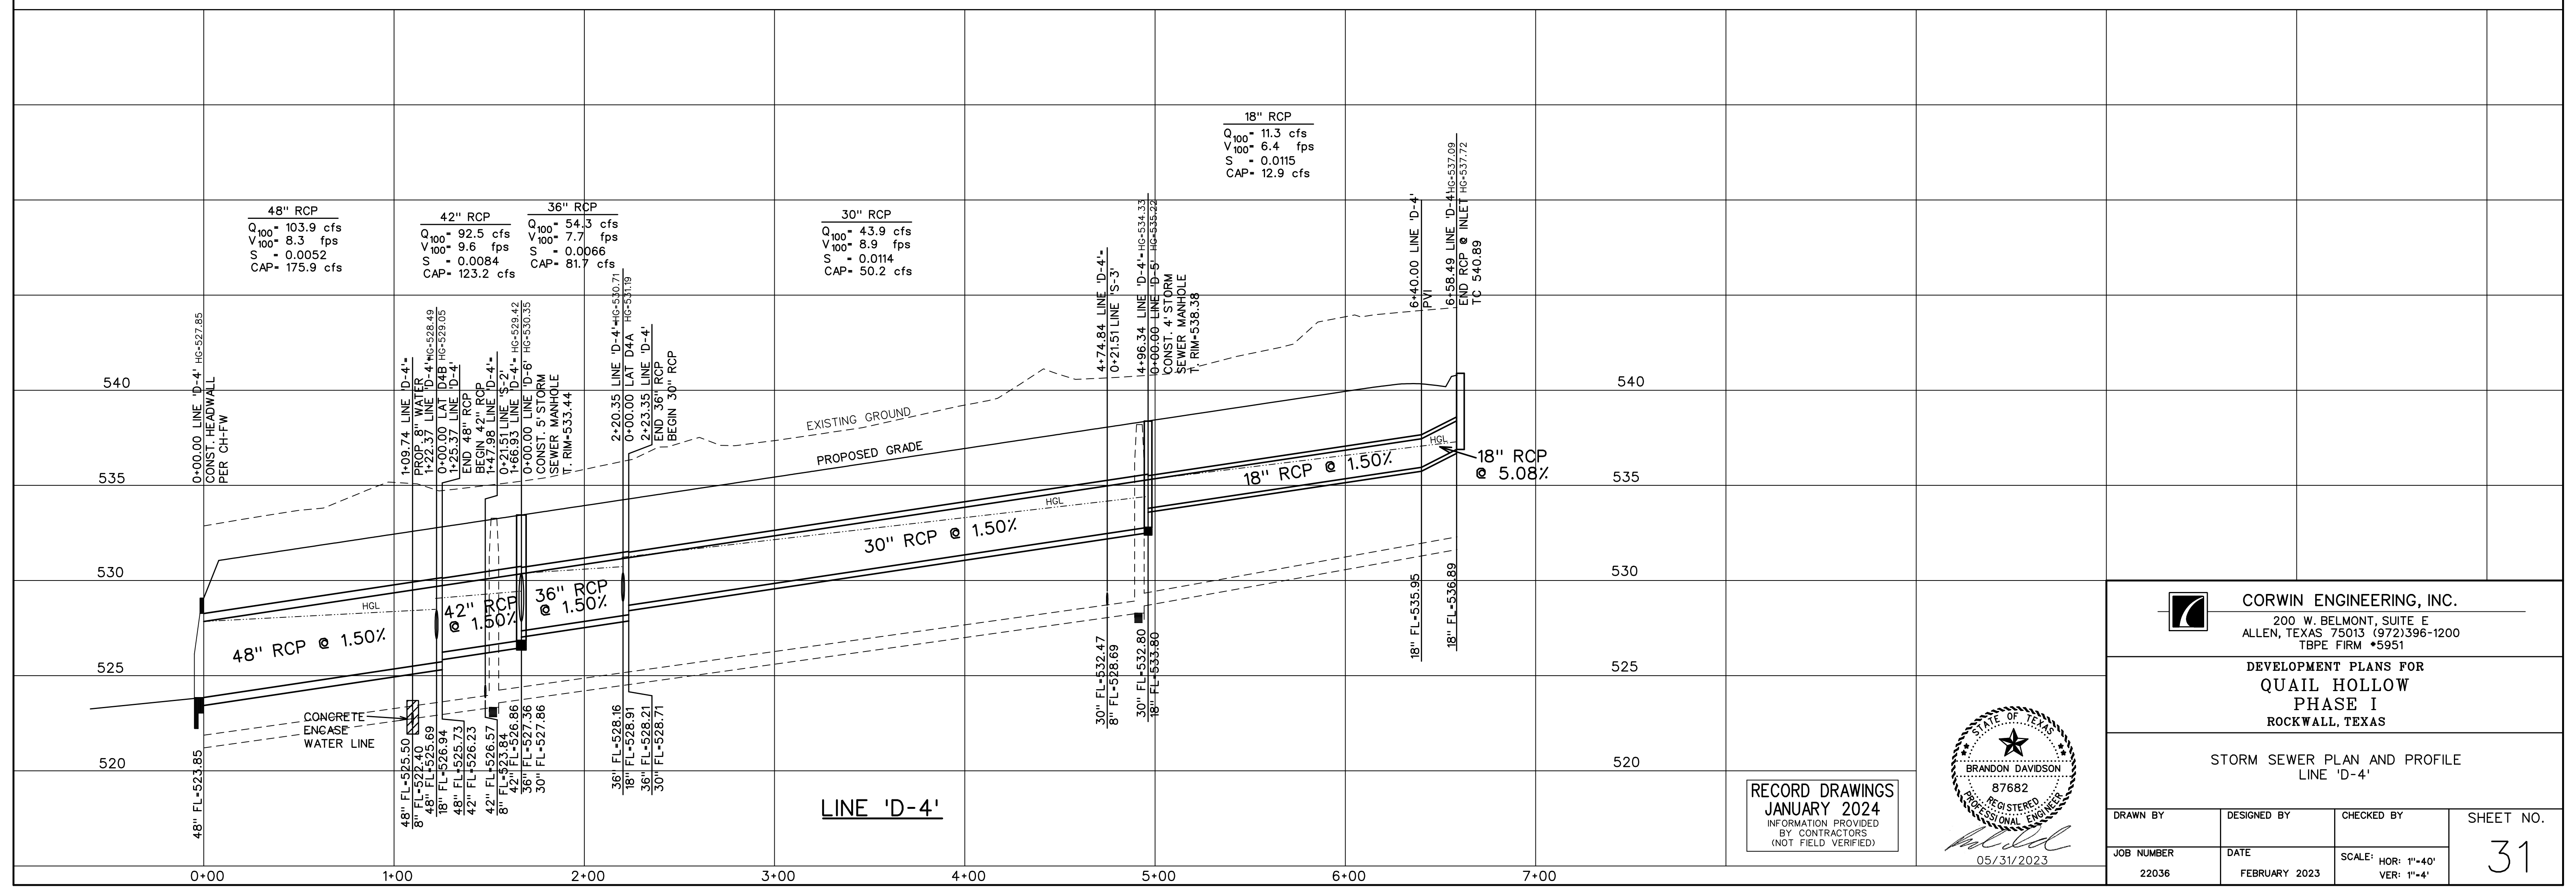

RECORD DRAWINGS  
 JANUARY 2024  
 INFORMATION PROVIDED  
 BY CONTRACTORS  
 (NOT FIELD VERIFIED)



**CORWIN ENGINEERING, INC.**  
 200 W. BELMONT, SUITE E  
 ALLEN, TEXAS 75013 (972)396-1200  
 TBPE FIRM #5951

DEVELOPMENT PLANS FOR  
**QUAIL HOLLOW**  
 PHASE I  
 ROCKWALL, TEXAS

STORM SEWER PLAN AND PROFILE  
 LINE 'D-4'

DRAWN BY	DESIGNED BY	CHECKED BY	SHEET NO.
JOB NUMBER	DATE	SCALE: HOR: 1"=40' VER: 1"=4'	31
22036	FEBRUARY 2023		