


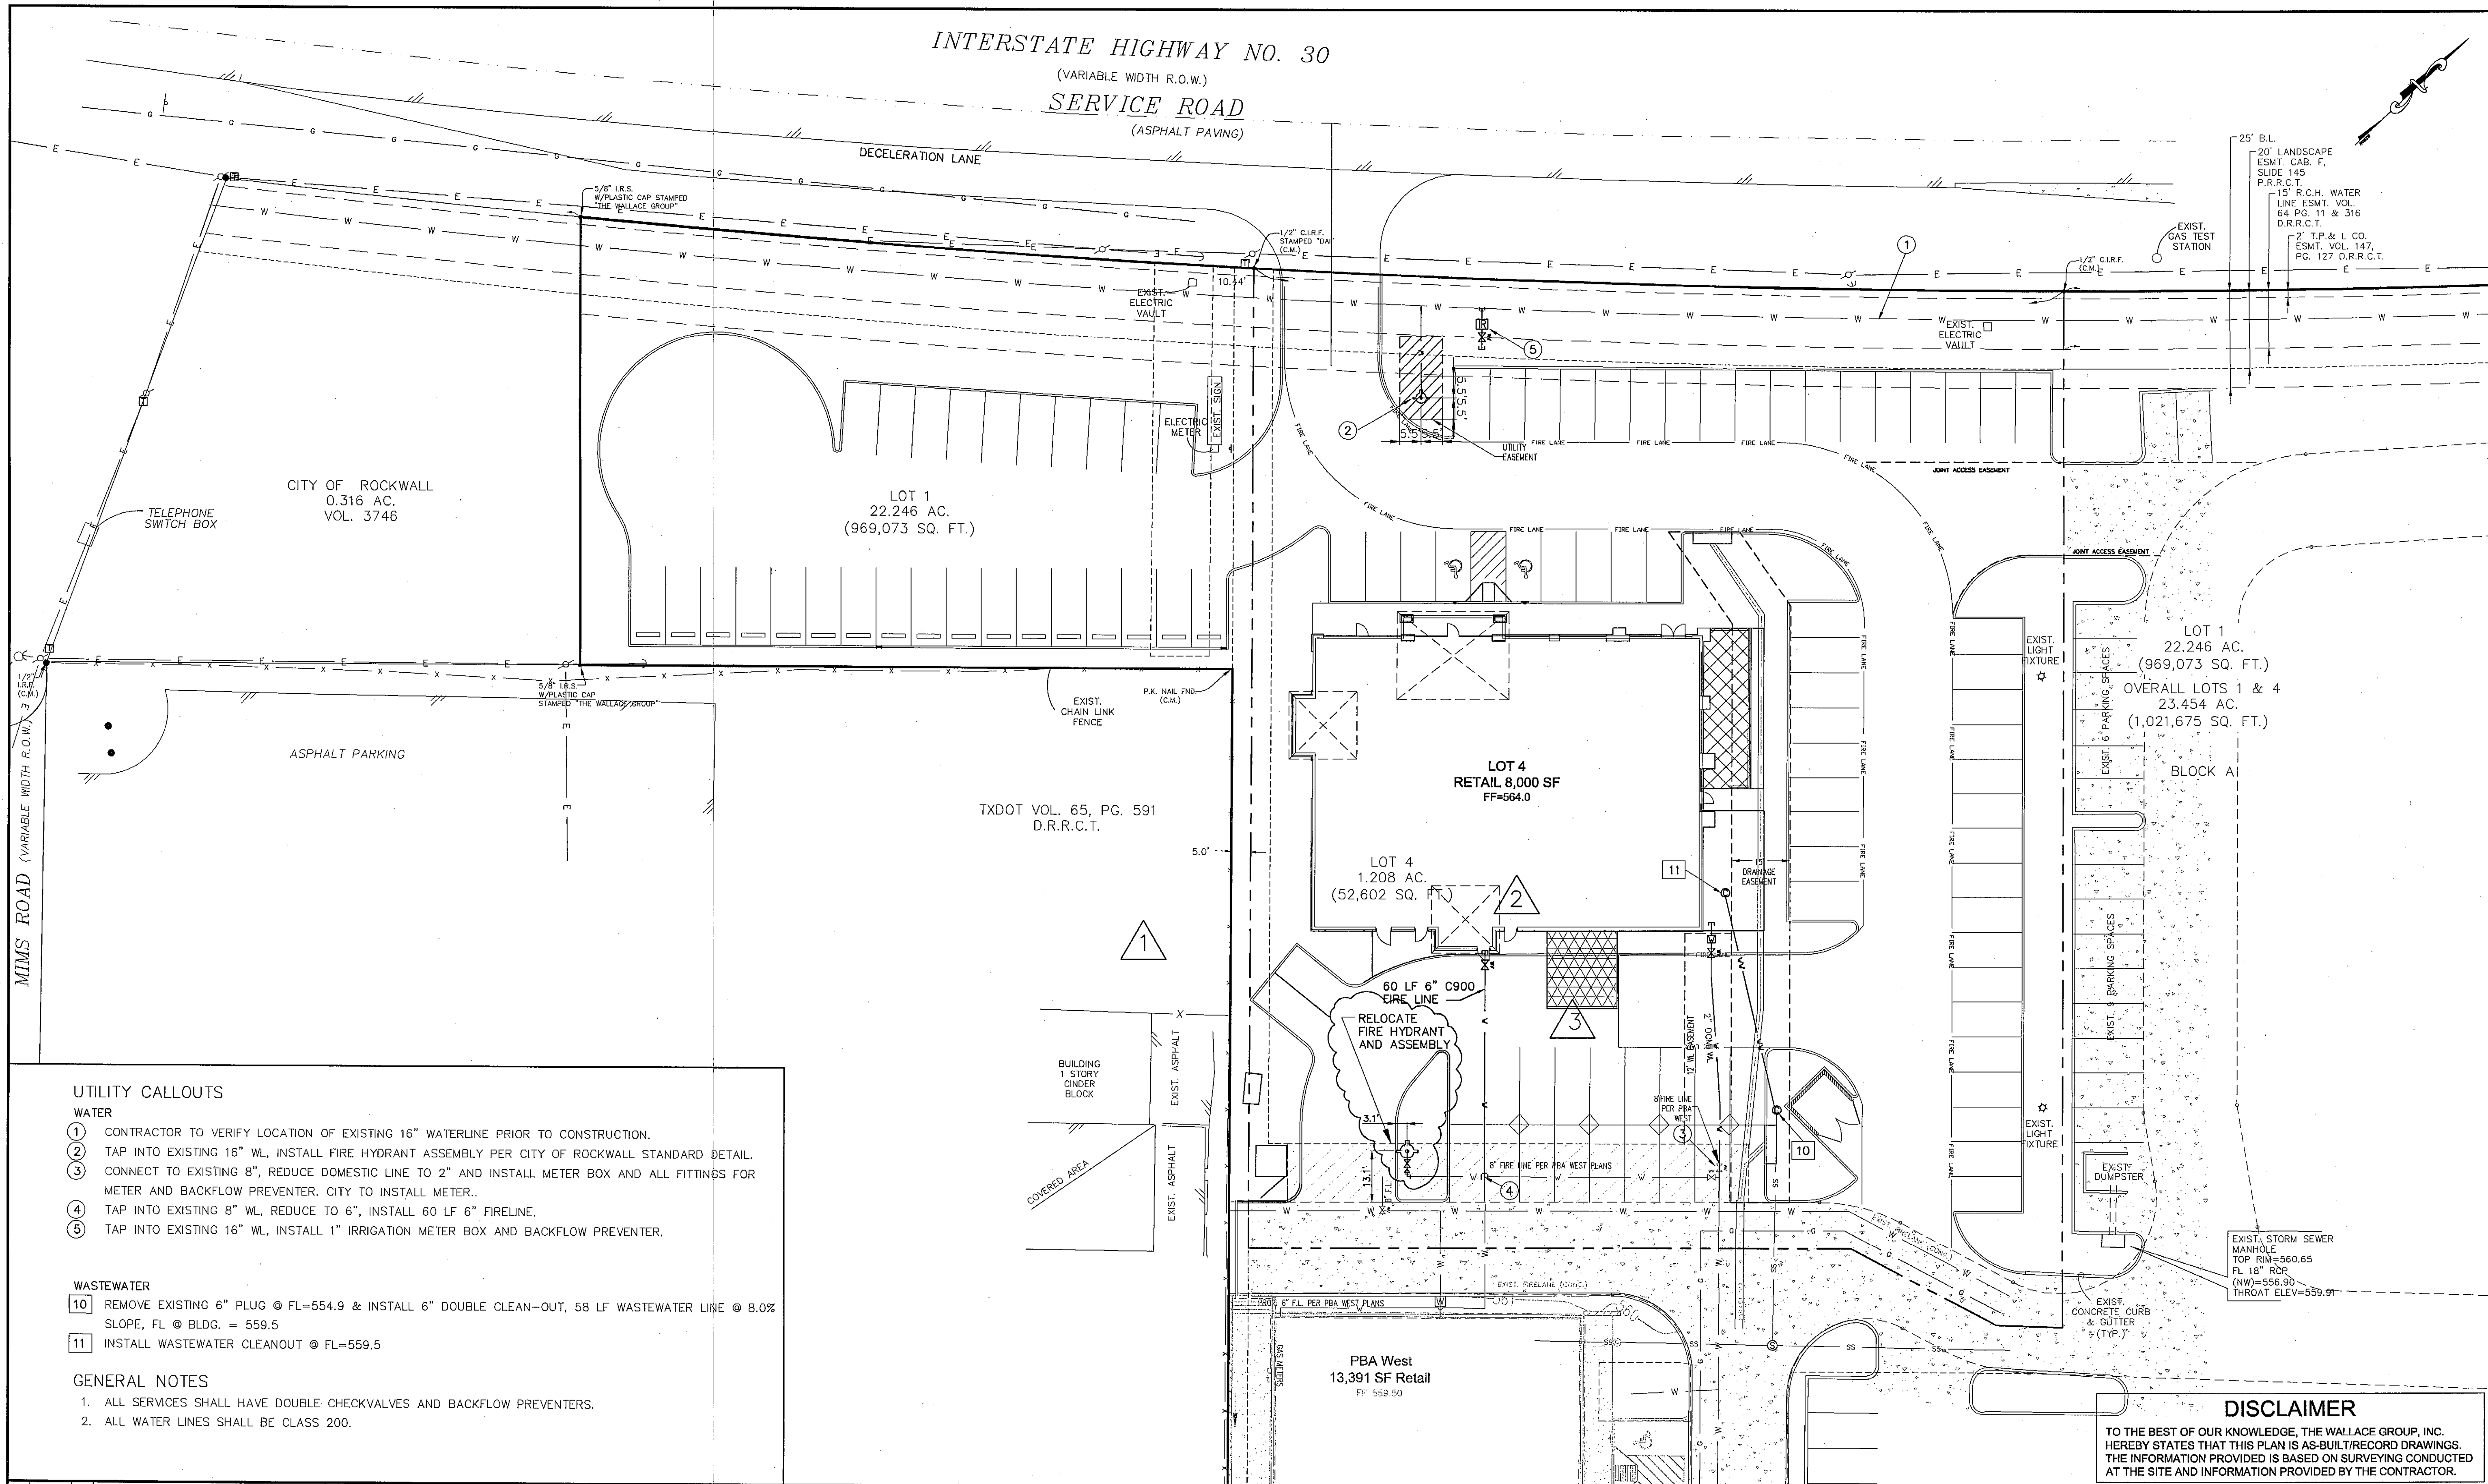

								DESIGNED: <u>RDC</u>				"THE SEAL APPEARING ON THIS DOCUMENT WAS AUTHORIZED BY MATT D. MORGAN, P.E. #68929 ON THE DATE SHOWN ON THE DATESHEET. ALTERATION OF A SEALED DOCUMENT WITHOUT PROPER NOTIFICATION TO THE RESPONSIBLE ENGINEER IS AN OFFENSE UNDER THE TEXAS ENGINEERING PRACTICE ACT"		ENGINEERS THE WALLACE GROUP INC. SURVEYORS ARCHITECTS PLANNERS				ROCKWALL CROSSING		SHEET C4.0																	
						(IN FEET)		DRAWN: <u>SRM</u>										8000 SQ. FT. RETAIL BUILDING																			
								CHECKED: <u>RDC</u>						UTILITY PLAN				OF 12 SHEETS																			
<table><tr><td>Δ</td><td>6/12/07</td><td>MDM</td><td>RELOCATED FIRE HYDRANT FOR NEW CURB</td></tr><tr><td>Δ</td><td>4/2/07</td><td>MDM</td><td>RELOCATED FIRE LINE</td></tr><tr><td>Δ</td><td>1/8/07</td><td>MDM</td><td>SITE LAYOUT REVISION</td></tr><tr><td>REV</td><td>DATE</td><td>BY</td><td>DESCRIPTION</td></tr></table>				Δ	6/12/07	MDM	RELOCATED FIRE HYDRANT FOR NEW CURB	Δ	4/2/07	MDM	RELOCATED FIRE LINE	Δ	1/8/07							MDM	SITE LAYOUT REVISION	REV	DATE	BY	DESCRIPTION							<table><tr><td>5/10/08</td><td><i>Matthew D. Morgan</i></td></tr><tr><td>DATE</td><td>NAME</td></tr></table>		5/10/08	<i>Matthew D. Morgan</i>	DATE	NAME
Δ	6/12/07	MDM	RELOCATED FIRE HYDRANT FOR NEW CURB																																		
Δ	4/2/07	MDM	RELOCATED FIRE LINE																																		
Δ	1/8/07	MDM	SITE LAYOUT REVISION																																		
REV	DATE	BY	DESCRIPTION																																		
5/10/08	<i>Matthew D. Morgan</i>																																				
DATE	NAME																																				