


**LEGEND**

|  |                              |  |                                 |
|--|------------------------------|--|---------------------------------|
|  | PROPOSED STORM DRAIN         |  | PROPOSED CURB INLET             |
|  | PROPOSED WATER LINE          |  | PROPOSED JUNCTION BOX           |
|  | PROPOSED SANITARY SEWER LINE |  | PROPOSED HEADWALL               |
|  | EXISTING STORM DRAIN         |  | EXISTING CURB INLET             |
|  | EXISTING WATER LINE          |  | EXISTING STORM MANHOLE          |
|  | EXISTING SANITARY SEWER LINE |  | EXISTING SANITARY SEWER MANHOLE |

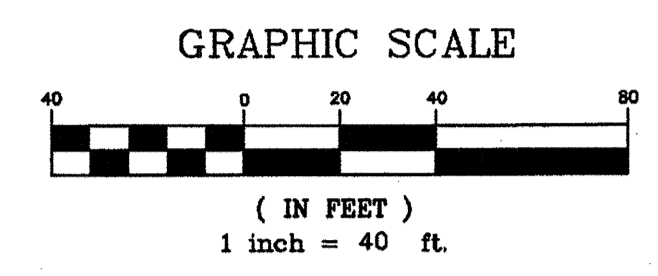

**NOTE:**


1. CONTRACTOR SHALL END ROOF DRAIN LEADERS 5' FROM THE BUILDING AND CAP FOR FUTURE EXTENSION.

**LINE TABLE**


| LINE | LENGTH | BEARING     | PIPE SIZE |
|------|--------|-------------|-----------|
| L27  | 4.71   | S88°16'23"W | 8"        |
| L28  | 9.83   | S43°16'20"W | 8"        |
| L29  | 5.66   | S88°16'23"W | 8"        |
| L30  | 9.17   | S43°16'20"W | 8"        |
| L31  | 3.66   | S88°16'23"W | 8"        |
| L32  | 8.58   | S43°16'20"W | 8"        |

1. According to the Flood in the Federal Emergency Mgmt. property shown herein above by the 100-year flood.

**LINE SD-B**

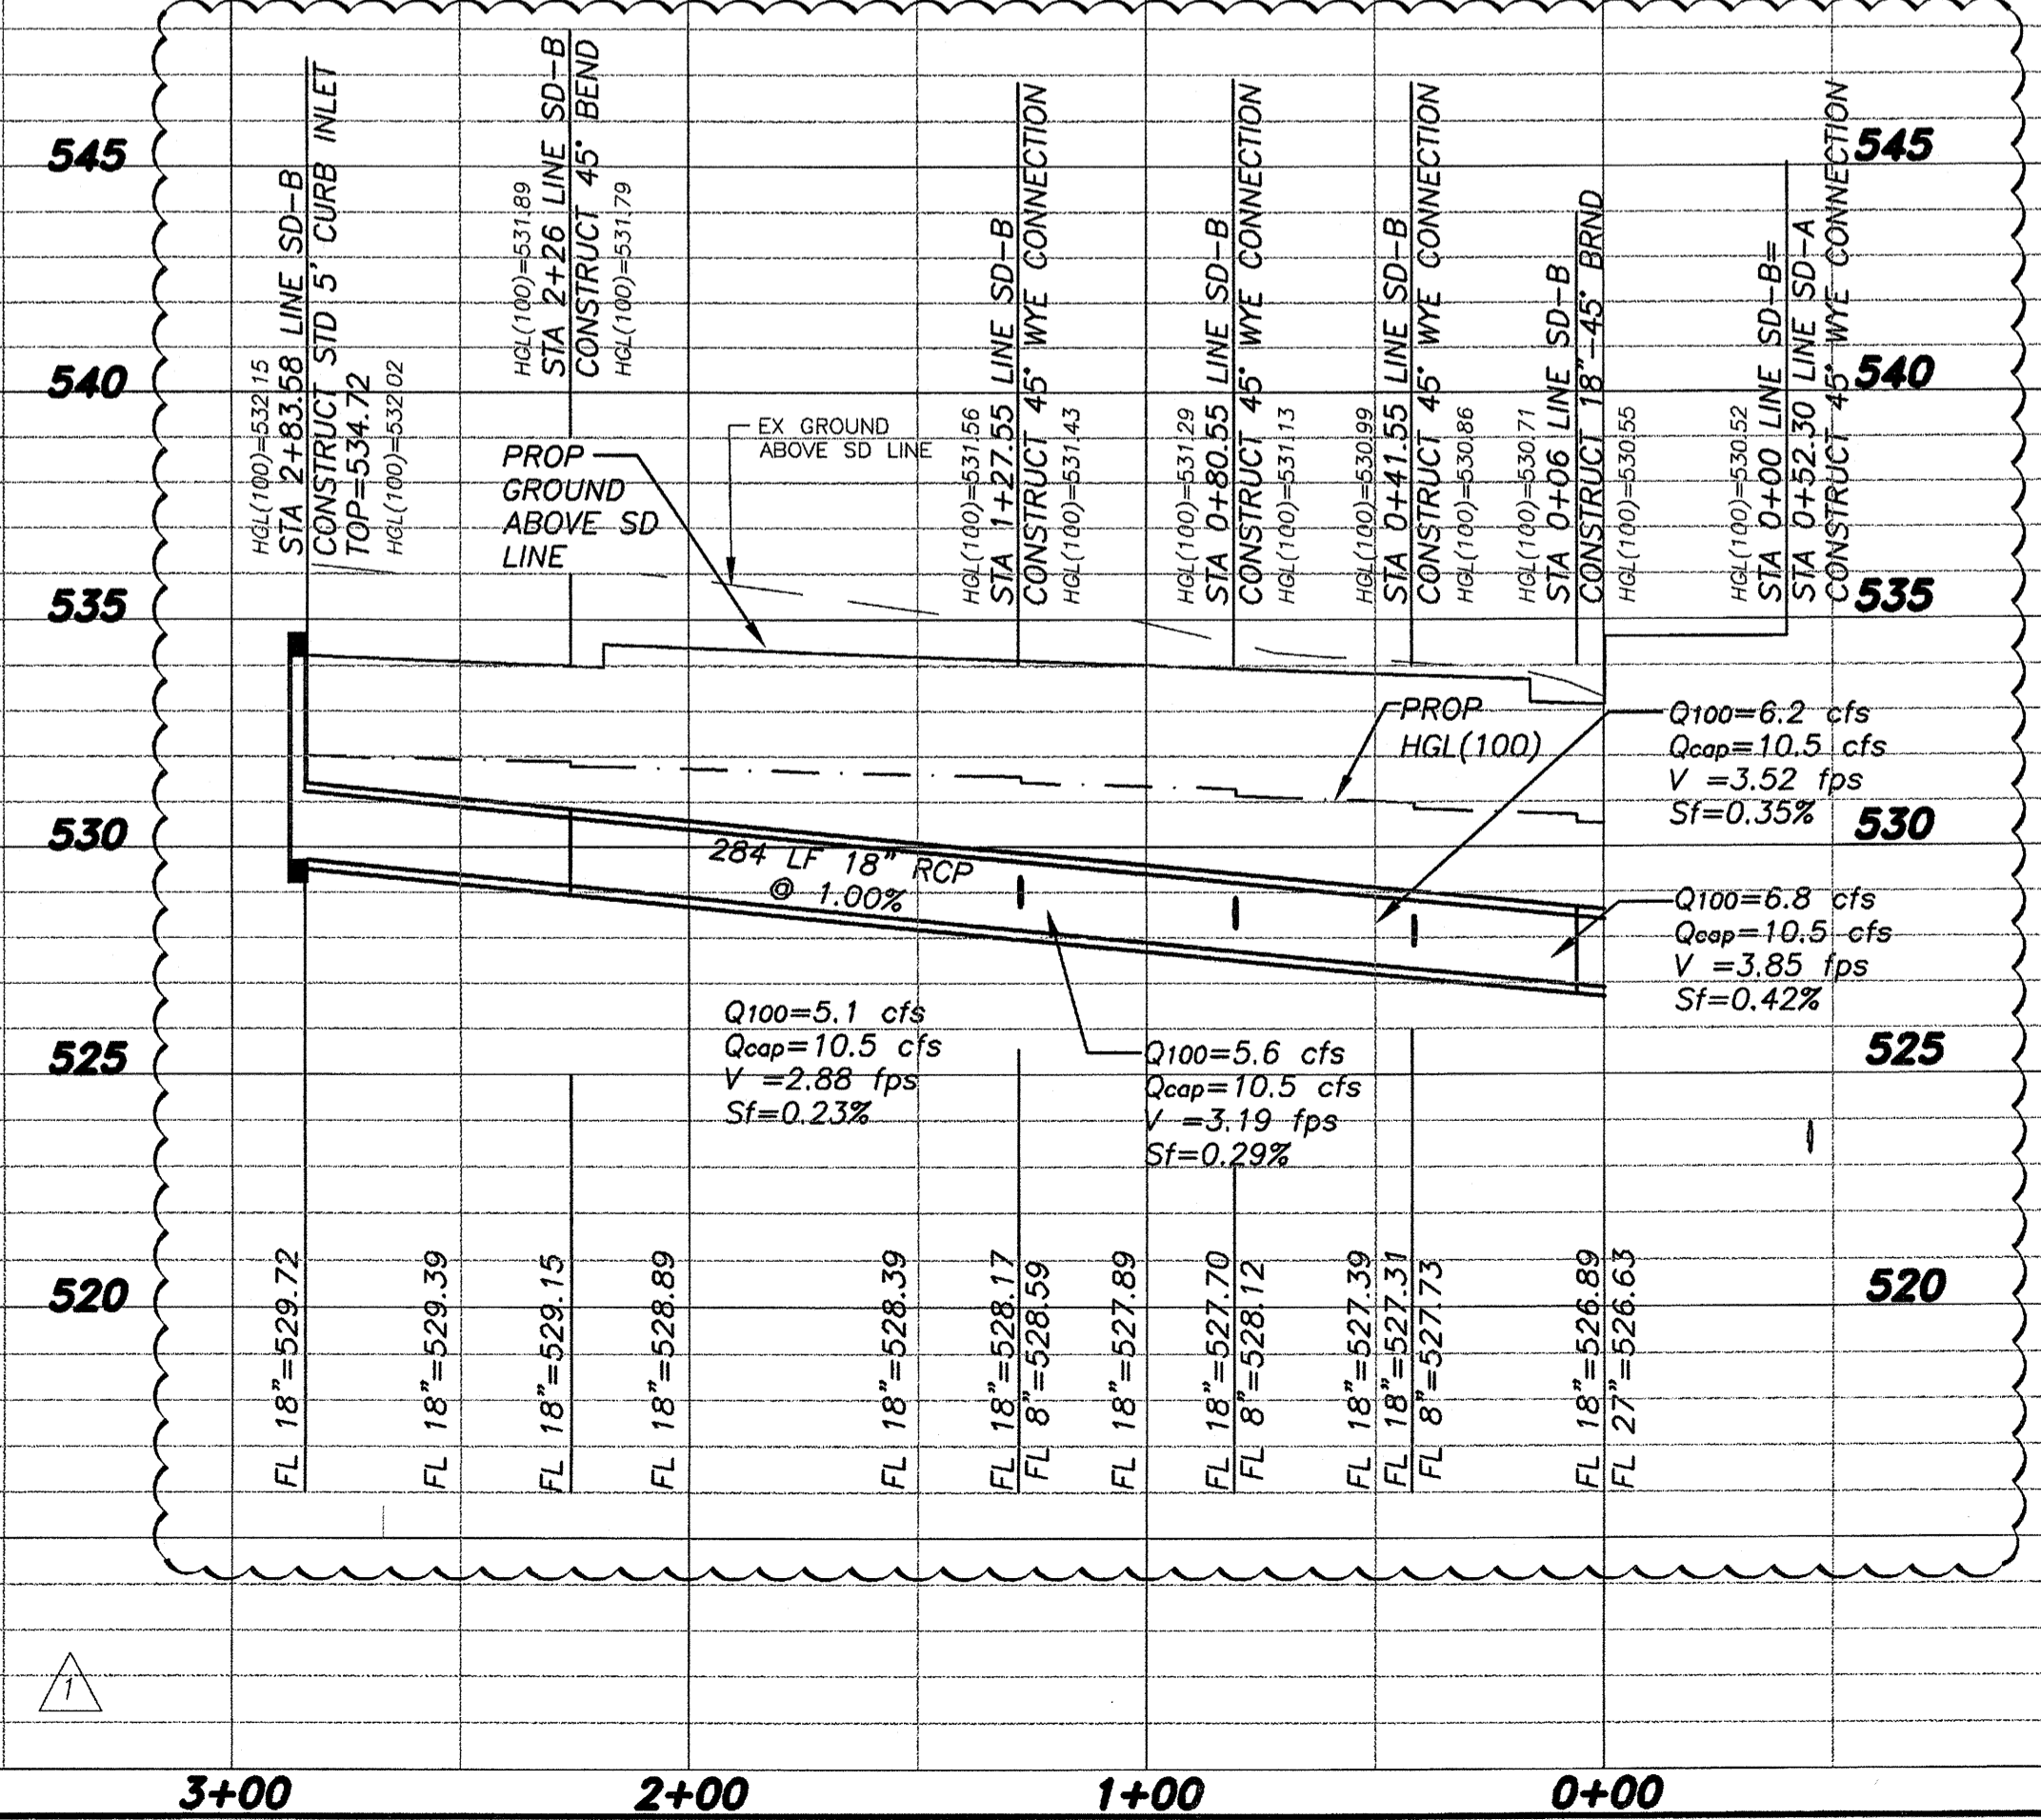

**RECORD DRAWING**  
THIS DRAWING REFLECTS REVISIONS AS FIELD VERIFIED BY ENGINEER AND CONTRACTOR  
DATE: 4/4/08

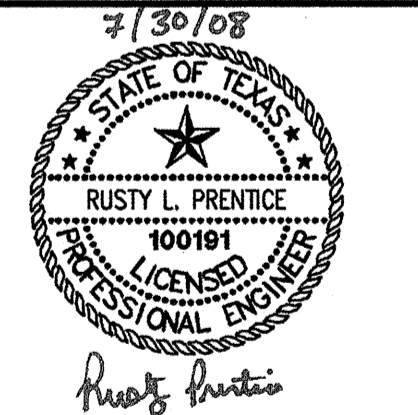

THE SEAL APPEARING ON THIS DOCUMENT WAS AUTHORIZED BY RUSTY L. PRENTICE, P.E. 100191 ON 07/30/08 ALTERATION OF A SEALED DOCUMENT WITHOUT PROPER NOTIFICATION TO THE RESPONSIBLE ENGINEER IS AN OFFENSE UNDER THE TEXAS ENGINEERING PRACTICE ACT.

**PATE ENGINEERS**

8150 BROOKRIVER DRIVE  
SUITE 5-700  
DALLAS, TEXAS, 75247  
PH. (214) 357-2981  
FAX (214) 357-2985

JOB NO. 182800100

| REVISION NUMBER | DATE     | DESCRIPTION         |
|-----------------|----------|---------------------|
| 1               | 07/30/08 | REVISED STORM DRAIN |

**ROCKWALL MEDICAL OFFICE**  
LOTS 14 AND 15, BLOCK A  
PRESBYTERIAN HOSPITAL OF ROCKWALL ADDN  
STORM DRAIN PLAN AND PROFILE  
LINE SD-B

CITY OF ROCKWALL  
ROCKWALL COUNTY, TEXAS

| DRAWN BY | DESIGNED BY | CHECKED BY | DATE    | SCALE                 | SHEET NUMBER |
|----------|-------------|------------|---------|-----------------------|--------------|
| PATE     | PATE        | RLP        | 07/2008 | H: 1"=40'<br>V: 1"=4' | <b>C3.3</b>  |