



LIGHT STD.DETAIL NTS

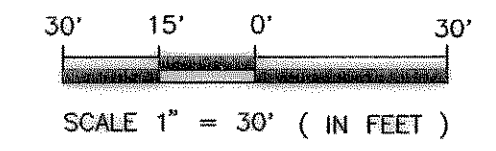

CONTRACTOR SHALL VERIFY ALL CONDITIONS AND DIMENSIONS AT THE JOB SITE AND NOTIFY THE ARCHITECTS OF ANY DIMENSIONAL DISCREPANCIES BEFORE BEGINNING OR FABRICATING ANY WORK - DO NOT SCALE DRAWINGS.  
 THESE DOCUMENTS, THE IDEAS AND THE DECISIONS INCORPORATED HEREIN ARE THE PROPERTY OF SALTGRASS, INC. AND ARE NOT TO BE USED IN WHOLE OR IN PART FOR ANY OTHER PROJECT WITHOUT WRITTEN AUTHORIZATION OF SALTGRASS, INC.

SALTGRASS STEAK HOUSE  
 9039 KATY FREEWAY, SUITE 250  
 HOUSTON, TX 77024  
 PHONE: 713-300-2000  
 FAX: 713-300-2000

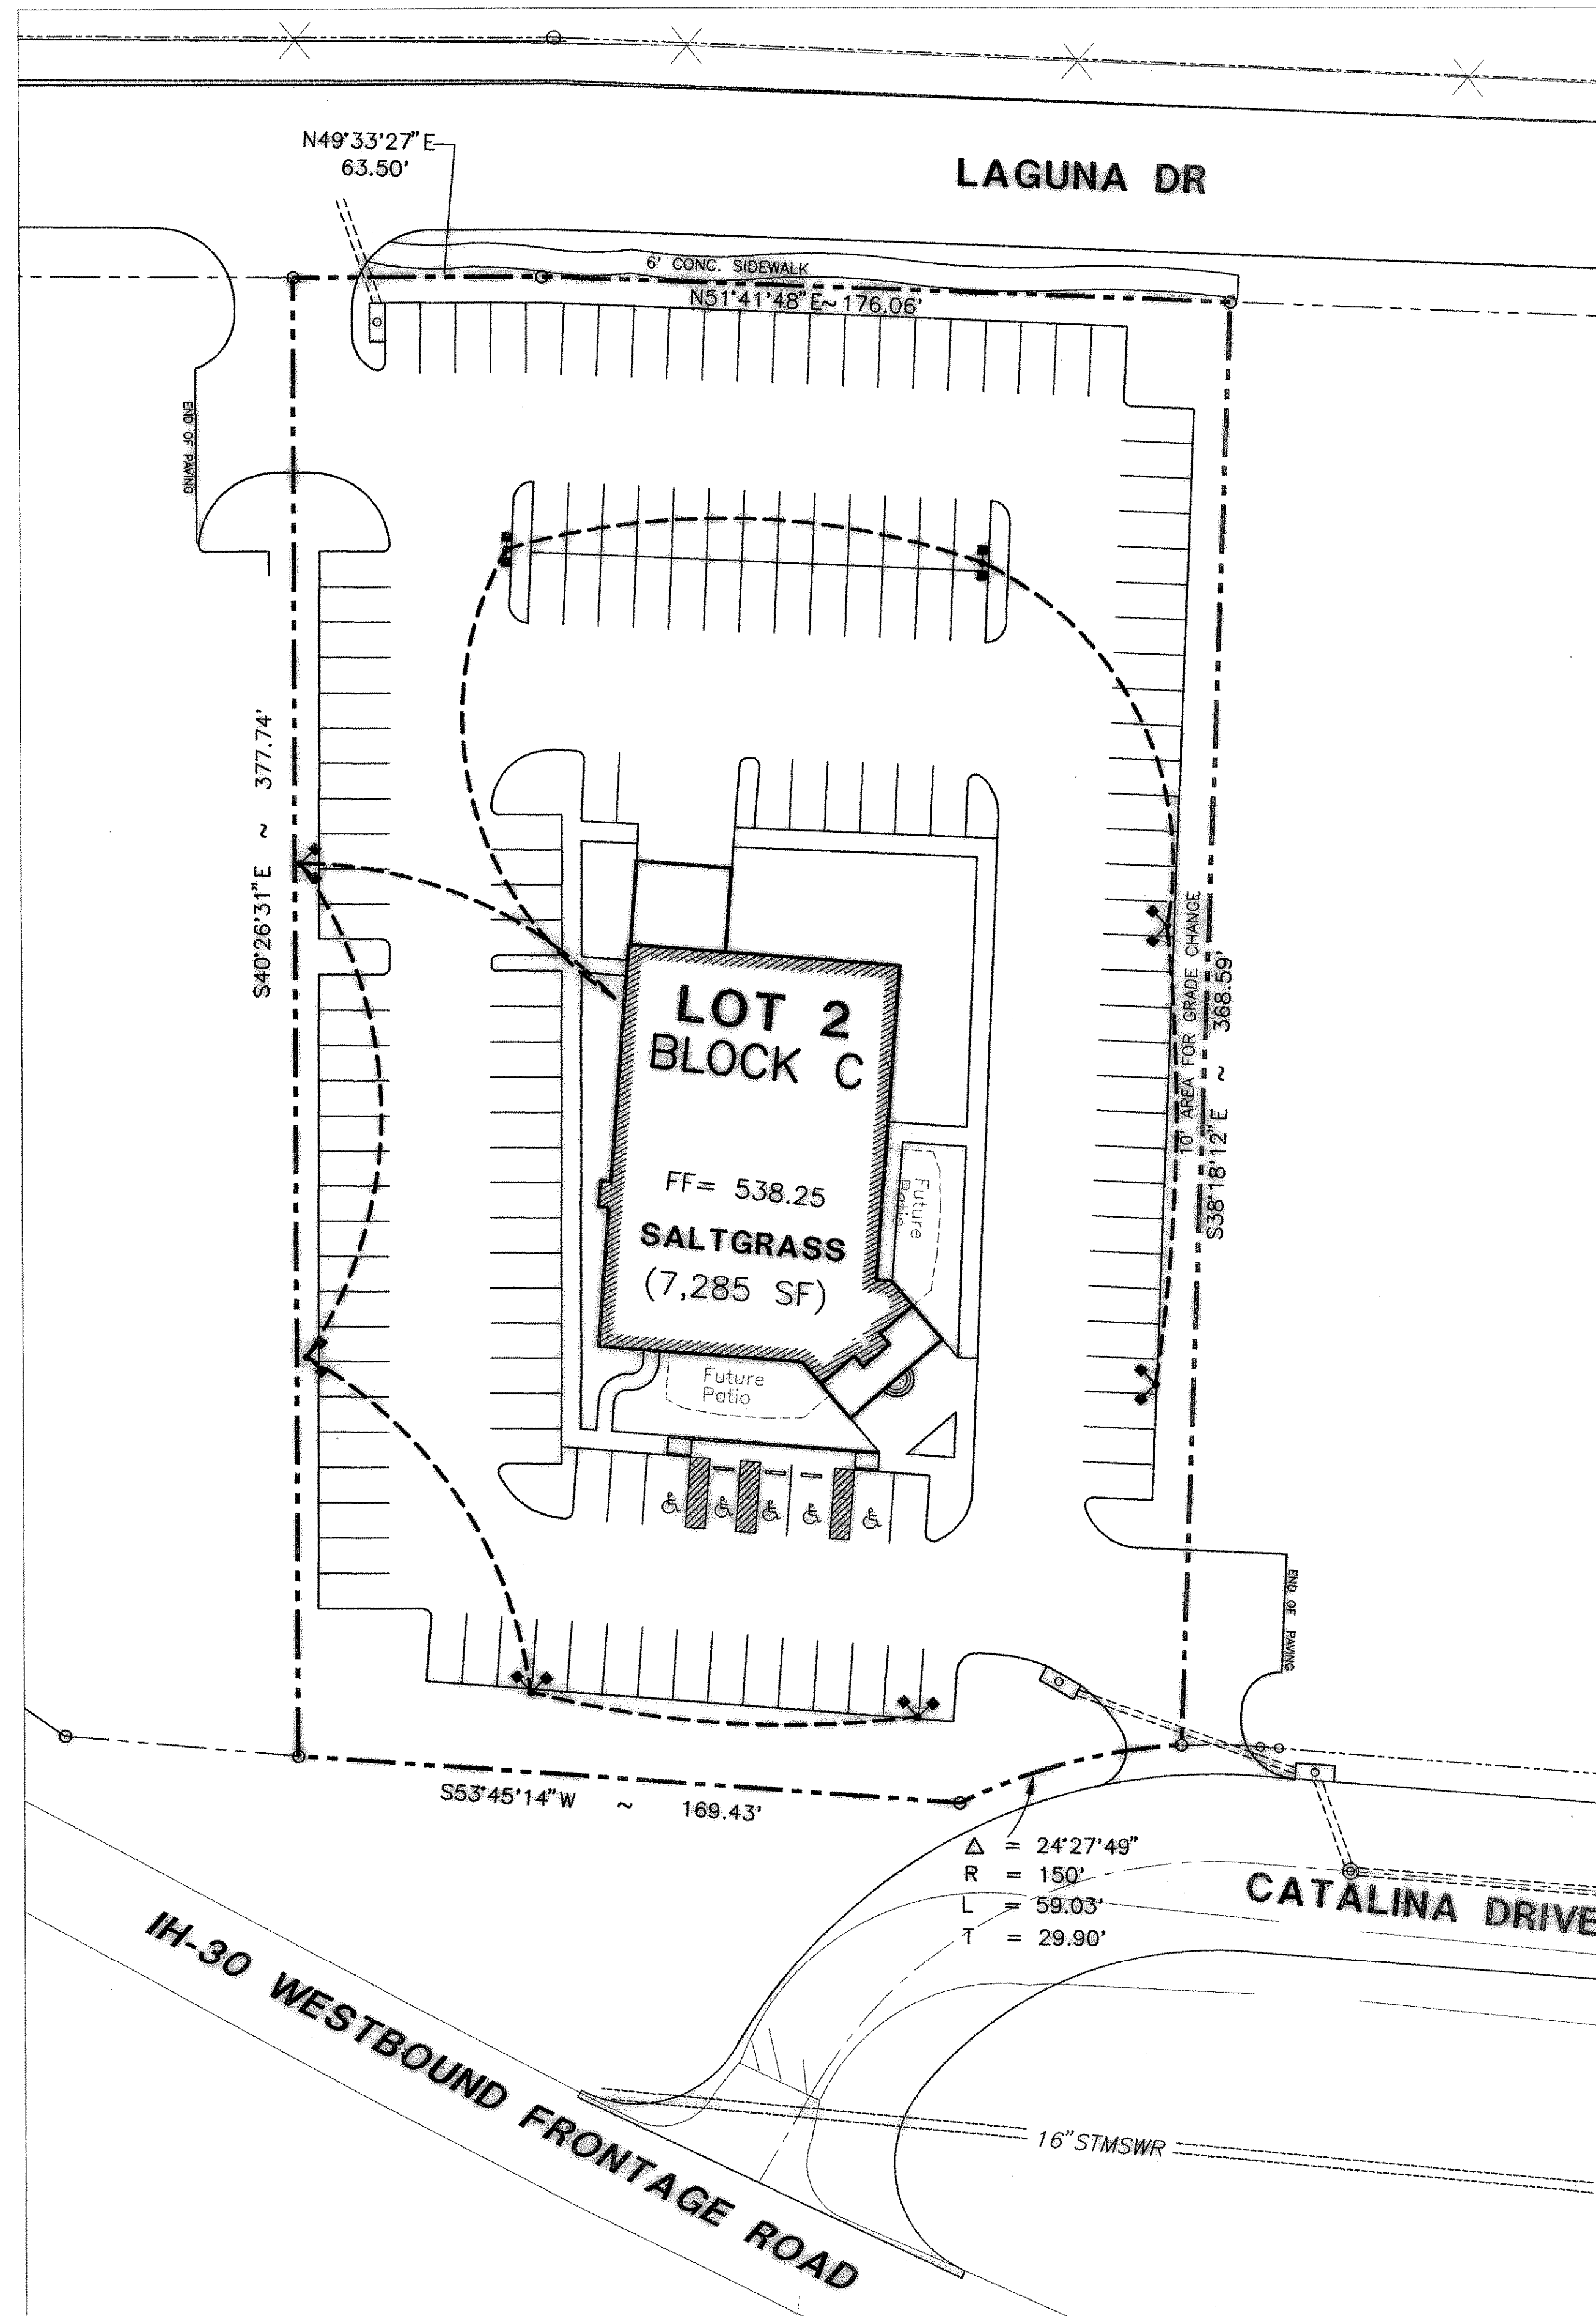

SITE LIGHTING PLAN  
 SALT GRASS STEAK HOUSE  
 IH-30 @ HORIZON ROAD  
 ROCKWALL, TEXAS

ASA ENGINEERING  
 17819 DALLAS, TEXAS 75242  
 (972) 248-8651  
 FAX (972) 248-8651

NO.	DATE	DESCRIPTION

ISSUE DATE: 7/17/00  
 ISSUED FOR:  
 PERMIT \_\_\_\_\_  
 ADA \_\_\_\_\_  
 BID \_\_\_\_\_  
 CONST. \_\_\_\_\_  
 DRAWN BY: MIR ALL  
 CHECKED BY: \_\_\_\_\_  
 SG Q.C. BY: \_\_\_\_\_  
 DATE: \_\_\_\_\_  
 VERSION: \_\_\_\_\_

