



LEGEND	
	FIRE HYDRANT
	WATER METER
	MANHOLE
	TREE
	LIGHT POLE
+TP600.0	EX. TOP OF PVMT.
+TC600.0	EX. TOP OF CONC.
+TG600.0	EX. TOP OF GRND.
+ETC600.0	EX. TOP OF CURB
+600.0	FIN. FLR. SPOT ELEV.
+TP600.0	TOP OF PAVEMENT
+TC600.0	TOP OF CONCRETE
+TG600.0	TOP OF GROUND
+600.0	TOP OF CURB
-650-	PROP. GRADE LINE
-650-	EX. GRADE LINE
FF	FINISHED FLOOR
↑	GUY WIRE ANCHOR
•	POWER POLE
+	STREET/CABLE SIGN
⊕	WATER VALVE
□	UTILITY BOX
○	WOOD BOLLARD
○	GAS METER
■	CURB INLET
■	GRATE INLET
○	UTILITY MANHOLE
○	STORM MANHOLE
○	SWB MANHOLE
□	MAIL BOX

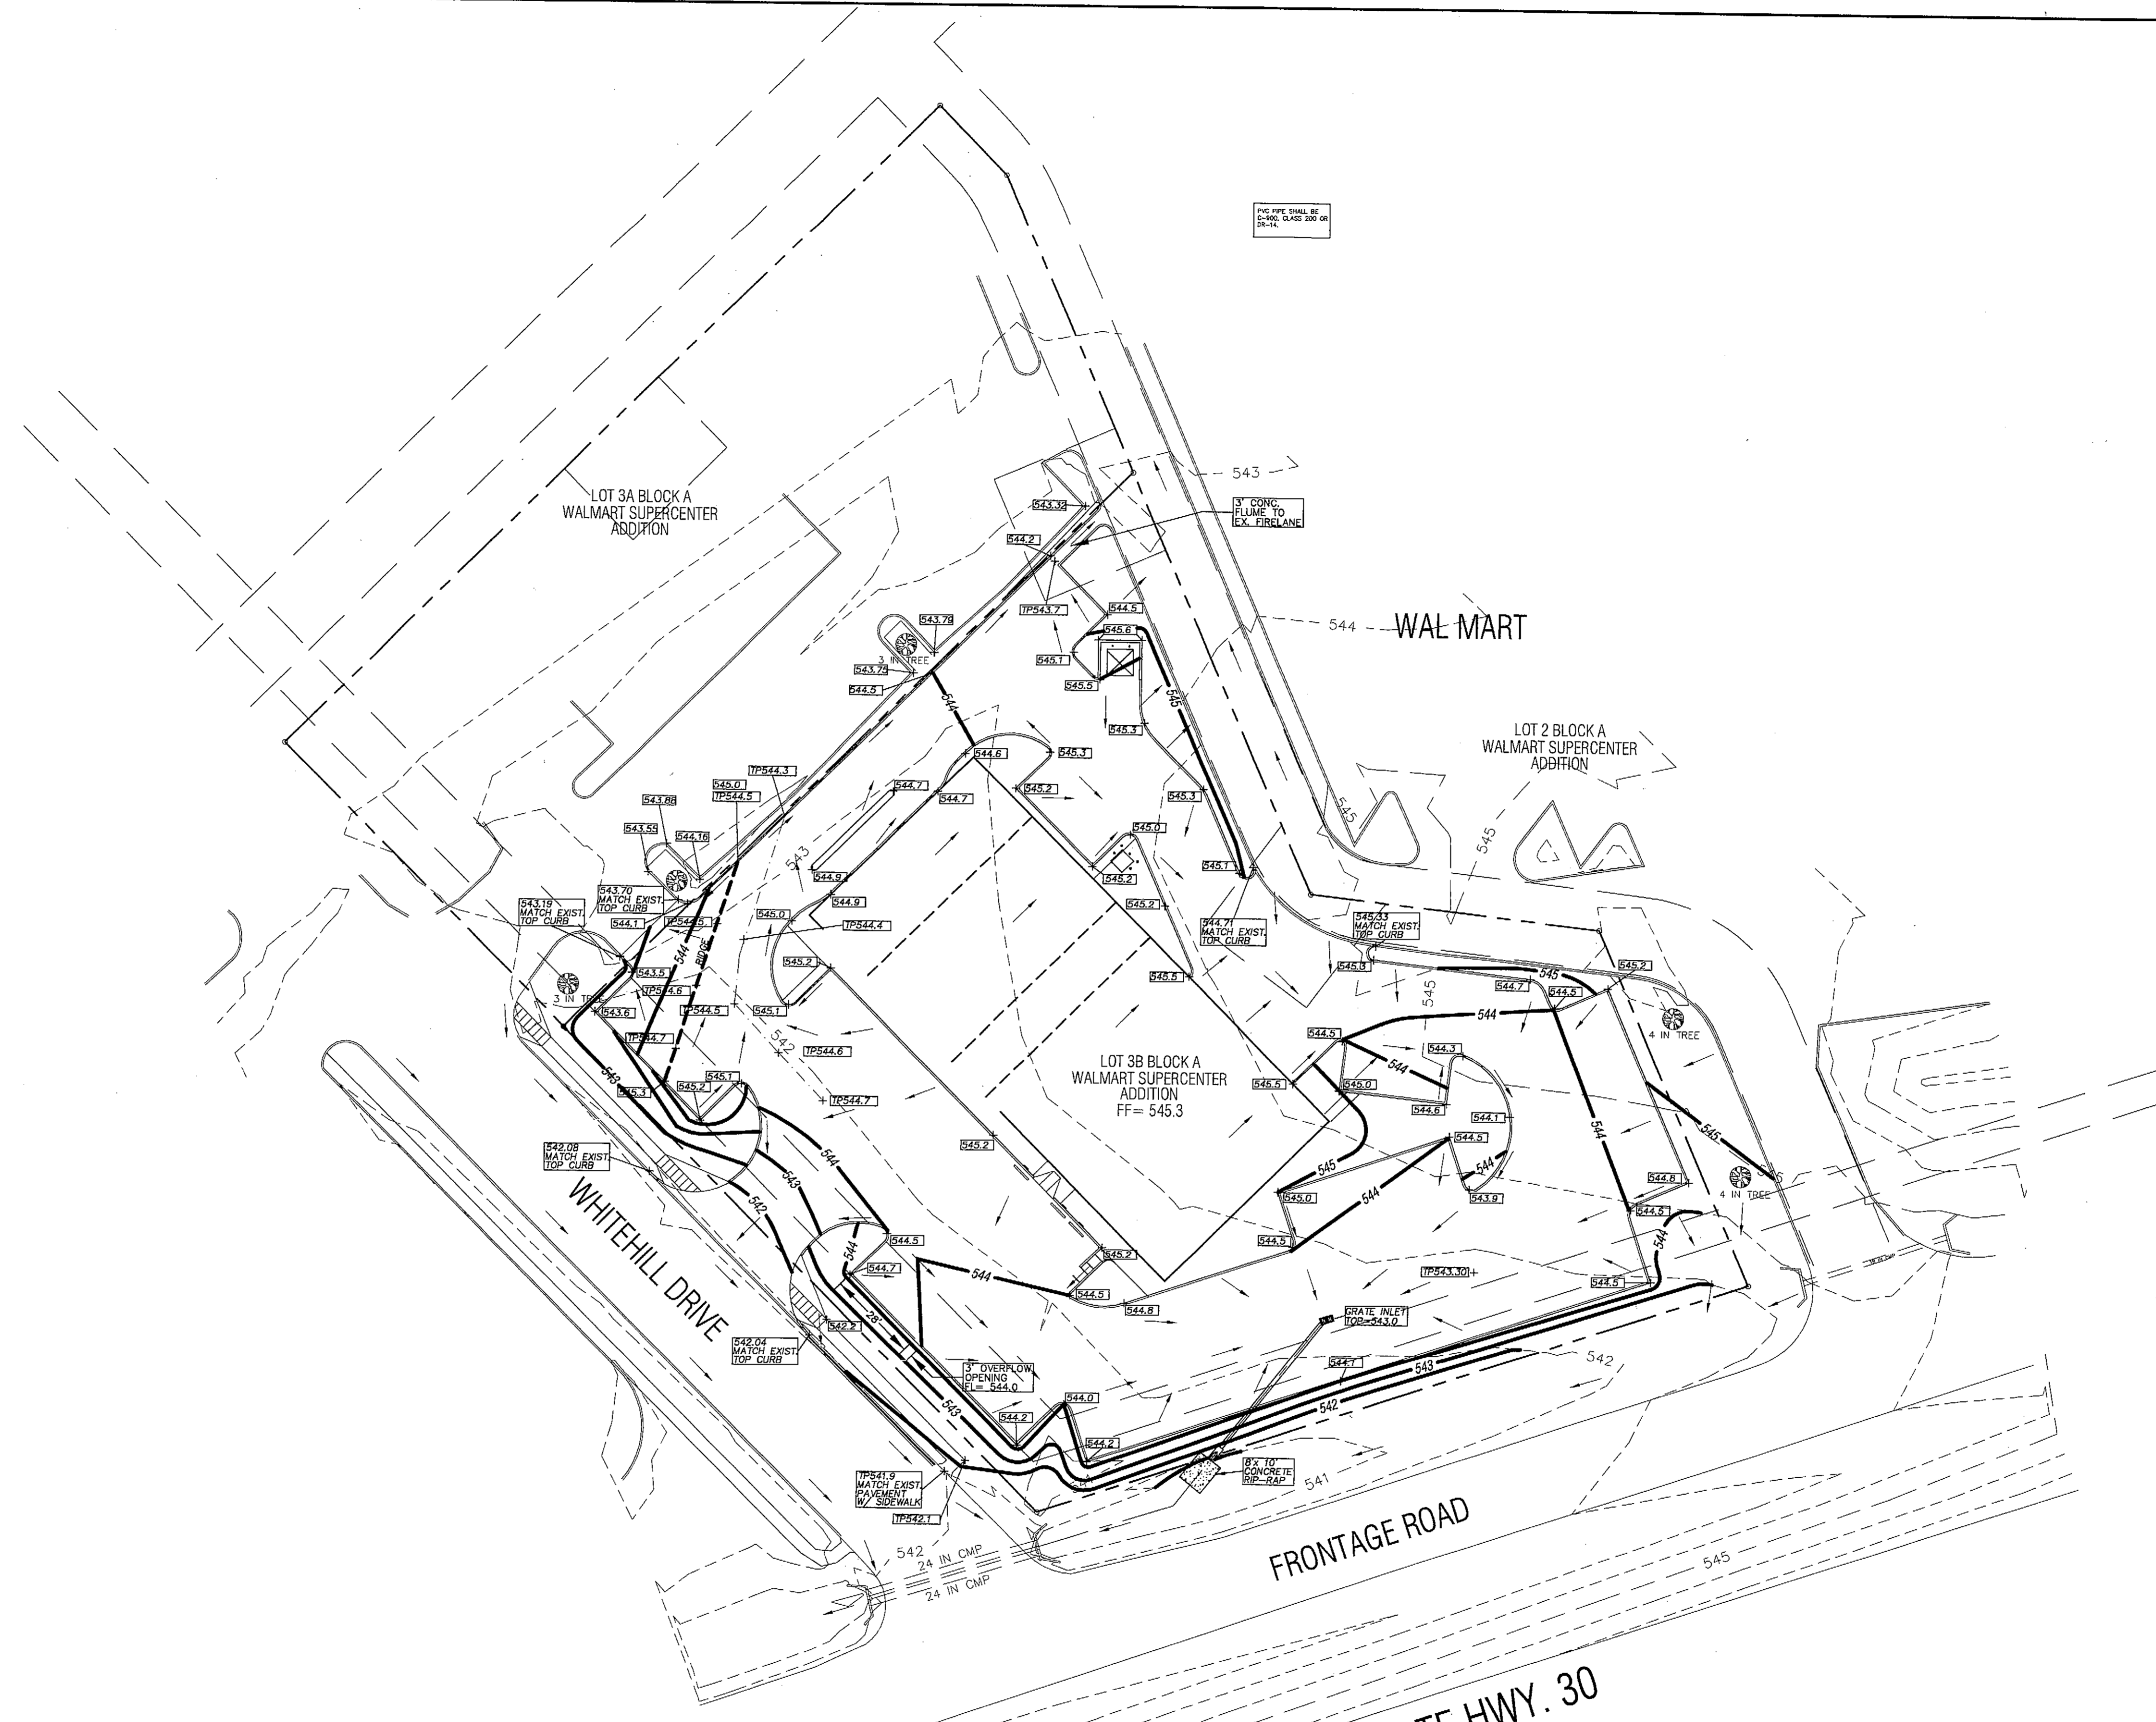

BENCHMARK:
 SQUARE CUT ON NORTH CORNER OF INLET ON EAST SIDE OF
 TACO BUENO.
 ELEVATION = 541.75

AS-BUILT

dietz engineering

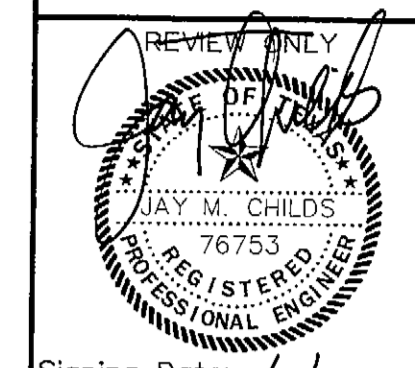

Signing Date: 5/24/2001

dietz engineering
 811 e. plano parkway
 suite 109
 plano, texas 75074
 voice: 972 633-8867
 fax: 972 633-1327

Drawn By: LL
 Checked By: JMC
 Revisions:

SITE RETAIL
 GRADING PLAN
 PLAN VIEW
 for the
 City of Rockwall, Texas



NORTH
 24"x36" Scale: 1" = 30'
 11"x17" Scale: 1" = 60'
 Vertical Scale: NA
 Project Number: E-SPC-001
 Issue Date: 24 MAY 2001
 Sheet Title:
GRADING PLAN
 Sheet No.:

C1.02