
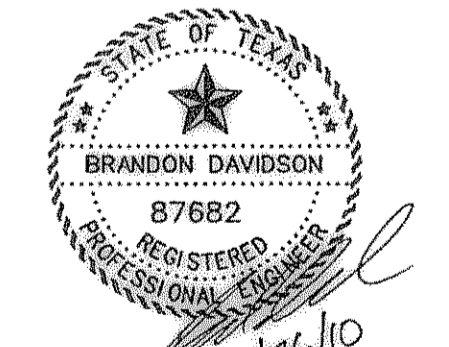


CURVE NO.	CURVE DATA		
	①	②	③
Δ	40° 16' 12"	0' 1"	0' 1"
R	65.00'	'	'
T	23.83'	'	'
L	45.69'	'	'

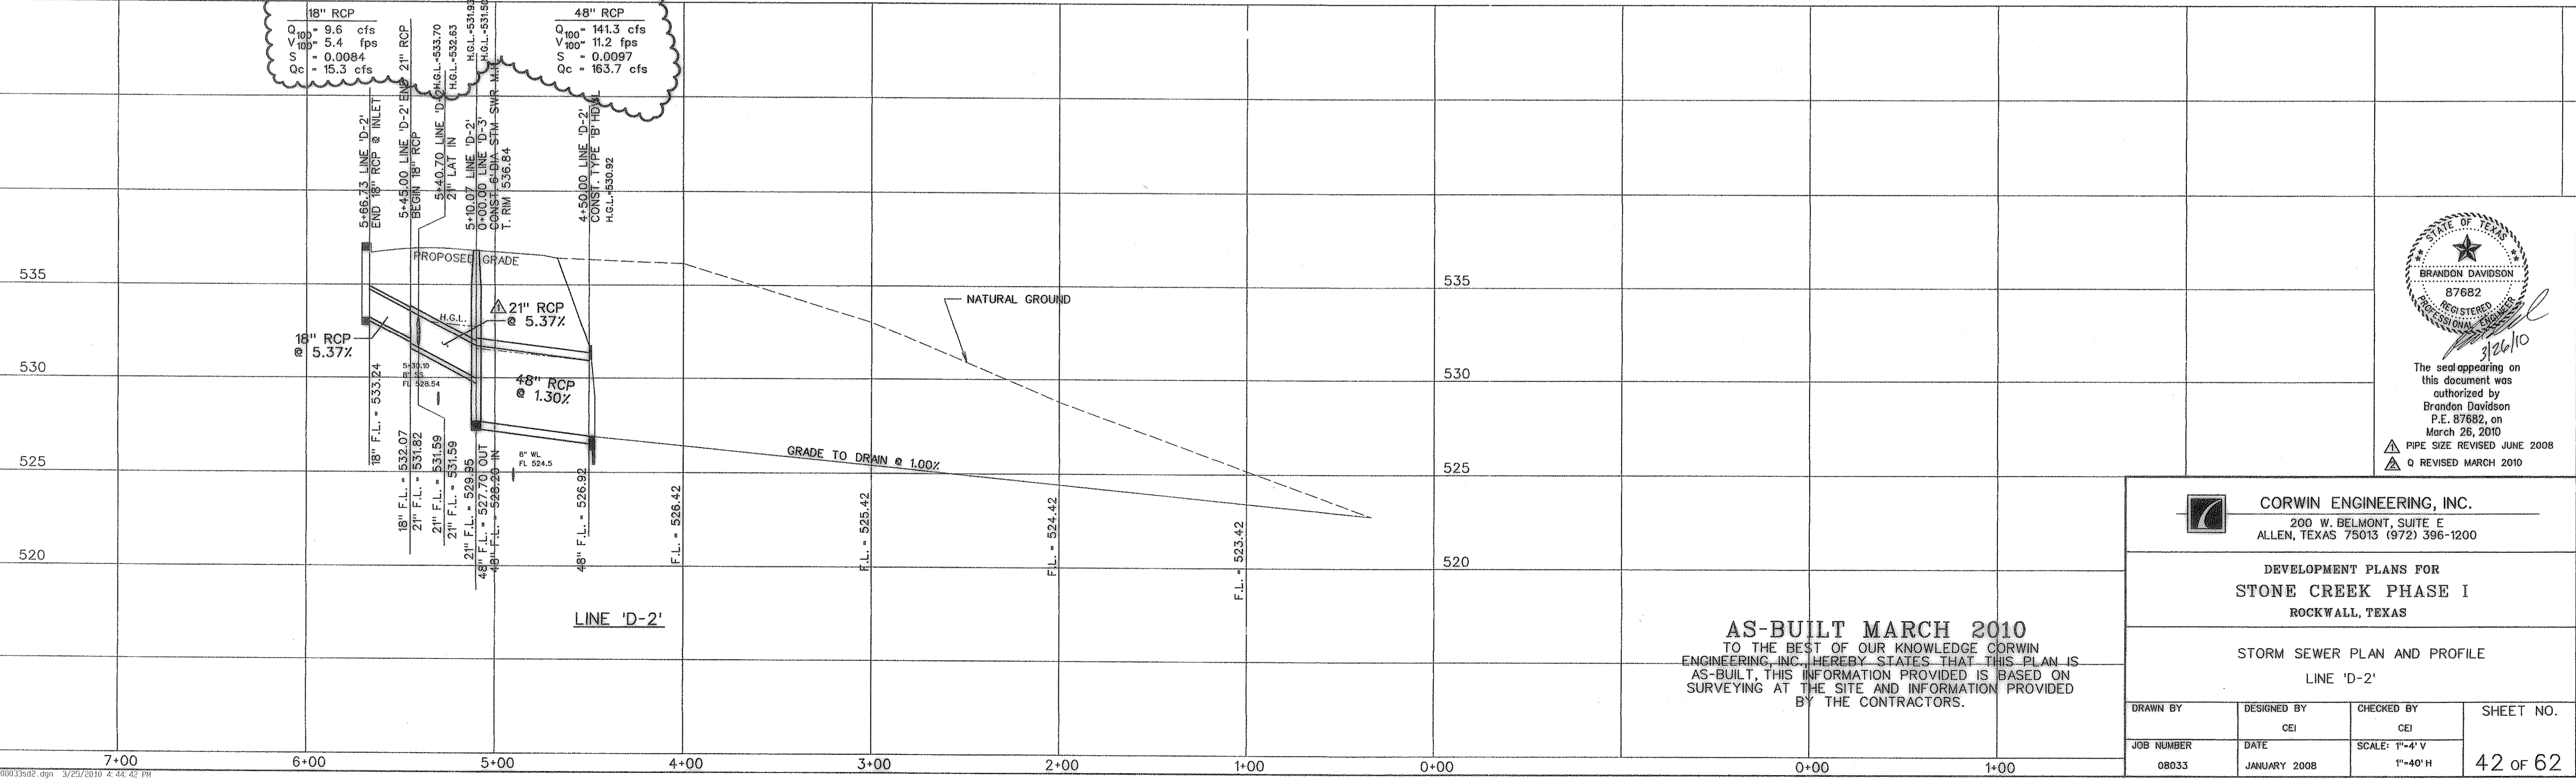

The seal appearing on this document was authorized by Brandon Davidson P.E. 87682, on March 26, 2010
 PIPE SIZE REVISED JUNE 2008
 Q REVISED MARCH 2010

CORWIN ENGINEERING, INC.
 200 W. BELMONT, SUITE E
 ALLEN, TEXAS 75013 (972) 396-1200

DEVELOPMENT PLANS FOR
STONE CREEK PHASE I
 ROCKWALL, TEXAS

STORM SEWER PLAN AND PROFILE
 LINE 'D-2'

AS-BUILT MARCH 2010
 TO THE BEST OF OUR KNOWLEDGE CORWIN ENGINEERING, INC. HEREBY STATES THAT THIS PLAN IS AS-BUILT, THIS INFORMATION PROVIDED IS BASED ON SURVEYING AT THE SITE AND INFORMATION PROVIDED BY THE CONTRACTORS.

DRAWN BY	DESIGNED BY CEI	CHECKED BY CEI	SHEET NO. 42 of 62
JOB NUMBER 08033	DATE JANUARY 2008	SCALE: 1"=4' V 1"=40' H	