

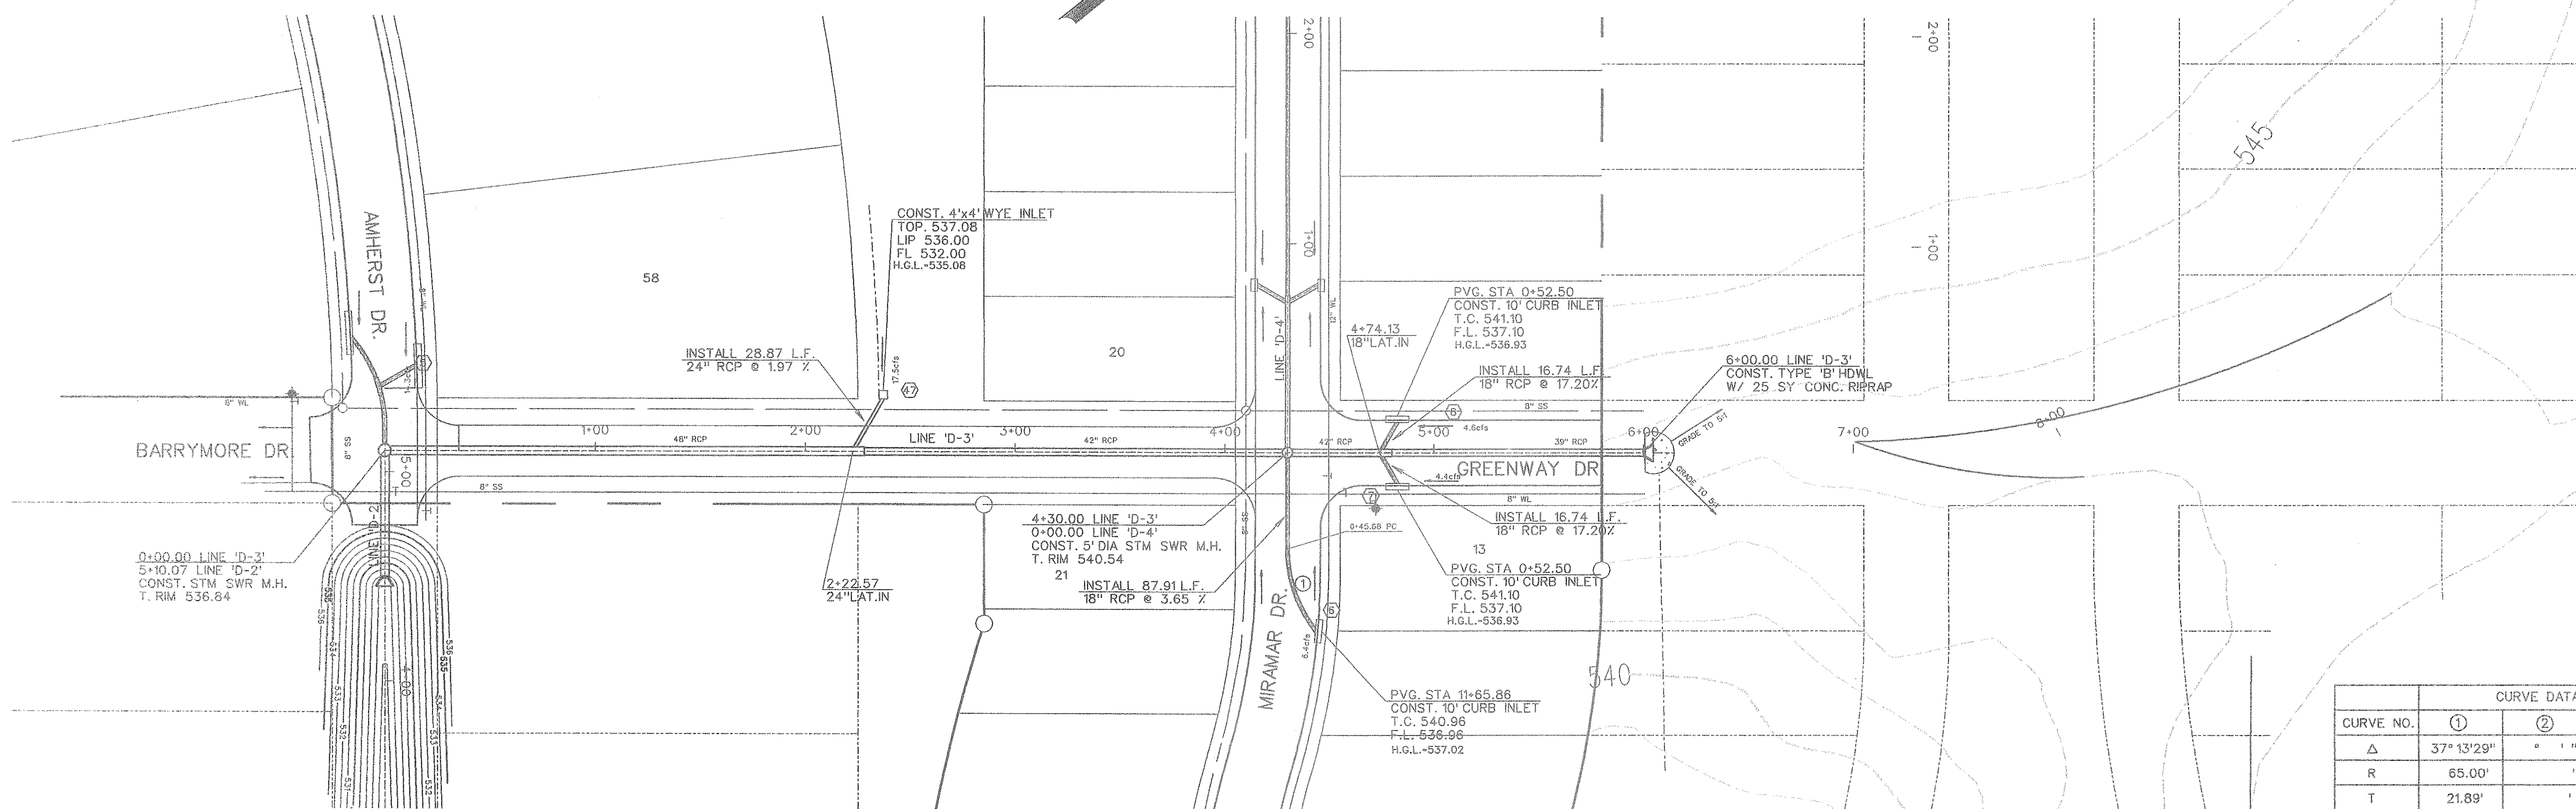


0 20 40 80  
SCALE: 1" = 40'

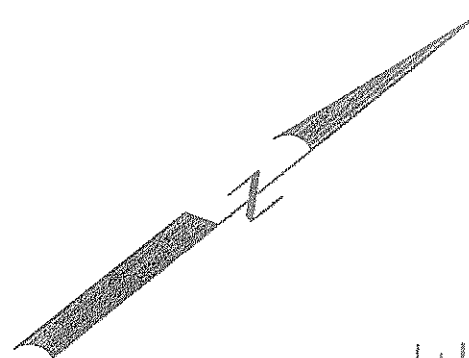

CURVE DATA			
CURVE NO.	①	②	③
Δ	37° 13' 29"	" "	" "
R	65.00'	'	'
T	21.89'	'	'
L	42.23'	'	'

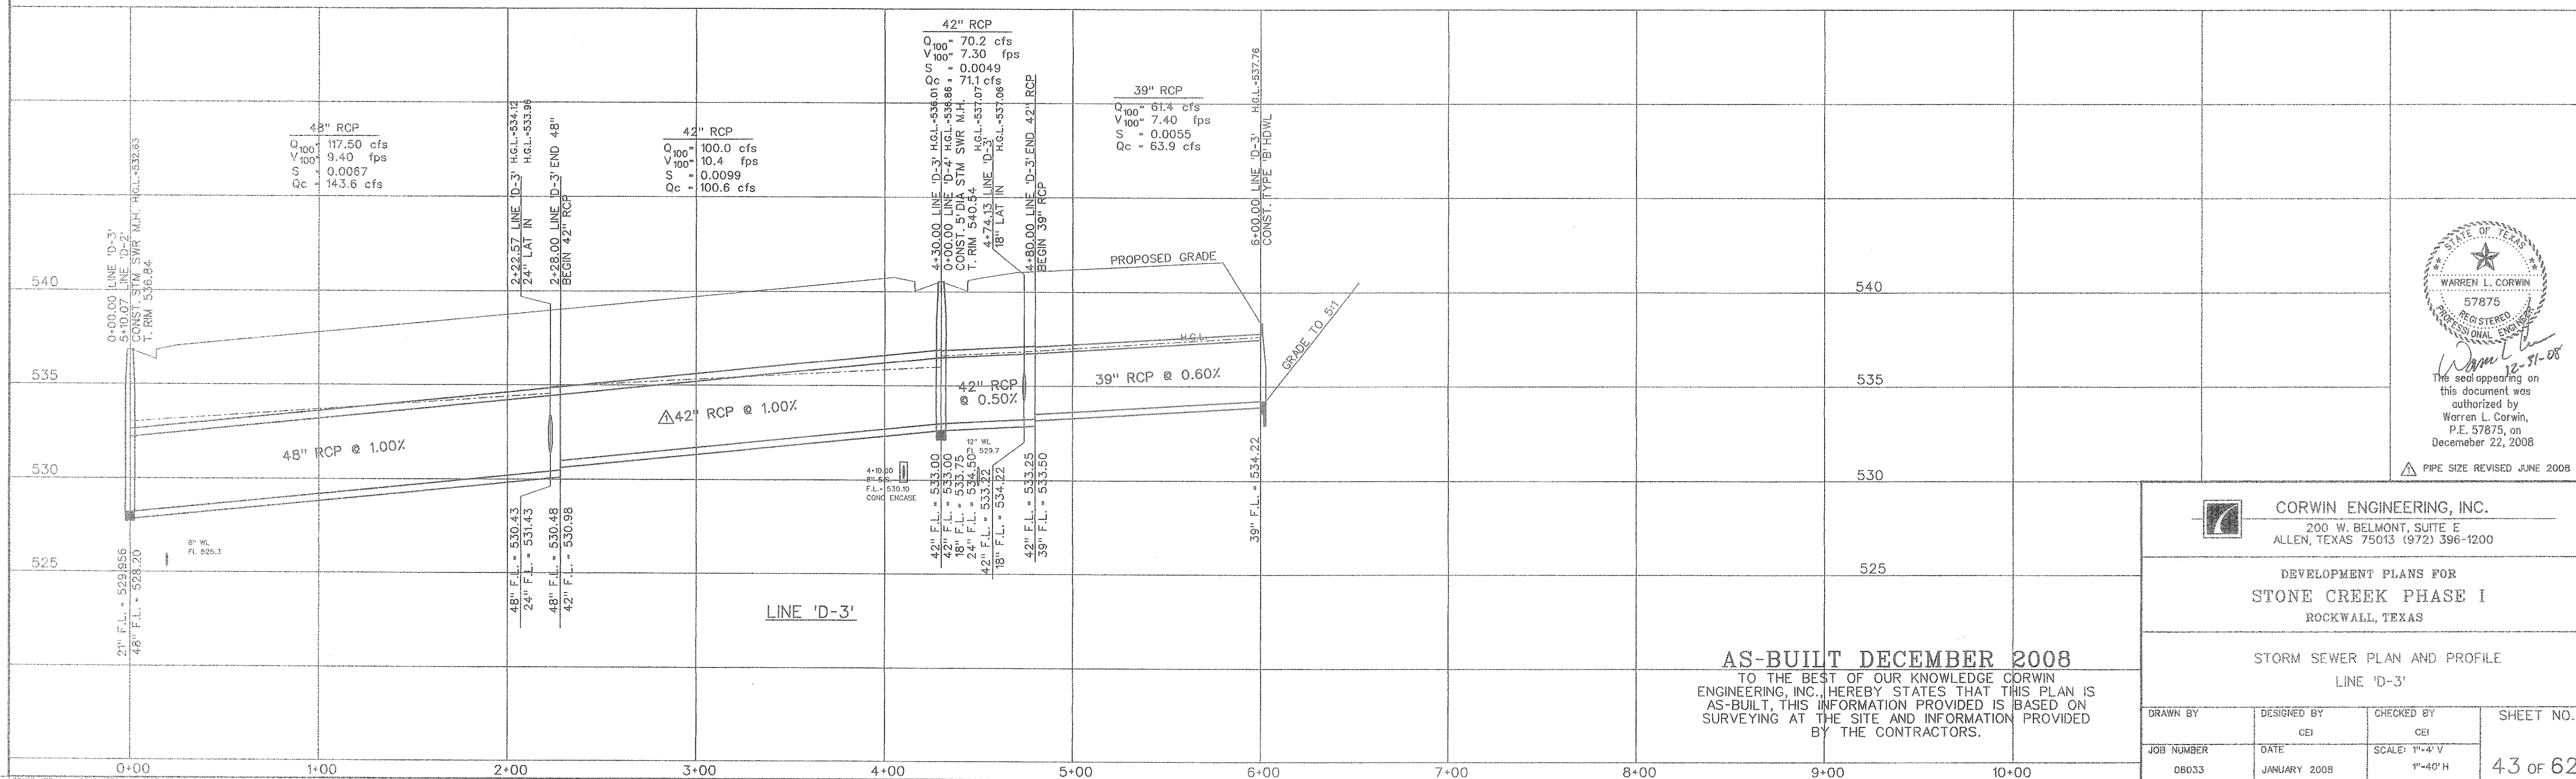

STATE OF TEXAS  
WARREN L. CORWIN  
57875  
REGISTERED PROFESSIONAL ENGINEER  
12-21-08  
The seal appearing on this document was authorized by Warren L. Corwin, P.E. 57875, on December 22, 2008

PIPE SIZE REVISED JUNE 2008

**CORWIN ENGINEERING, INC.**  
200 W. BELMONT, SUITE E  
ALLEN, TEXAS 75013 (972) 396-1200

DEVELOPMENT PLANS FOR  
**STONE CREEK PHASE I**  
ROCKWALL, TEXAS

STORM SEWER PLAN AND PROFILE  
LINE 'D-3'

**AS-BUILT DECEMBER 2008**  
TO THE BEST OF OUR KNOWLEDGE CORWIN ENGINEERING, INC. HEREBY STATES THAT THIS PLAN IS AS-BUILT, THIS INFORMATION PROVIDED IS BASED ON SURVEYING AT THE SITE AND INFORMATION PROVIDED BY THE CONTRACTORS.

DRAWN BY	DESIGNED BY	CHECKED BY	SHEET NO.
	CEI	CEI	
JOB NUMBER	DATE	SCALE: 1"=4'-V	
08033	JANUARY 2008	1"=40' H	43 OF 62