
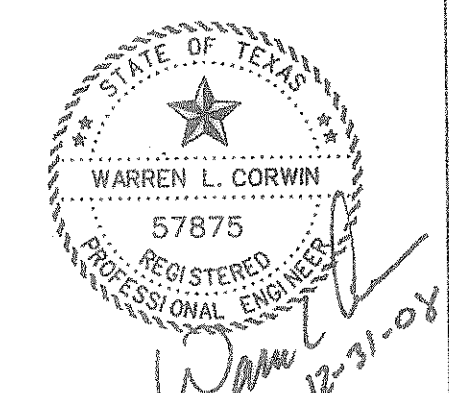
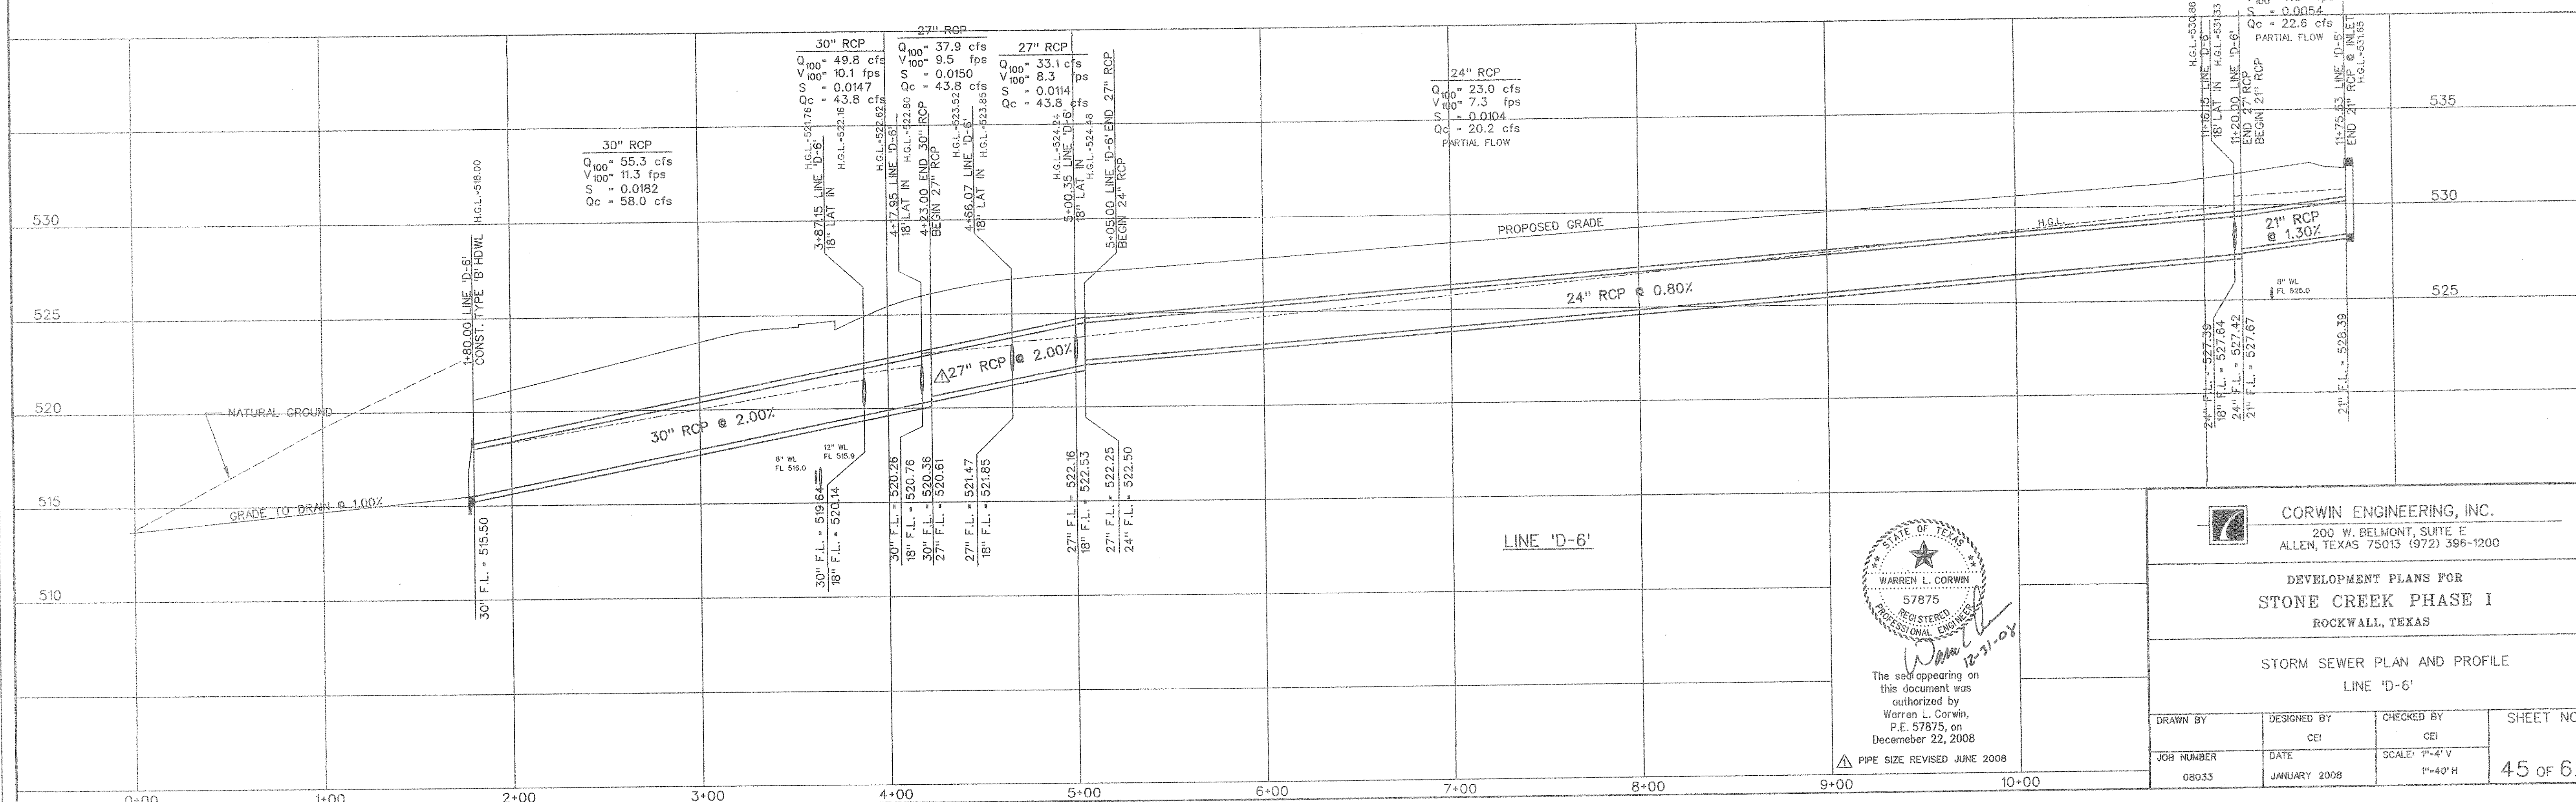


0 20 40 80
SCALE: 1" = 40'

CURVE NO.	CURVE DATA			
	①	②	③	④
Δ	95° 25' 54"	14° 16' 06"	08° 40' 10"	41° 35' 06"
R	65.00'	720.00'	510.00'	65.00'
T	71.47'	90.12'	36.66'	24.68'
L	108.26'	179.30'	77.17'	47.18'

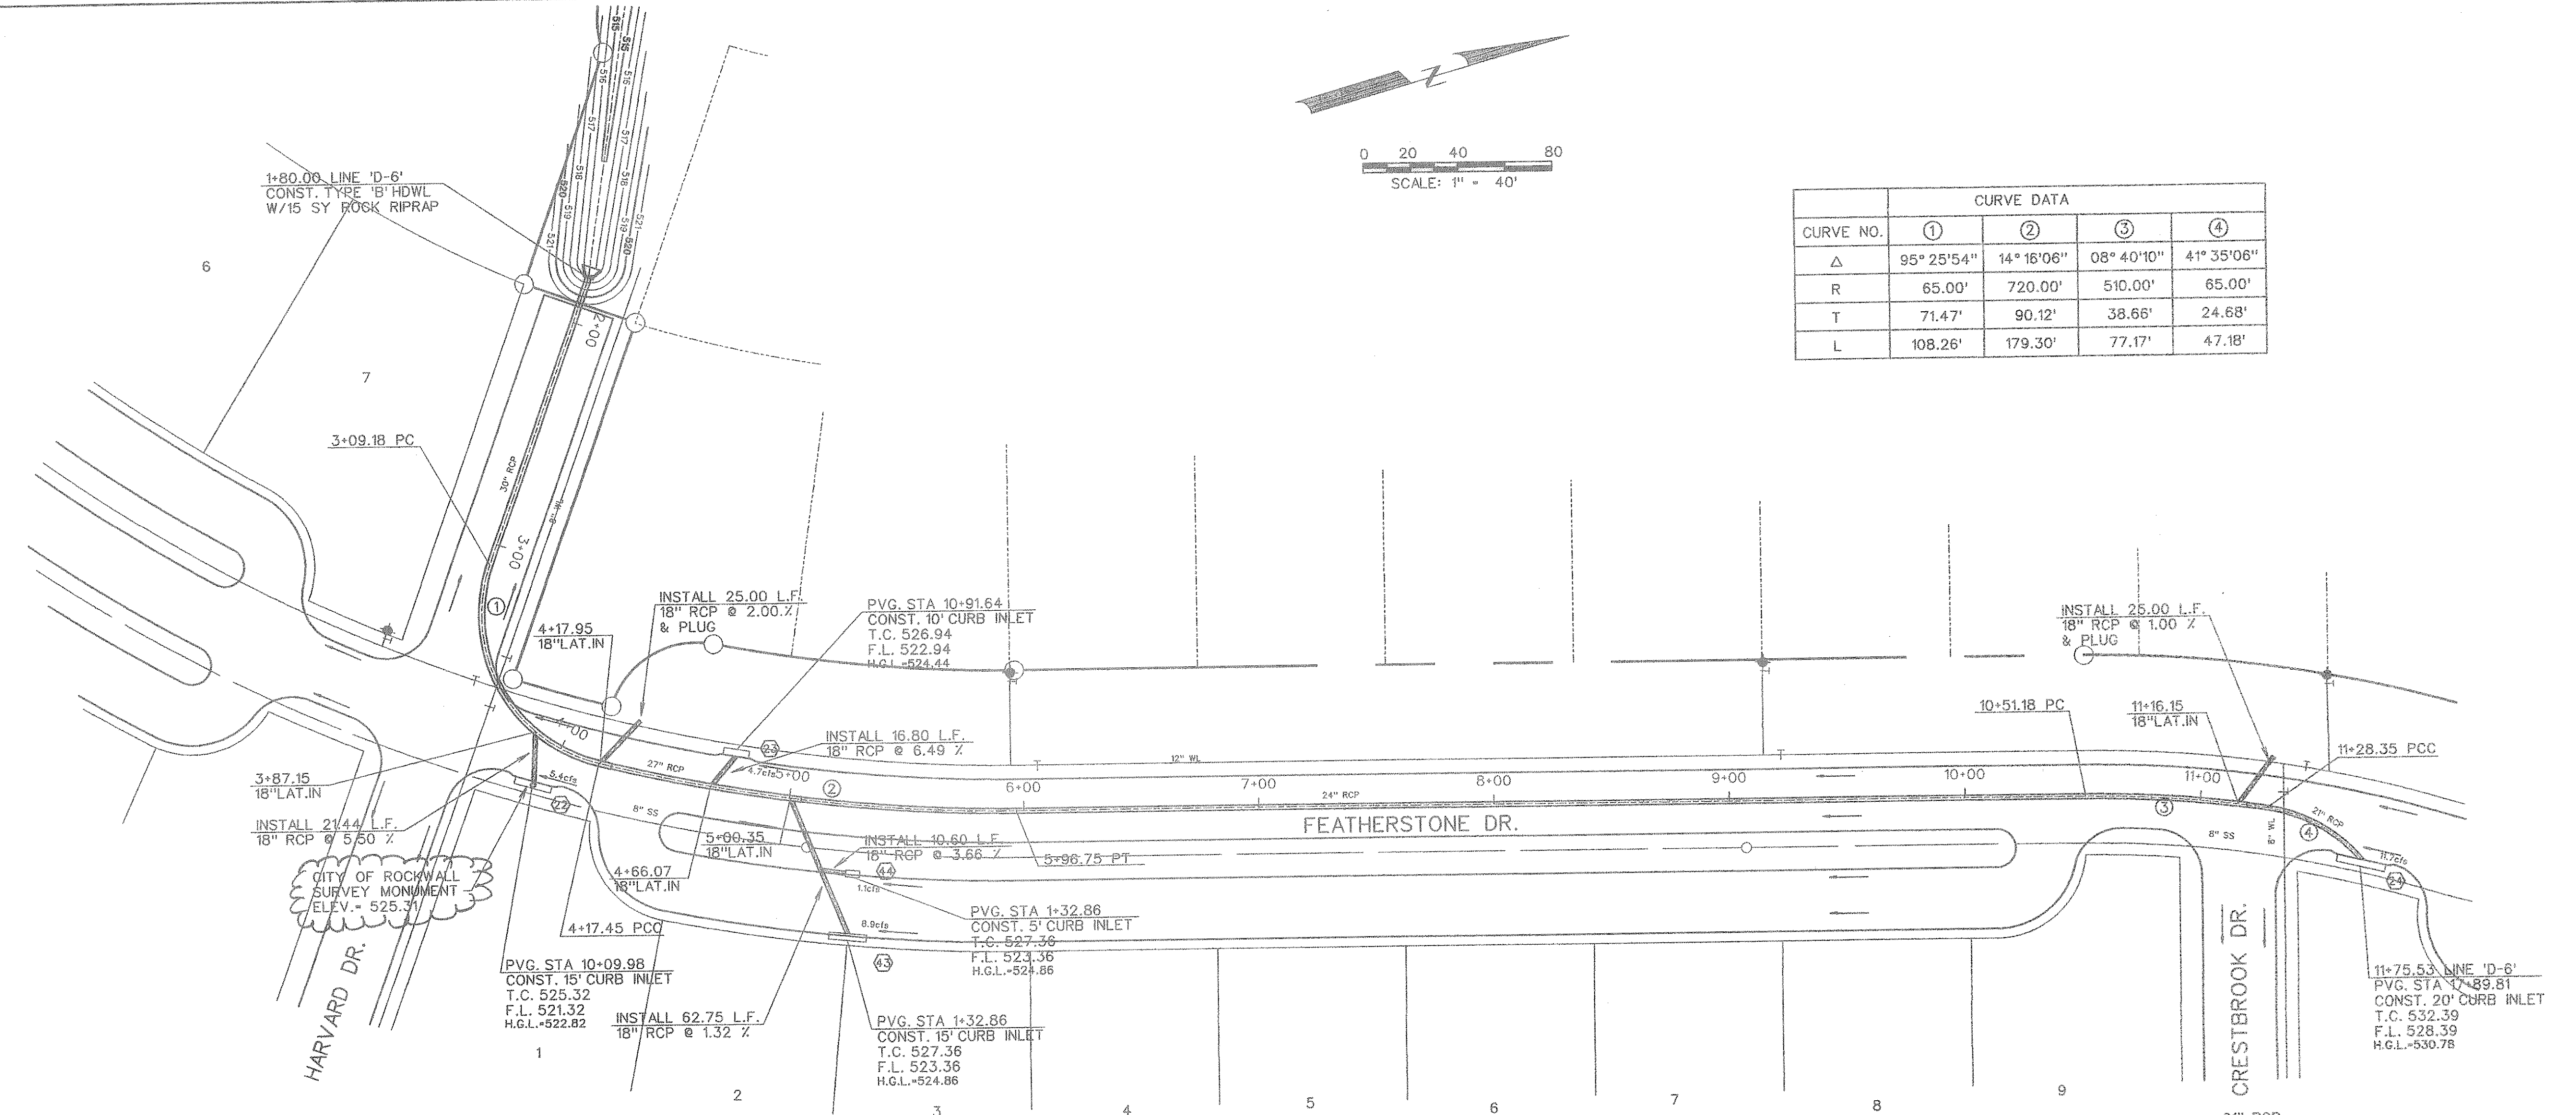

The seal appearing on this document was authorized by Warren L. Corwin, P.E. 57875, on December 22, 2008

CORWIN ENGINEERING, INC.
200 W. BELMONT, SUITE E
ALLEN, TEXAS 75013 (972) 396-1200

DEVELOPMENT PLANS FOR
STONE CREEK PHASE I
ROCKWALL, TEXAS

STORM SEWER PLAN AND PROFILE
LINE 'D-6'

DRAWN BY	DESIGNED BY	CHECKED BY	SHEET NO.
	CEI	CEI	
JOB NUMBER	DATE	SCALE:	
08033	JANUARY 2008	1"=4' V 1"=40' H	45 of 62