
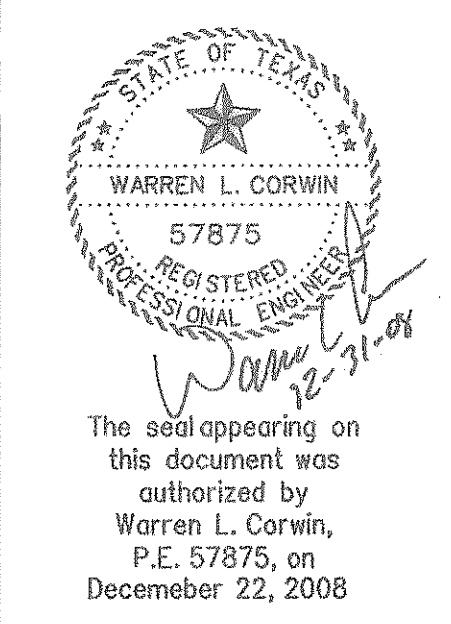


CURVE DATA			
CURVE NO.	①	②	③
Δ	45° 00' 00"	39° 01' 13"	° ' "
R	65.00'	65.00'	'
T	26.92'	23.03'	'
L	51.05'	44.27'	'

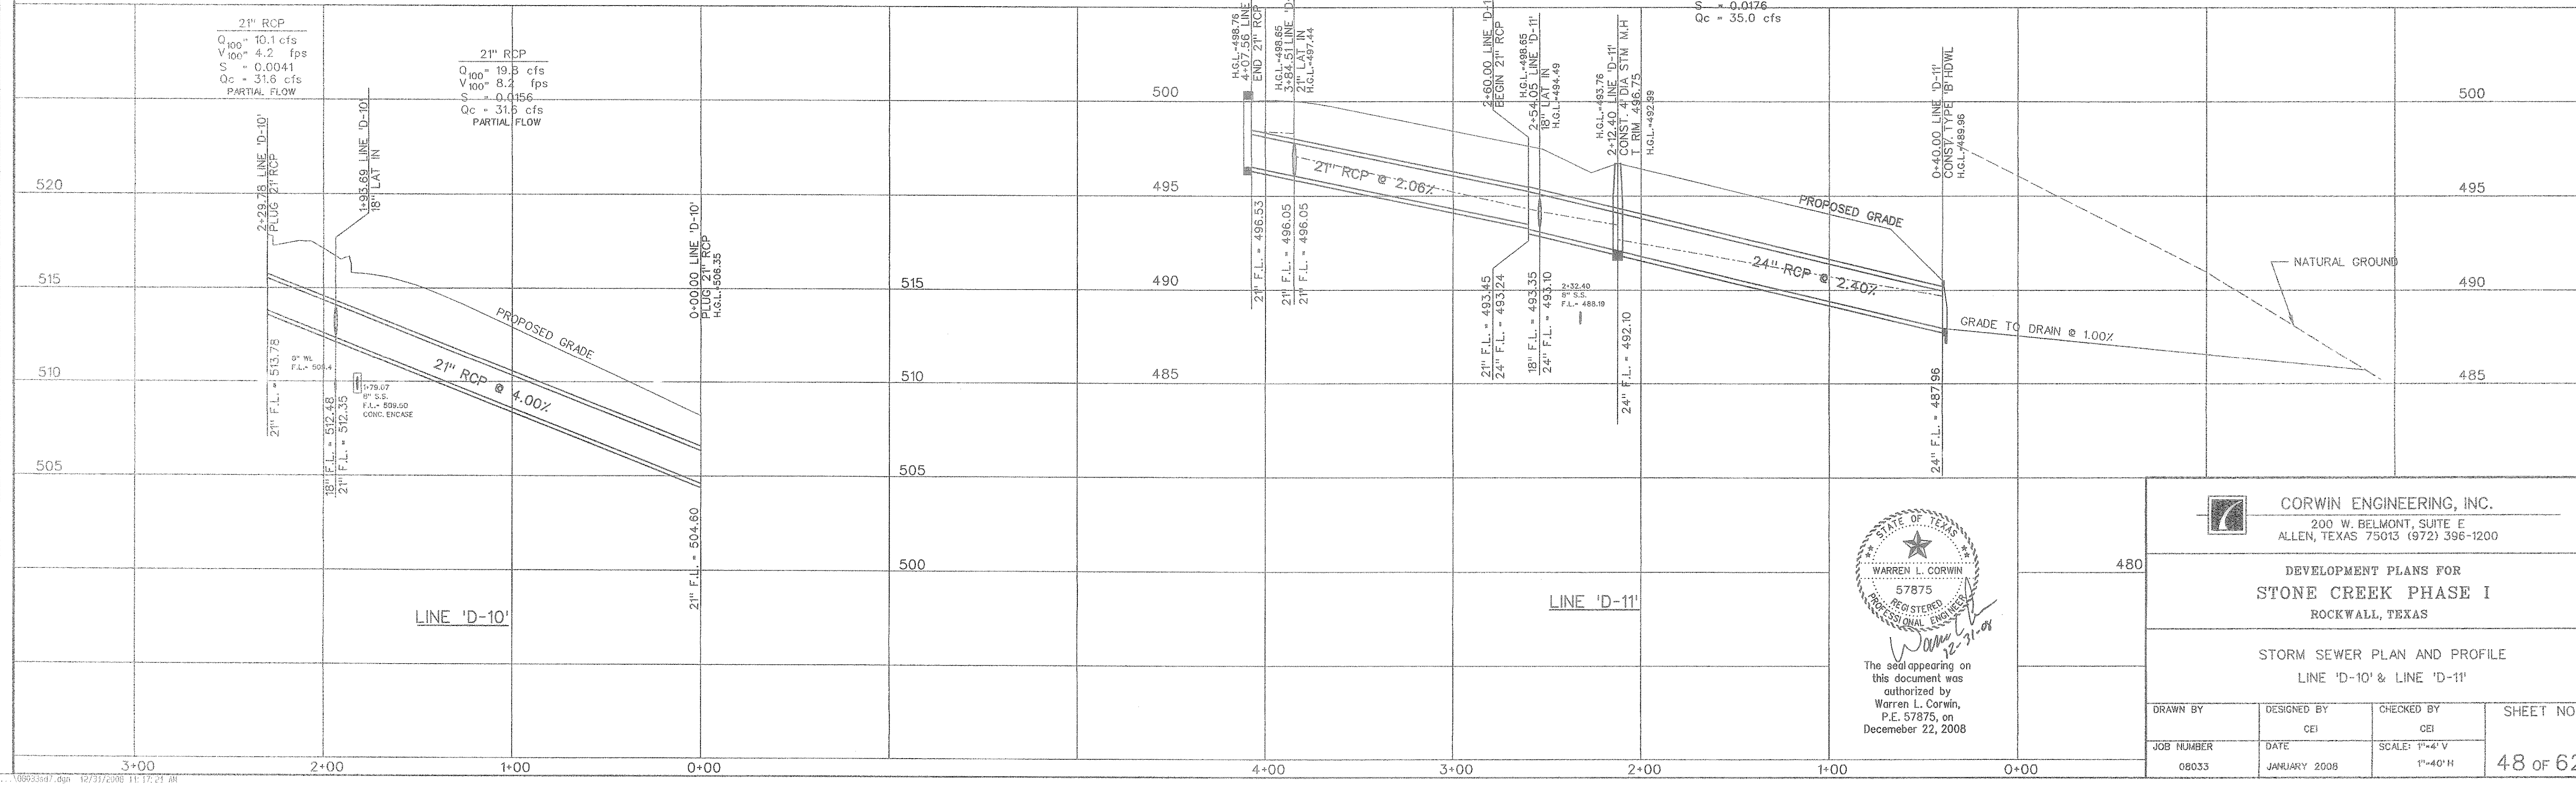

**CORWIN ENGINEERING, INC.**  
 200 W. BELMONT, SUITE E  
 ALLEN, TEXAS 75013 (972) 396-1200

DEVELOPMENT PLANS FOR  
**STONE CREEK PHASE I**  
 ROCKWALL, TEXAS

STORM SEWER PLAN AND PROFILE  
 LINE 'D-10' & LINE 'D-11'

DRAWN BY	DESIGNED BY	CHECKED BY	SHEET NO.
	CEI	CEI	48 OF 62
JOB NUMBER	DATE	SCALE: 1"=4' V	
08033	JANUARY 2008	1"=40' H	