



NOTE:  
CONTRACTOR SHALL VERIFY ALL EXISTING UTILITIES PRIOR TO CONSTRUCTION. EXISTING UTILITY LOCATION AND ELEVATION ARE BASED ON AS-BUILT DRAWINGS AND MAY DIFFER IN ACTUAL LOCATION AND ELEVATION.

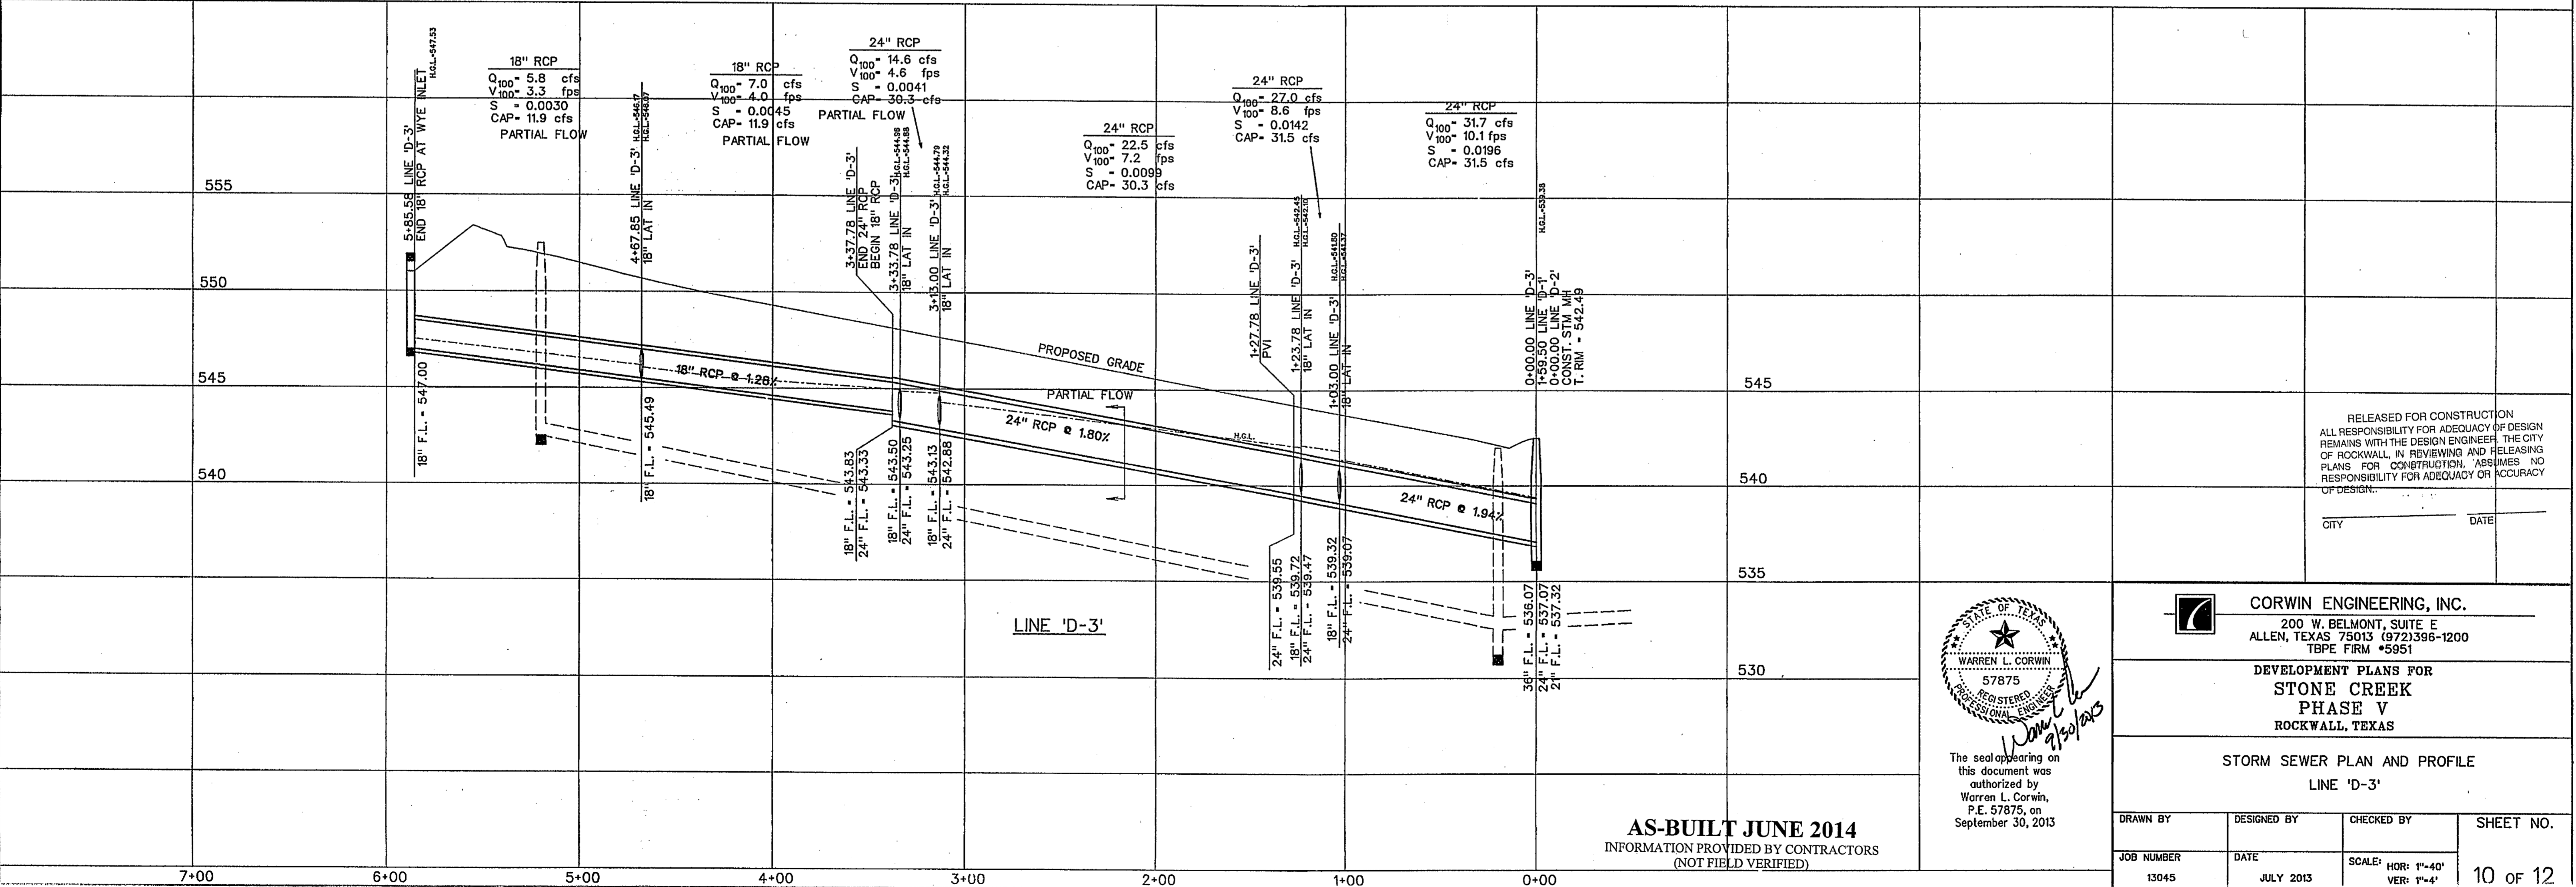

CITY \_\_\_\_\_ DATE \_\_\_\_\_

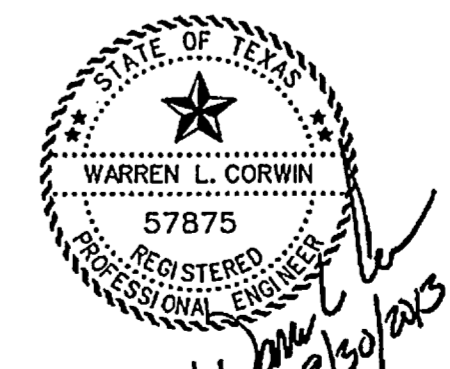

The seal appearing on this document was authorized by Warren L. Corwin, P.E. 57875, on September 30, 2013

**CORWIN ENGINEERING, INC.**  
200 W. BELMONT, SUITE E  
ALLEN, TEXAS 75013 (972)396-1200  
TBPE FIRM #5951

DEVELOPMENT PLANS FOR  
**STONE CREEK**  
PHASE V  
ROCKWALL, TEXAS

STORM SEWER PLAN AND PROFILE

LINE 'D-3'

**AS-BUILT JUNE 2014**  
INFORMATION PROVIDED BY CONTRACTORS  
(NOT FIELD VERIFIED)

DRAWN BY	DESIGNED BY	CHECKED BY	SHEET NO.
JOB NUMBER	DATE	SCALE: HOR: 1"=40' VER: 1"=4'	10 of 12
13045	JULY 2013		