



STORM SEWER CURVE DATA

CURVE NO.	①	②
Δ	16° 10' 20"	41° 18' 12"
R	825.00'	65.00'
T	117.21'	24.50'
L	232.86'	46.86'

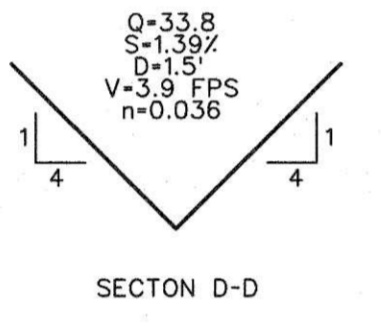

- LEGEND**
- ⓑ - BLOCK LABEL
 - Ⓜ - INLET NUMBER
 - ① - CURVE NUMBER
 - - SANITARY SEWER
 - ⊕ - WATER
 - ==== - PROPOSED STORM SEWER
 - - EXISTING STORM SEWER

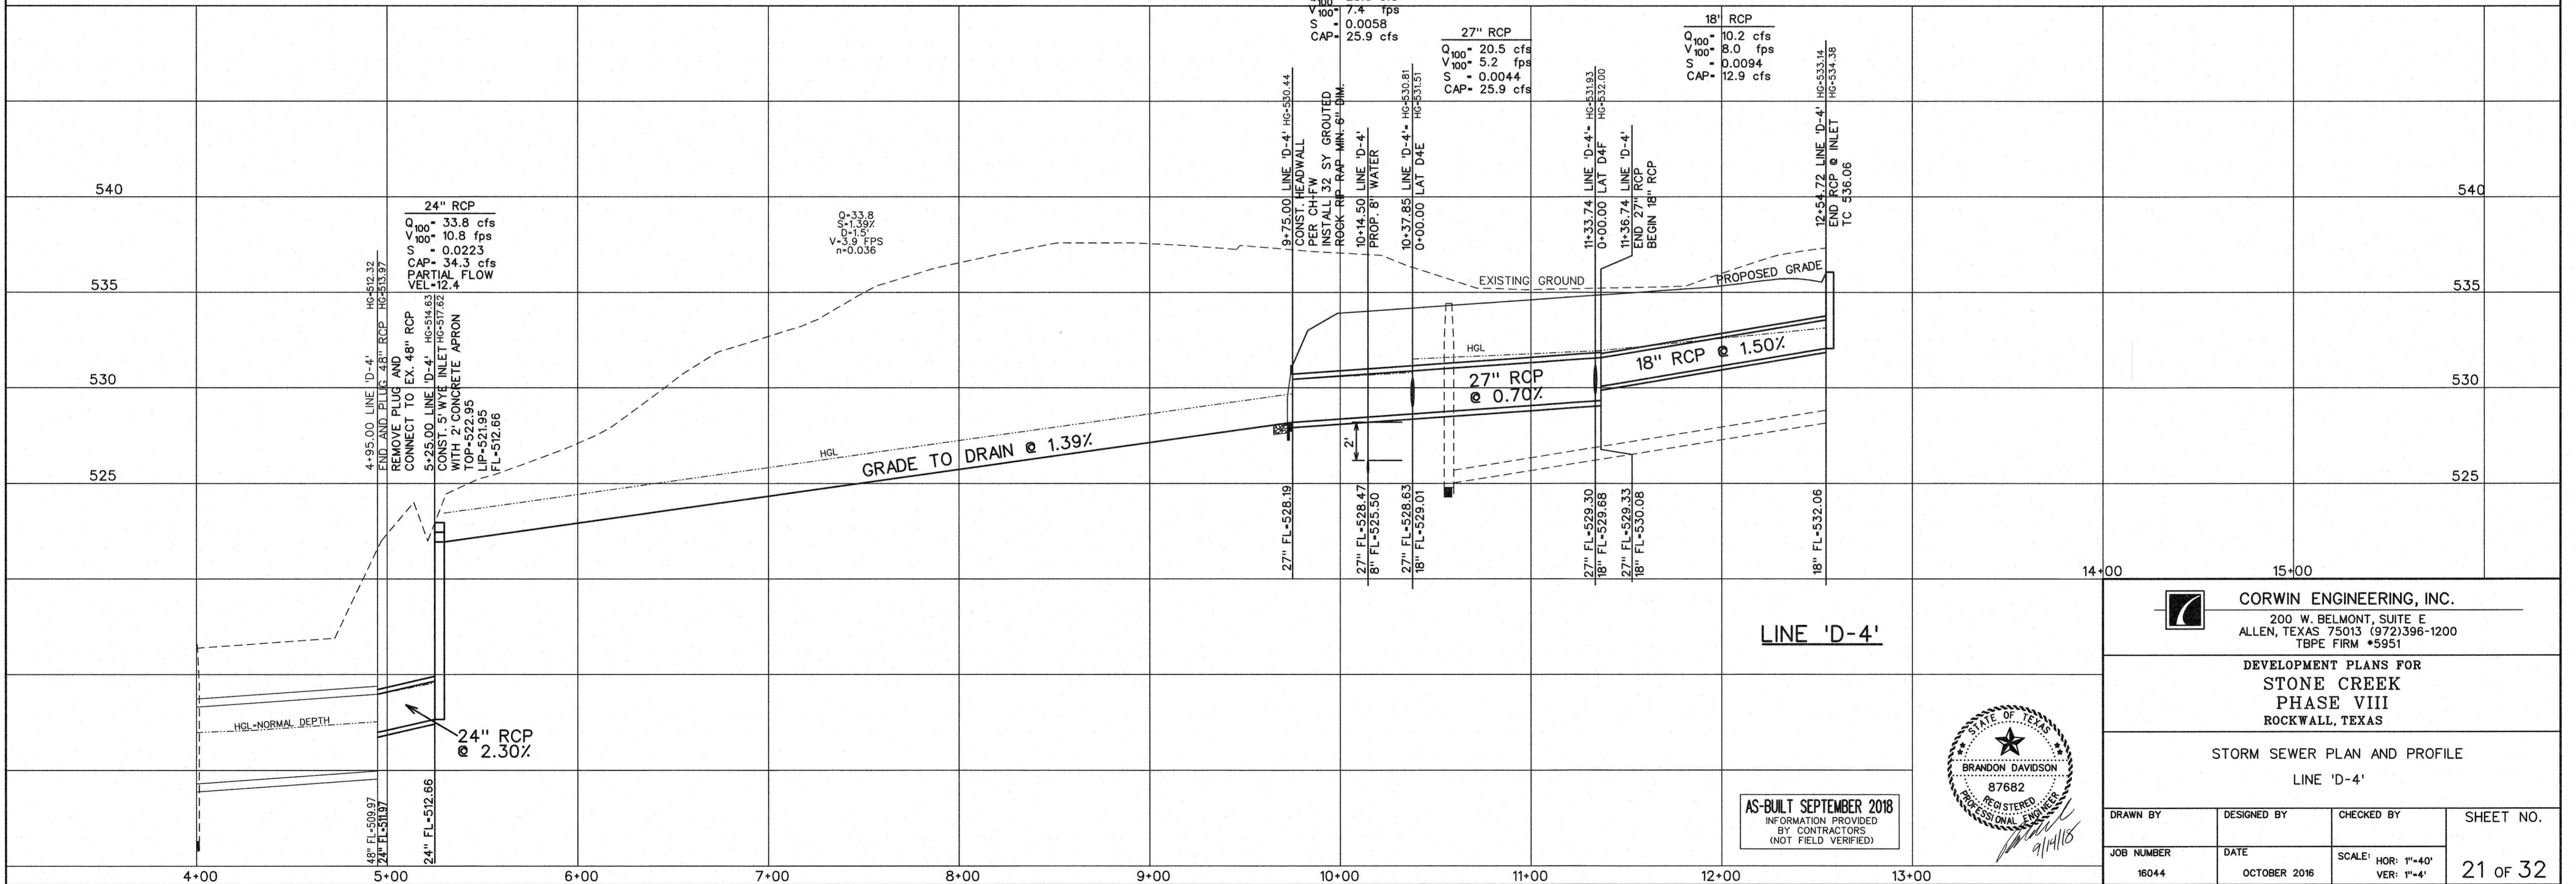

LINE 'D-4'

AS-BUILT SEPTEMBER 2018
INFORMATION PROVIDED
BY CONTRACTORS
(NOT FIELD VERIFIED)



CORWIN ENGINEERING, INC.
200 W. BELMONT, SUITE E
ALLEN, TEXAS 75013 (972)396-1200
TBPE FIRM #5951

DEVELOPMENT PLANS FOR
**STONE CREEK
PHASE VIII**
ROCKWALL, TEXAS

STORM SEWER PLAN AND PROFILE
LINE 'D-4'

DRAWN BY	DESIGNED BY	CHECKED BY	SHEET NO.
JOB NUMBER	DATE	SCALE: HOR: 1"=40' VER: 1"=4'	21 OF 32
16044	OCTOBER 2016		