



No.	Date	Revisions	App.
6-7-07		DESIGNER FROM WATER ALIGN. TO DATE. TO BE REMOVED FROM FIRE SERVICE LINE PER BUILDING 5' LESS THAN 5,000	MSA
4-17-07			MSA

Allen & Ridinger Consulting, Inc.
 285 W. Southwest Pkwy
 Lawtonville, Texas 75067
 Tel. No. (972) 353-9000
 Fax. No. (972) 353-9001

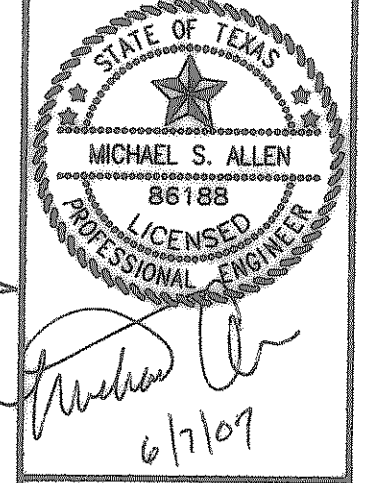


VISTA LAGO, TEXAS
 ROCKWALL, TEXAS

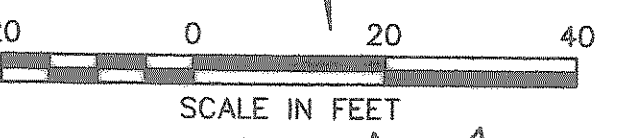

WARNING!
 CONTRACTOR TO VERIFY LOCATION AND ELEVATION OF EXISTING 12" WATER LINE PRIOR TO CONSTRUCTION.

RECORD DRAWING
 Mike Allen P. E.
 DATE: 04-08-08

NOTE:
 1.) ALL WATER LINES SHALL BE CLASS 200
 2.) BLUE EWS DISKS TO BE INSTALLED ON WATER LINE AT EVERY CHANGE IN DIRECTION, VALVE, SERVICE, AND STRAIGHT ALIGNMENTS AT EVERY 200'.
 3.) GREEN EWS DISKS TO BE INSTALLED ON SAN. SEW. LINE AT EVERY MANHOLE, CLEANOUT, CHANGE IN DIRECTION, AND EVERY 200' ON STRAIGHT ALIGNMENTS.
 4.) FIRE HYDRANTS TO HAVE 5' CLEARANCE.

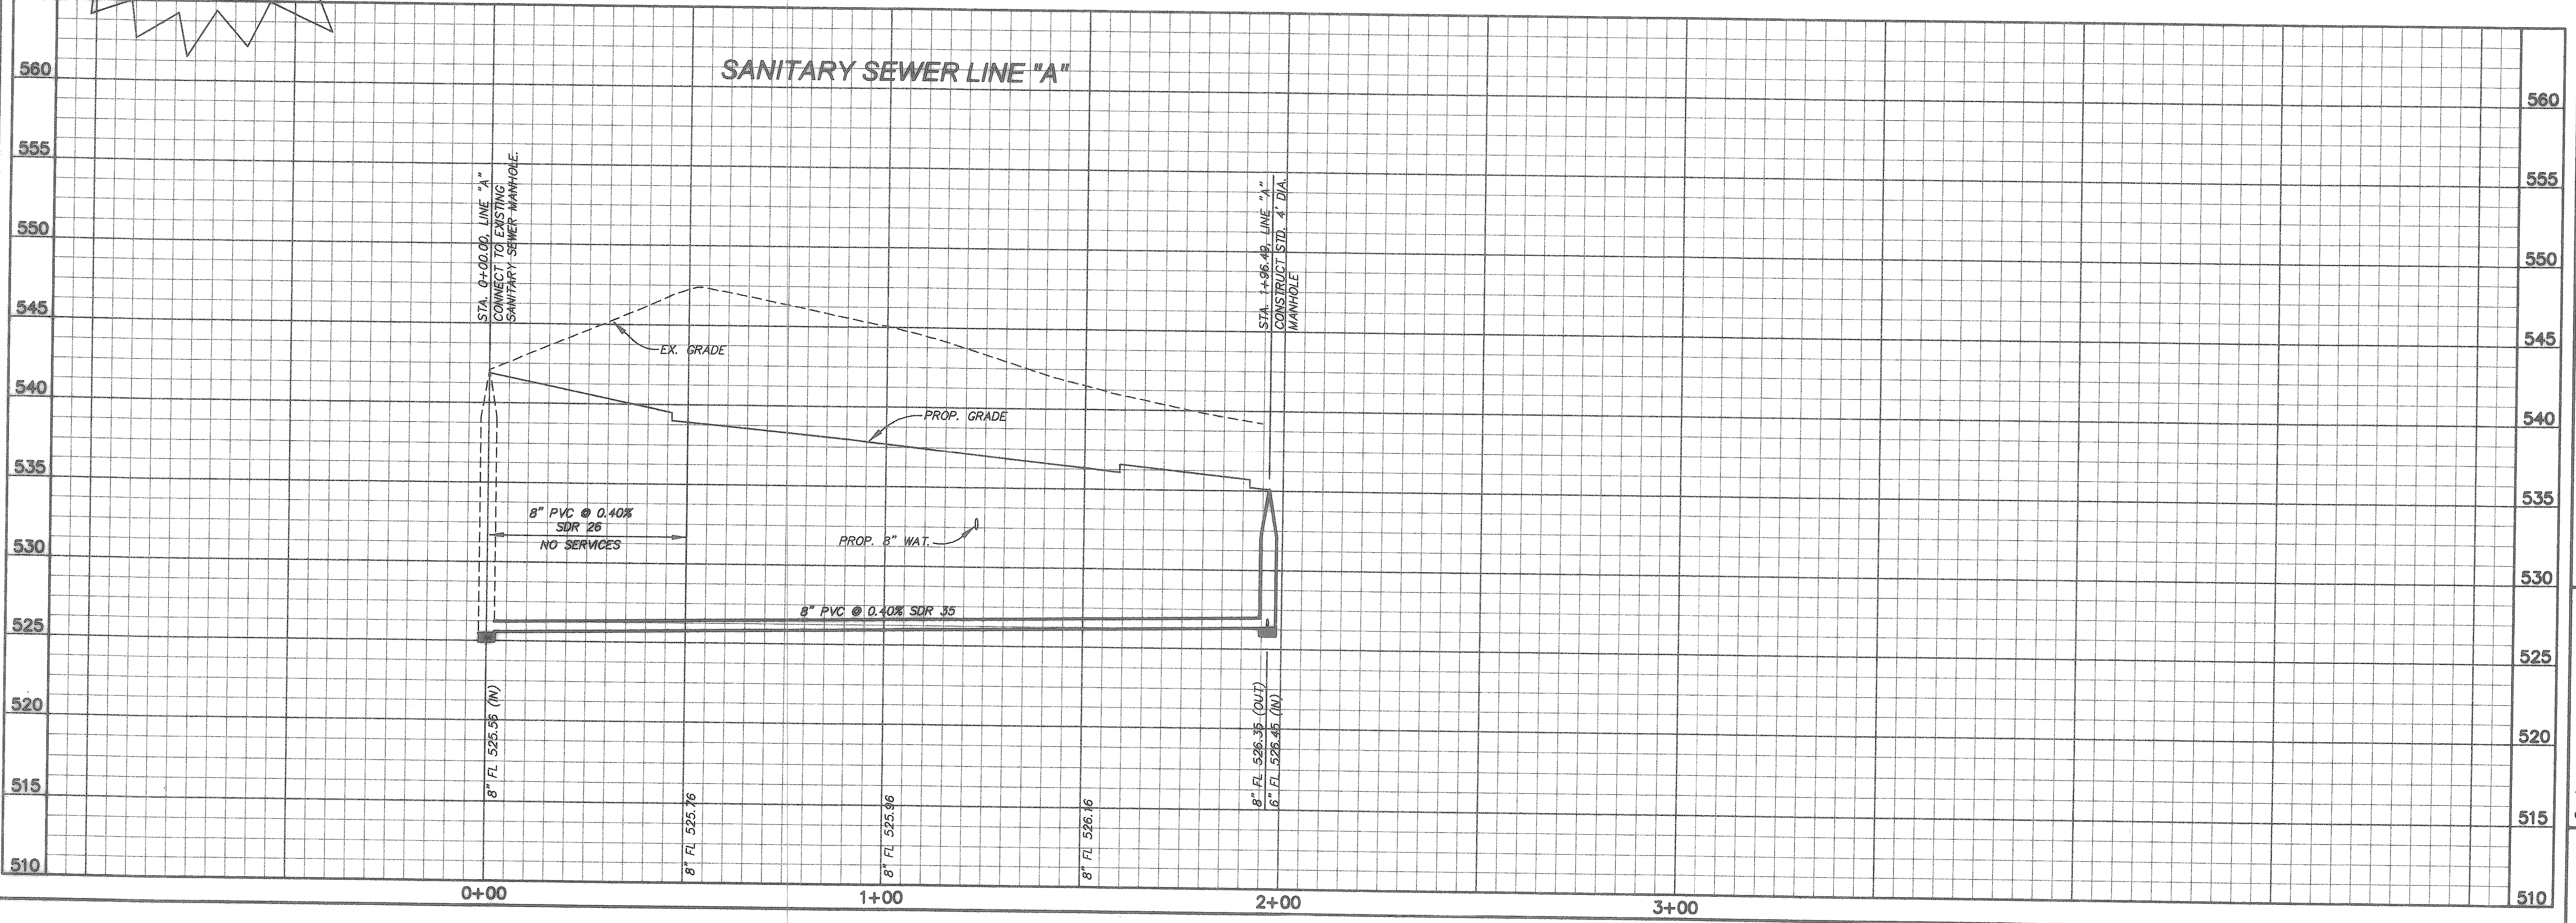

UTILITY PLAN AND PROFILE

Scale: 1"=20' HOR., 1"=5' VERT.
 Designed by: JDL
 Drawn by: JDL
 Checked by: MSA
 Date: APRIL 30, 2007
 Project No. 069-001

SHEET
C-4
 OF 10