



LEGEND	
	FIRE HYDRANT
	WATER METER
	MANHOLE
	TREE
	LIGHT POLE
+7P600.0	EX. TOP OF PVMT.
+7C600.0	EX. TOP OF CONC.
+7G600.0	EX. TOP OF GRND.
+ETC600.0	EX. TOP OF CURB
+600.0	FIN. FLR. SPOT ELEV.
+7P600.0	TOP OF PAVEMENT
+7C600.0	TOP OF CONCRETE
+7G600.0	TOP OF GROUND
+600.0	TOP OF CURB
	PROP. GRADE LINE
	EX. GRADE LINE
FF	FINISHED FLOOR
	GUY WIRE ANCHOR
	POWER POLE
	STREET/CABLE SIGN
	WATER VALVE
	UTILITY BOX
	WOOD BOLLARD
	GAS METER
	CURB INLET
	GRATE INLET
	UTILITY MANHOLE
	STORM MANHOLE
	SWB MANHOLE
	MAIL BOX

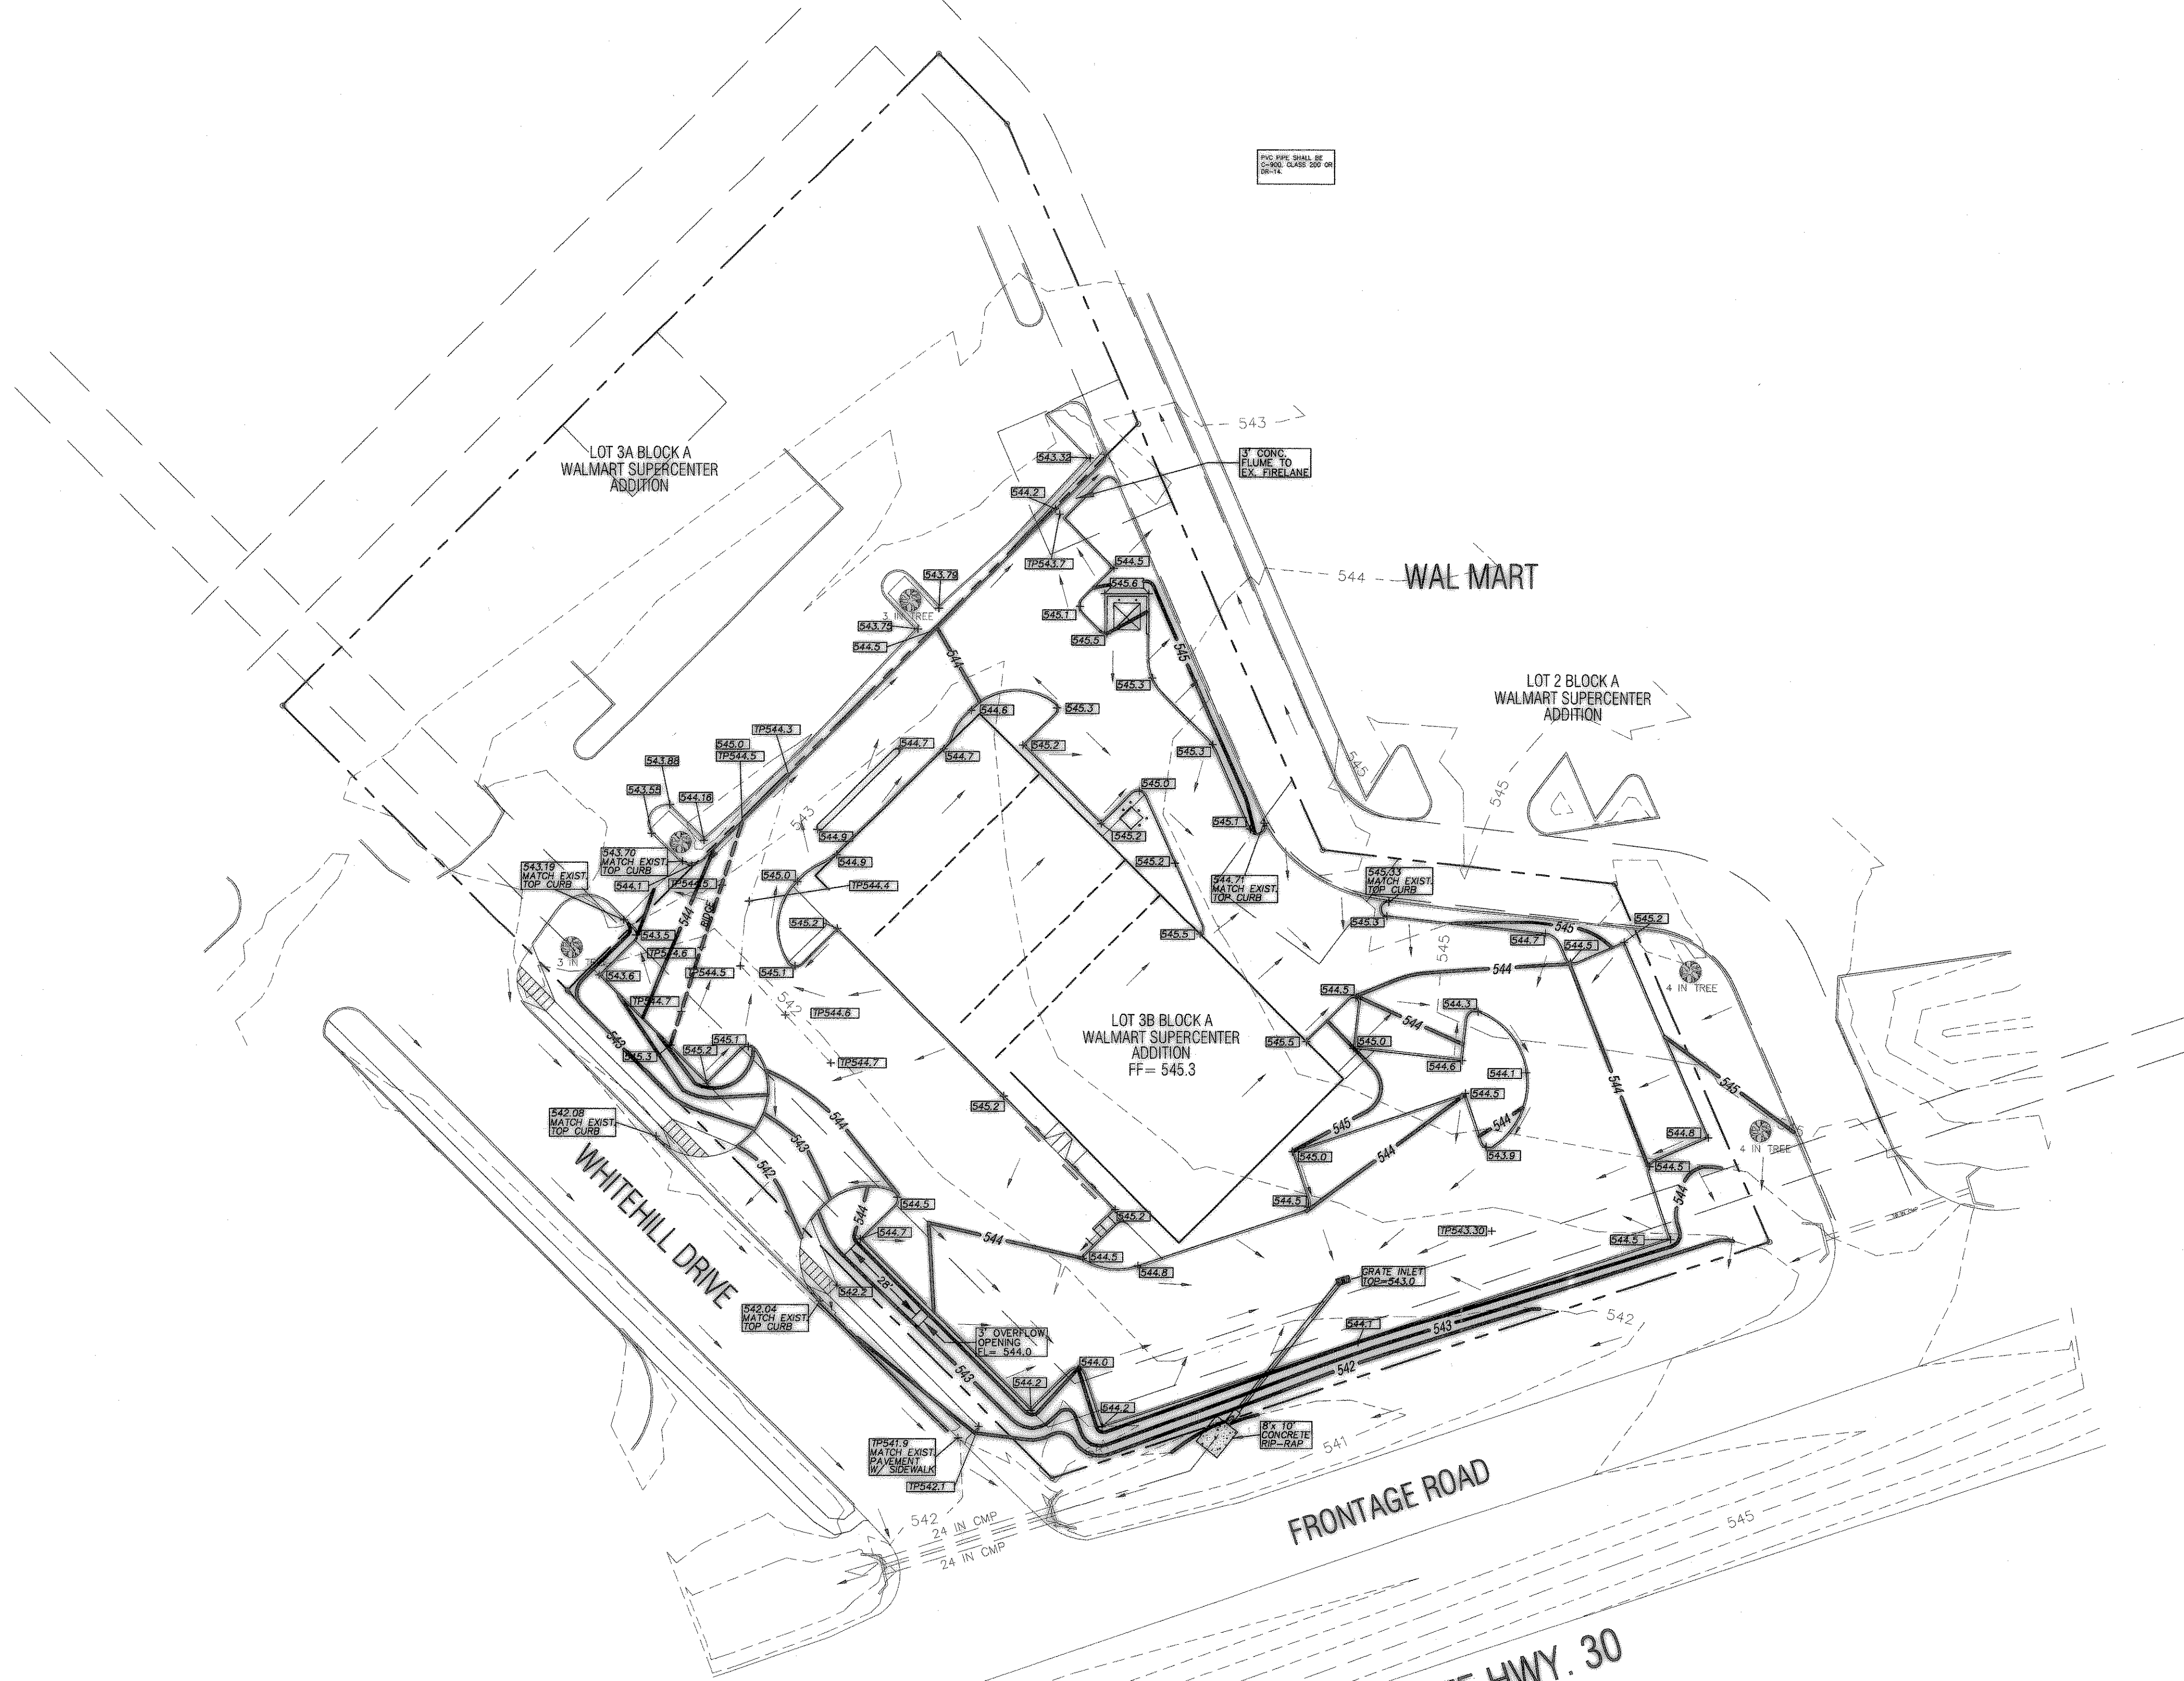

BENCHMARK:
 SQUARE CUT ON NORTH CORNER OF INLET ON EAST SIDE OF
 TACO BUENO.
 ELEVATION = 541.75

AS-BUILT

dietz engineering

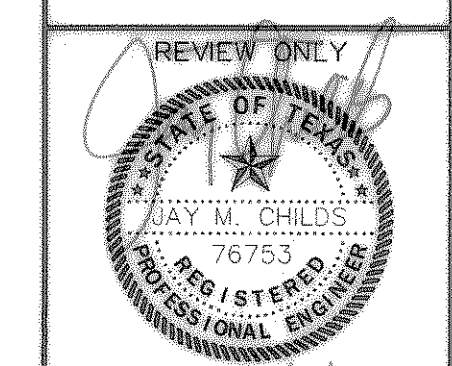


Signing Date: 5/24/01

dietz engineering
 811 e. plano parkway
 suite 109
 plano, texas 75074
 voice: 972 633-8867
 fax: 972 633-1327

Drawn By: LL
 Checked By: JMC

Revisions:

SITE RETAIL
GRADING PLAN
PLAN VIEW
 for the
 City of Rockwall, Texas

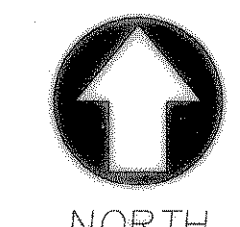

24"x36" Scale: 1" = 30'

11"x17" Scale: 1" = 60'

Vertical Scale: NA

Project Number: E-SPC-001

Issue Date: 24 MAY 2001

Sheet Title:
GRADING PLAN

Sheet No.:

C1.02