

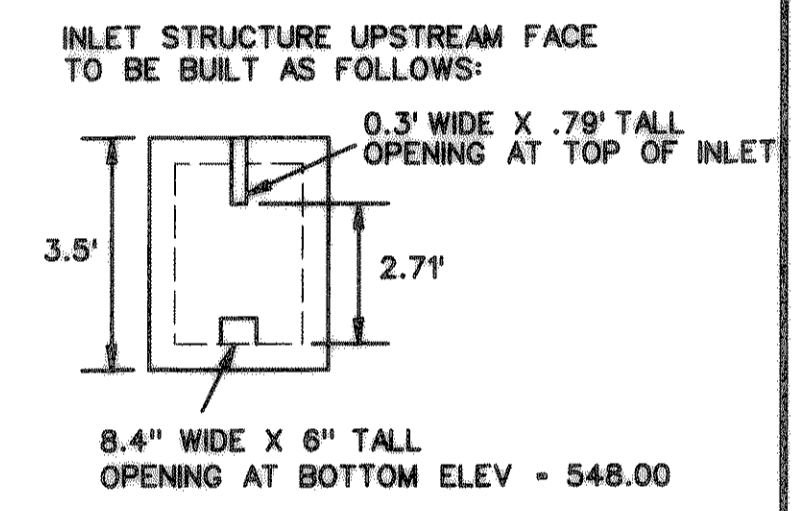
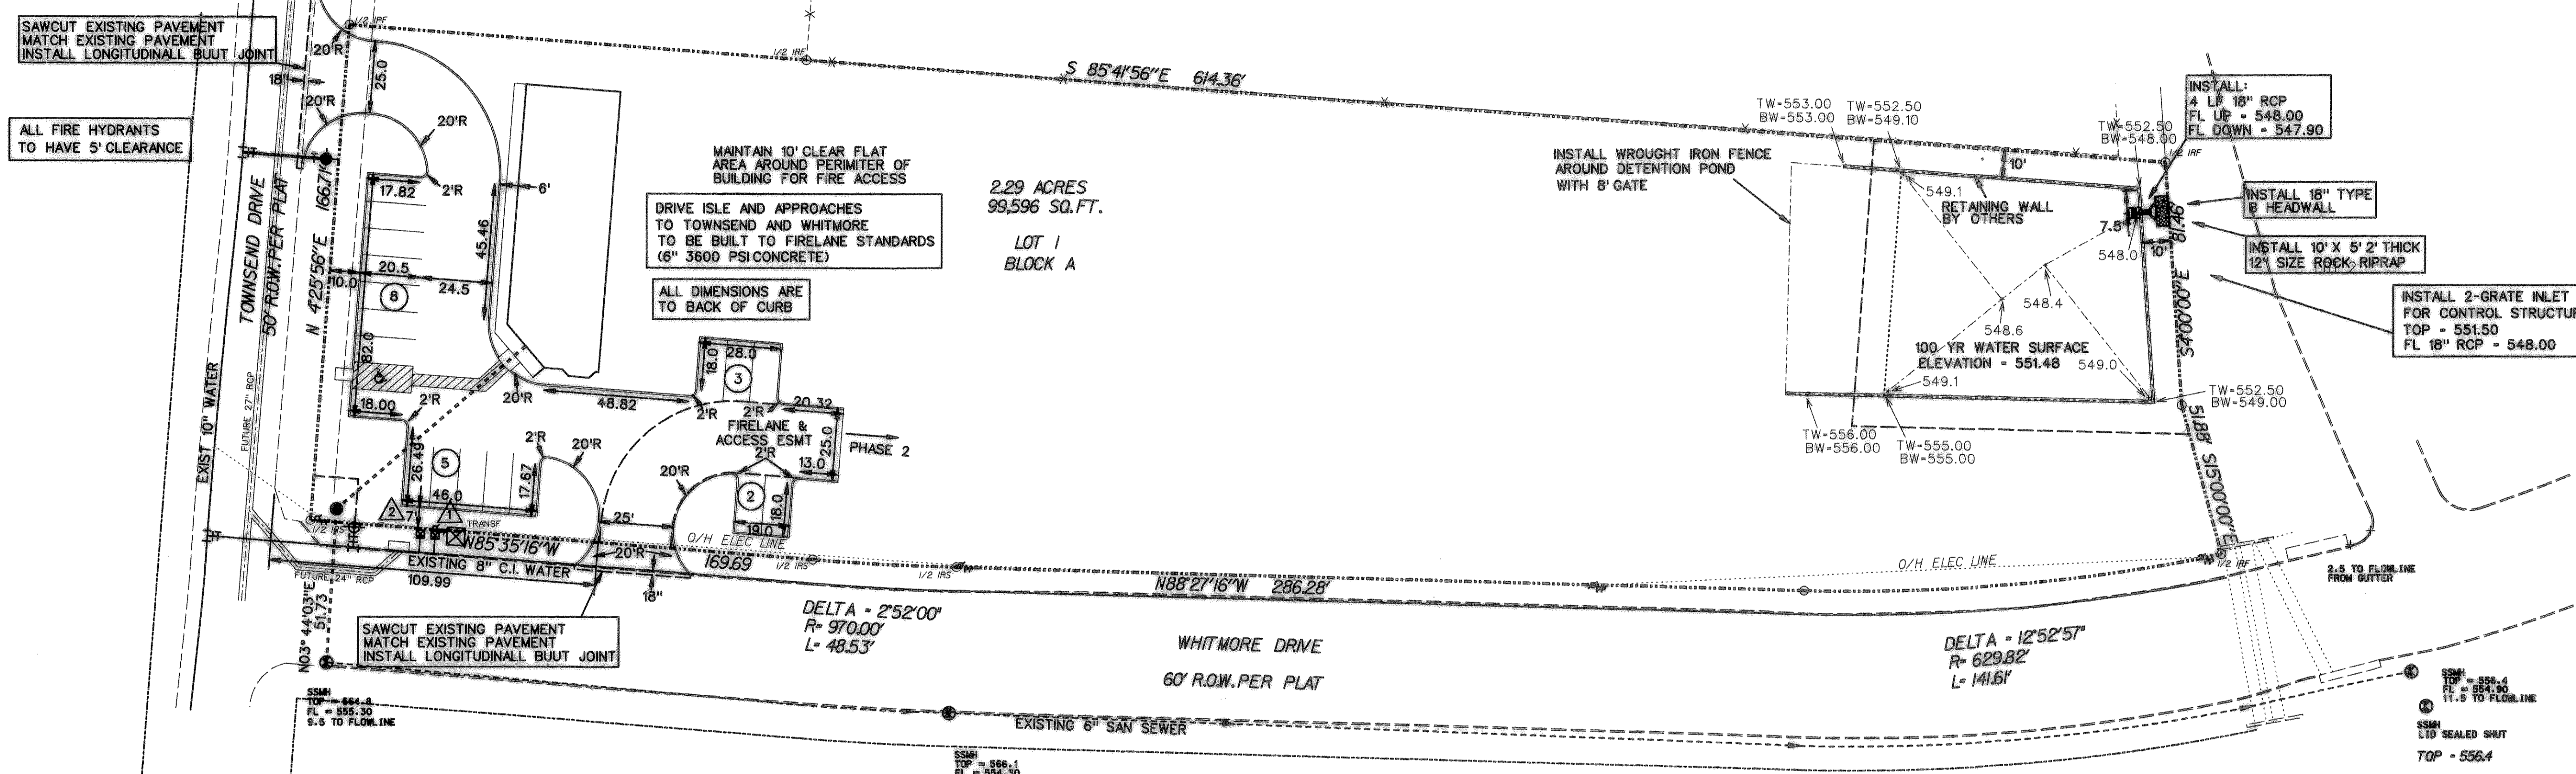


VICINITY MAP
NOT TO SCALE

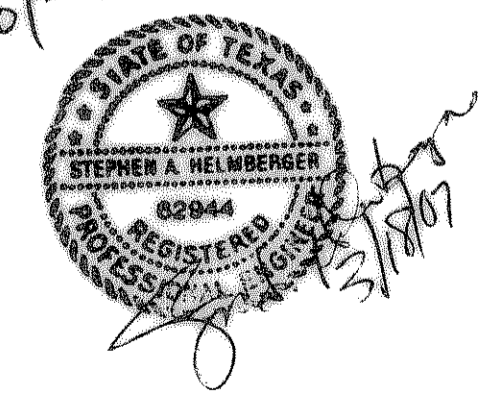

RECORD DRAWING 10-29-07

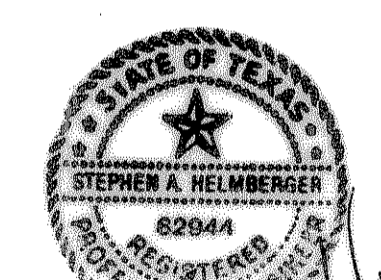

OWNER: ROBERT VARNER, JR.
703 MCKINNEY AVENUE
DALLAS, TEXAS 75202
PHONE: 214-740-0214

WATER METER SCHEDULE			
TYPE	SIZE	NUMBER	SANITARY SEWER
DOMESTIC	2"	1 - PROPOSED	6"
IRRIGATION	1"	1 - PROPOSED	NA

SITE PLAN						
LOT 1 - BLOCK A MUNICIPAL INDUSTRIAL PARK						
ROBERT VARNER, JR						
ROCKWALL, TEXAS						
HELMBERGER ASSOCIATES, INC. CIVIL AND ENVIRONMENTAL ENGINEERS <small>121 HOOPER ROAD, WYLE, TEXAS 75086 (972) 442-7420</small>						
DESIGN	DRAWN	DATE	SCALE	NOTES	FILE	NO.
HELM	GADD	FEBRUARY 2007	1"=30'	SPLAN	0704	C1