


CITY OF ROCKWALL, TEXAS

CONSTRUCTION PLANS FOR

QUAIL RUN ROAD LIFT STATION & FORCE MAIN

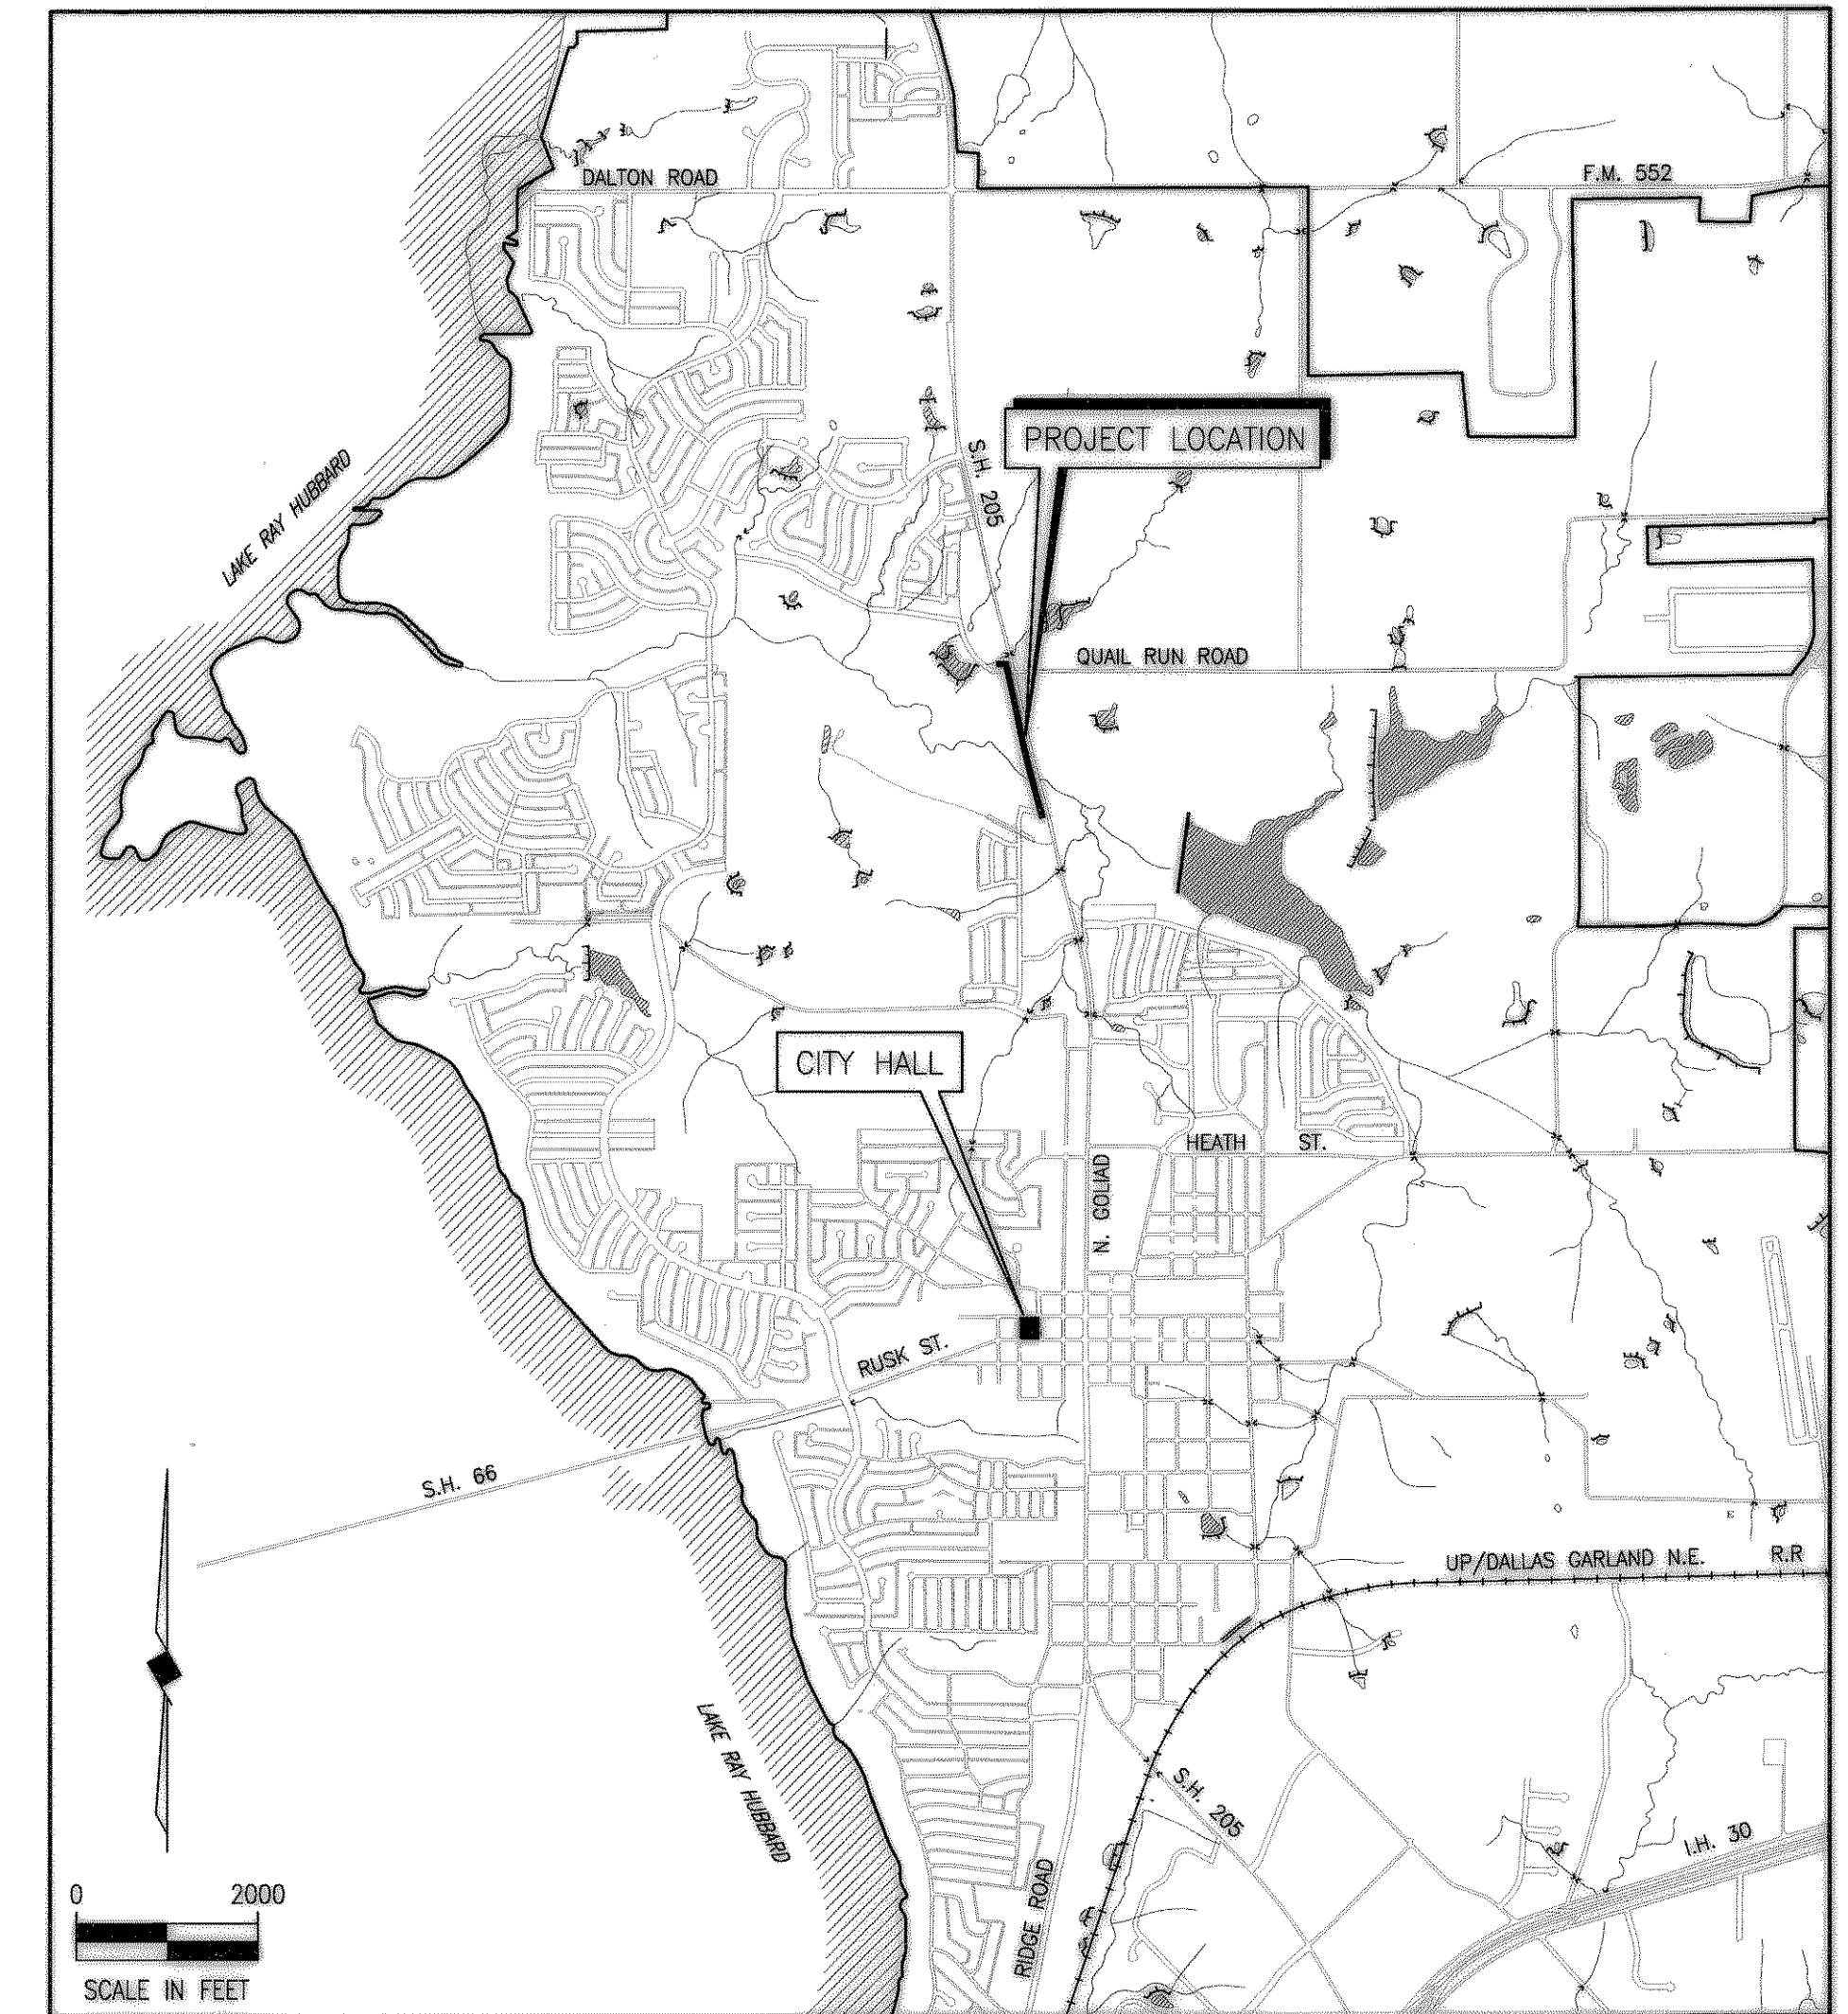

LOCATION MAP

COUNCIL MEMBERS

KEN JONES, MAYOR
 BILL CECIL, MAYOR PRO-TEM
 BOB COTTI
 JOHN KING
 TERRY RAULSTON
 BILLY MORRIS
 RON COLESON

CITY MANAGER

JULIE COUCH


ASSISTANT CITY MANAGER

RICHARD CROWLEY

CITY ENGINEER

CHUCK TODD, P.E.

- ① FIELD CHANGE NO. 1 - REVISED FORCE MAIN ALIGNMENT
- ⚠ CHANGE ORDER NO. 1 - 12/13/2002 REVISED LIFT STATION LOCATION

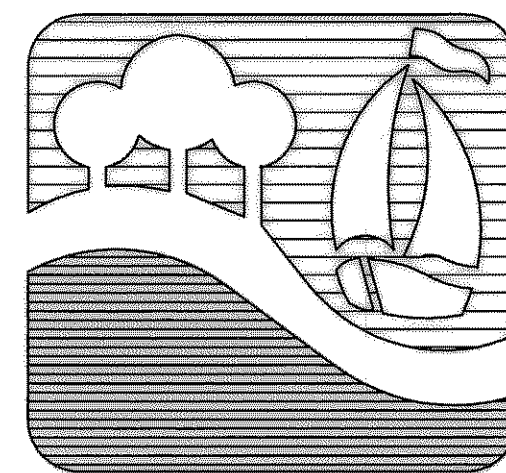


BIRKHOFF, HENDRICKS & CONWAY, L.L.P.
 CONSULTING ENGINEERS
 Dallas, Texas

THESE DOCUMENTS ARE FOR BIDDING, CONSTRUCTION, AND PERMIT PURPOSES.

DATE: 12/13/02

DECEMBER, 2002

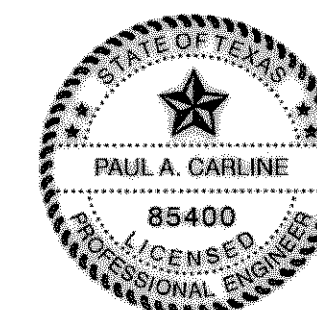

SHEET INDEX

SHEET NO.

SHEET DESCRIPTION

<u>SHEET NO.</u>	<u>SHEET DESCRIPTION</u>
-	COVER SHEET AND LOCATION MAP
1	QUAIL RUN ROAD FORCE MAIN PLAN—PROFILE STA. 0+00 TO STA. 5+00
2	QUAIL RUN ROAD FORCE MAIN PLAN—PROFILE STA. 5+00 TO STA. 10+00
3	QUAIL RUN ROAD FORCE MAIN PLAN—PROFILE STA. 10+00 TO STA. 15+00
4	QUAIL RUN ROAD FORCE MAIN PLAN—PROFILE STA. 15+00 TO STA. 20+00
5	QUAIL RUN ROAD FORCE MAIN PLAN—PROFILE STA. 20+00 TO STA. 22+34.18
6	QUAIL RUN ROAD LIFT STATION SITE PLAN AND ABANDONMENT PLAN
7	QUAIL RUN ROAD LIFT STATION PIPING SECTIONS
8	MISCELLANEOUS DETAILS
E1	ELECTRICAL SITE PLAN
E2	ONE LINE DIAGRAM & SCHEMATICS
E3	ELECTRICAL SCHEMATICS & DIAGRAMS
E4	ELECTRICAL DETAILS
S1	STRUCTURAL PLANS & SECTIONS - CAST IN PLACE OPTION
S2	STRUCTURAL PLANS & SECTIONS - CAST IN PLACE OPTION
S3	STRUCTURAL PLANS & SECTIONS - PRE-CAST OPTION
S4	STRUCTURAL PLANS & SECTIONS - PRE-CAST OPTION

REVISED TO CONFORM TO CONSTRUCTION RECORDS BY PAC DATE 10/31/05