




Revisions:

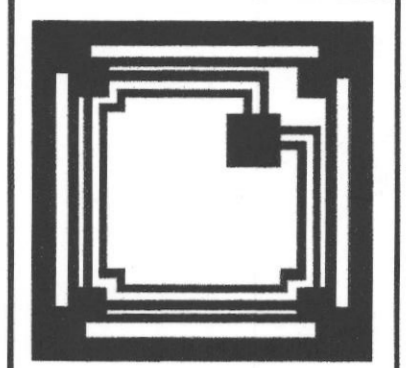

HALLUM ARCHITECTS, INC.
 2501 PARKVIEW DRIVE, SUITE 430
 FORT WORTH, TEXAS 76102
 PHONE: 817.332.2422 FAX: 817.338.1949
 email: info@hallumarch.com

Rockwall Lakeside Church of Christ
 New Auditorium and Education Facilities
 485 North FM 549, Rockwall, Texas 75087

SITE PLAN
 PRELIMINARY
 These documents are incomplete and may not be used for construction without the approval of the local authority having jurisdiction. V. Andrew Hallum, State of Texas registration # 2426. Date 2/15/2004

Date: 1/15/04
 Scale:
 Drawn:
 Job: 2002-10
 Sheet Number:


P1

(CONTROLLING BEARING LINE)
 S 89°18'40"E 2096.33'

ZONED: SF-E4

PROPOSED PROPERTY LINE
 PER NEW PLAT; REFER REVISED
 SURVEY FOR DESCRIPTION.

ROCKWALL LAKESIDE CHURCH
 of CHRIST ADDITION
 LOT 1 BLOCK A
 PROPOSED CHURCH
 APPROX. 37,000 SF.

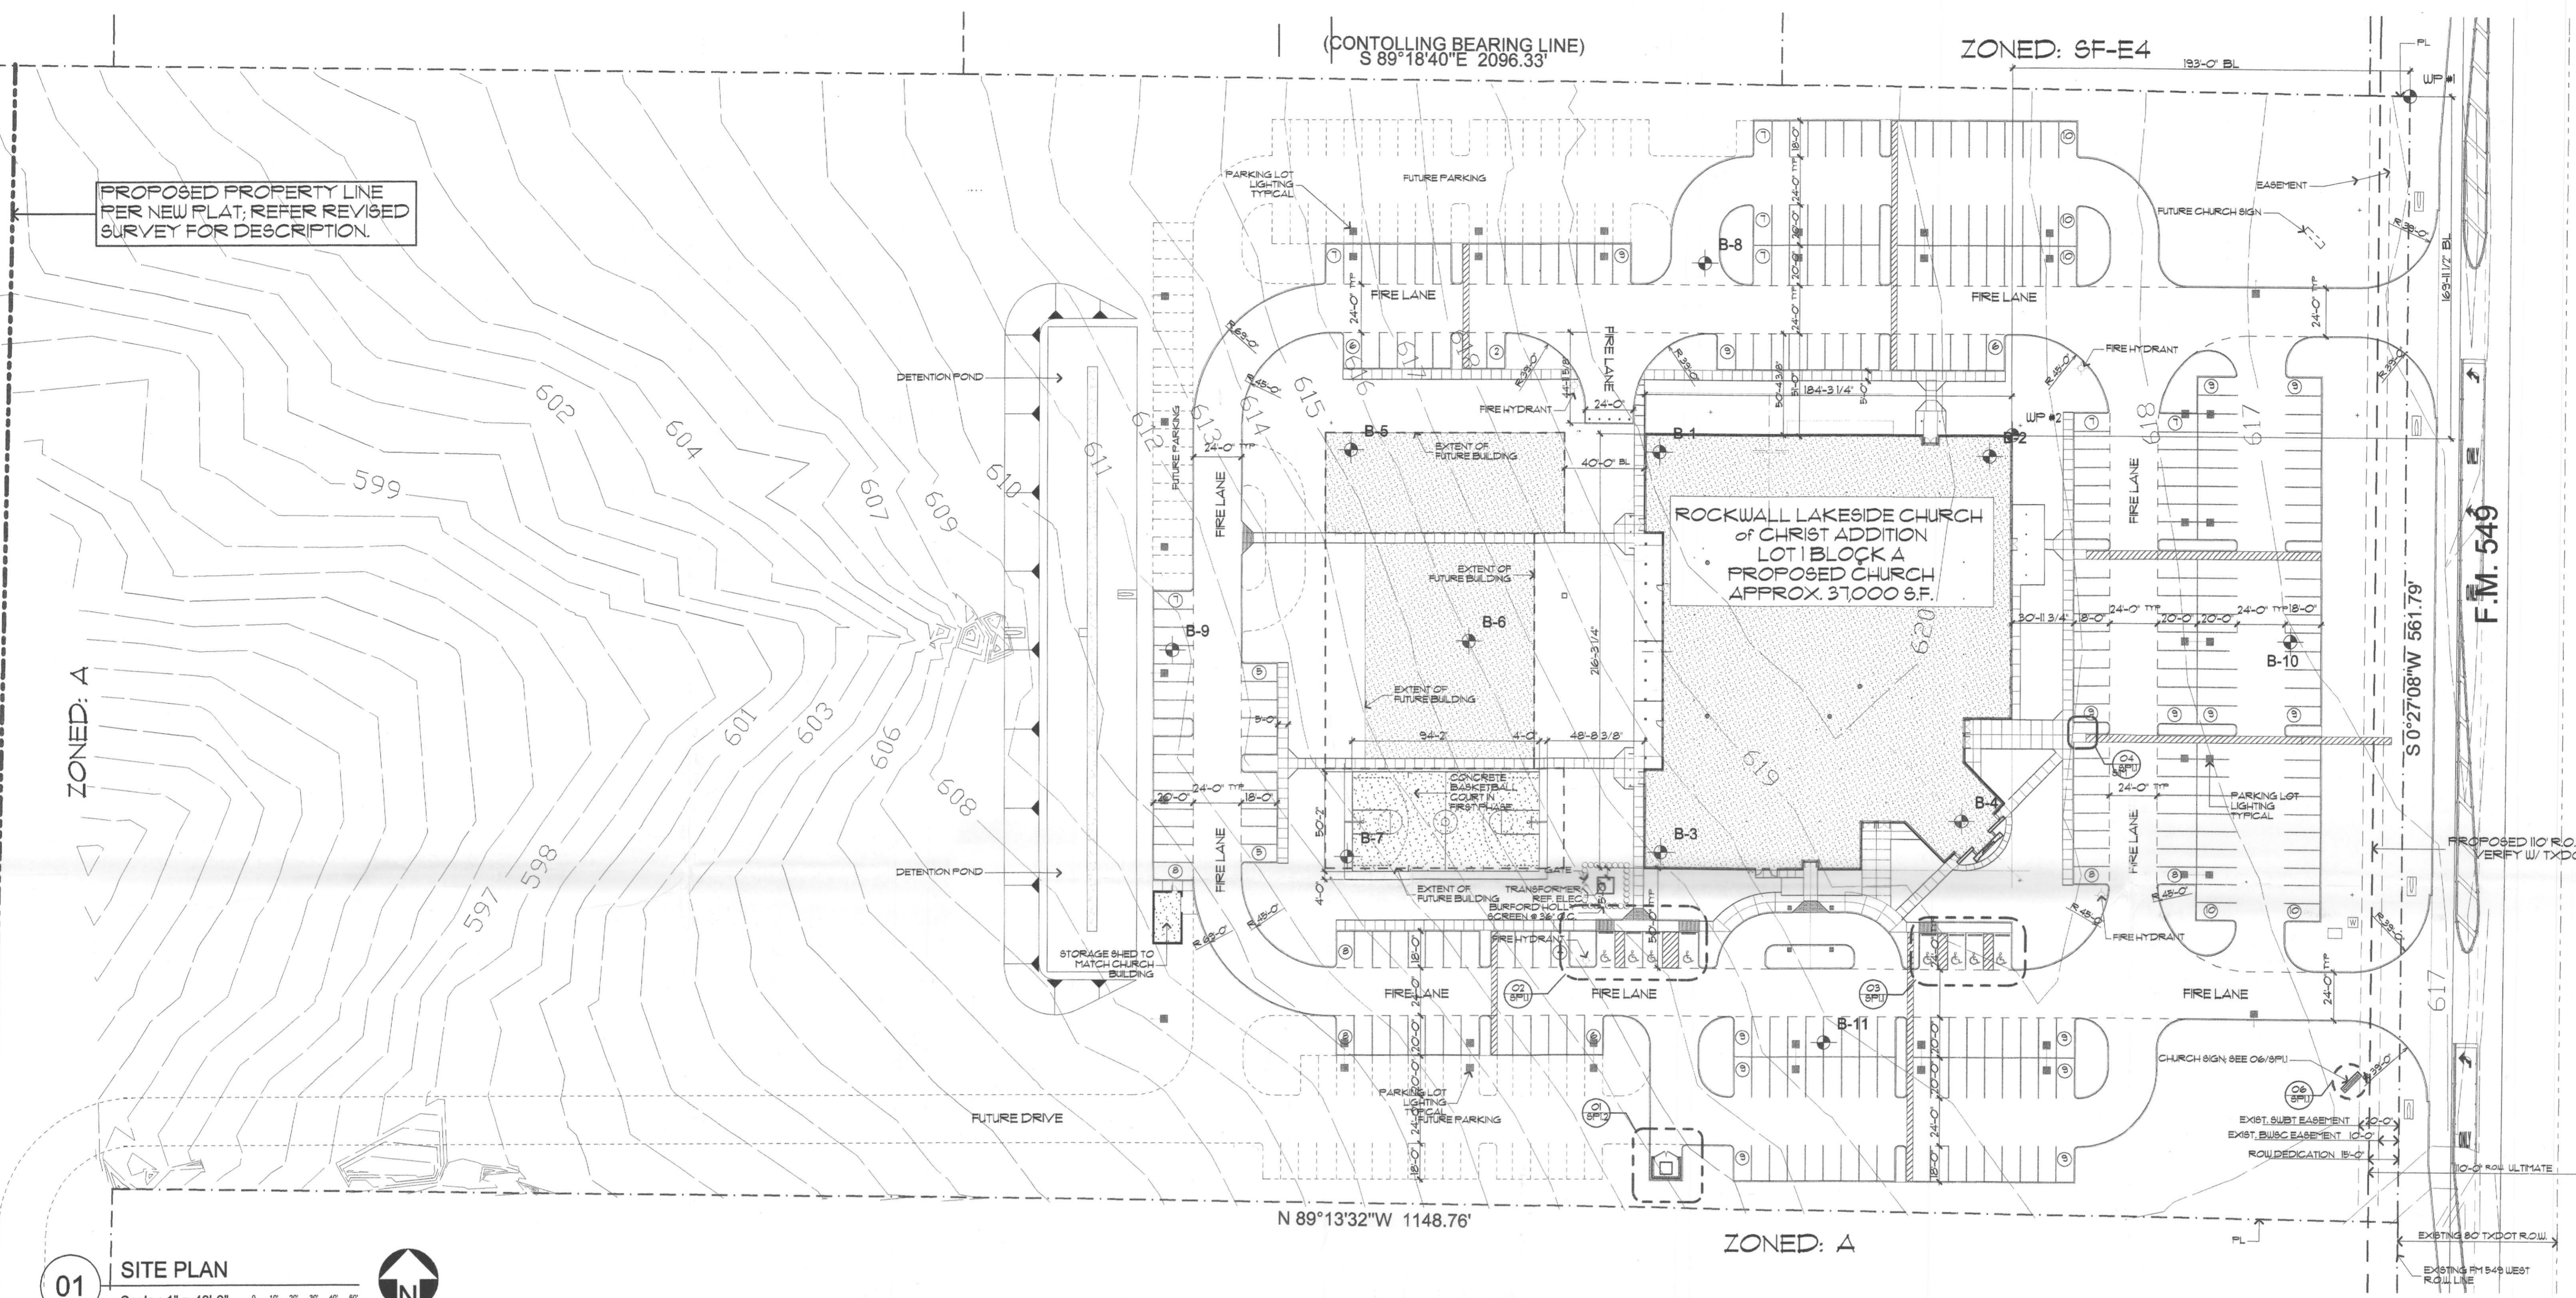

ZONED: A

ZONED: A

01 SITE PLAN
 Scale: 1" = 40'-0"

EXISTING ACREAGE w/o R.O.W.: 14.555 Acres
 EXISTING ACREAGE w/ R.O.W.: 15.748 Acres

BUILDING AREA: 37,000 SF 05%
 PARKING AREA: 126,244 SF 20%
 INTERNAL AREA: 42,600 SF 06%

OWNER:
 ROCKWALL LAKESIDE CHURCH of CHRIST
 485 North FM 549
 Rockwall, TX 75087
 Phone: (972) 771-9161
 MR. BRAD HOLLAND - OWNER REPRESENTATIVE

PREPARER:
 HALLUM ARCHITECTS, INC.
 2501 Parkview Drive Suite 430
 Fort Worth, Texas 76102
 Phone: (817) 332-2422
 JEFFREY HUNTER HALLUM, Assoc. AIA

LANDSCAPE TABLE

COMMON NAME	LATIN NAME	QTY	SPACING
TREES			
LIVE OAK	Quercus virginiana	26	Ref. Plan
RED OAK	Quercus shumardii Texensis	25	Ref. Plan
CRAPENYRTLE	Lagerstroemia indica	24	
EASTERN RED CEDAR "	Juniperus virginiana	5	Ref. Plan
YAUFON HOLLY	Ilex vomitoria " (25% male)	22	Ref. Plan
SHRUBS			
INDIAN HAWTHORN	Raphiolepis indica 'Pinkie'	95	5 Gal.
BURFORD HOLLY	Ilex cornuta 'Burfordii'	24	5 Gal.
GROUND COVER			
ASIAN JASMINE	Trachelospermum asiaticum	4' C	12' o.c.s.w.
BERMUDAGRASS "	Cynodon dactylon	-	SOD
" Native			

PARKING REQUIREMENTS

PHASE	SEATING	SPACES	H.C. SPACES (Included Van)
I	897		
REQUIRED		299	70
PROVIDED		299	70
II	276		
REQUIRED		92	1 ADDITIONAL (0 ADD)
PROVIDED		94	0 ADDITIONAL (0 ADD)
TOTAL	1173		
REQUIRED		391	80
PROVIDED		393	80

FILE COPY


RECEIVED
 FEB 04 2004
 By

2004-001

Copyright 2004 By Hallum Architects, Inc.
 (APPROVED SITE PLAN)
 w/ conditions



Revisions:

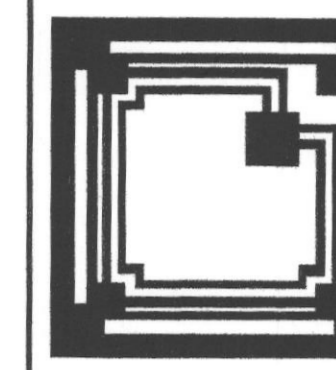


HALLUM ARCHITECTS, INC.
2501 PARKVIEW DRIVE SUITE 430
FORT WORTH, TEXAS 76102
PHONE: 817.332.2422 FAX: 817.338.1949
email: info@hallumarch.com


Rockwall Lakeside Church of Christ
New Auditorium and Education Facilities

FULL SITE PLAN
PRELIMINARY
These documents are preliminary and may not be used for regulatory approval, permit, or construction purposes.

Date: 1/15/04
Scale:
Drawn:
Job: 2002-10
Sheet Number:
P4

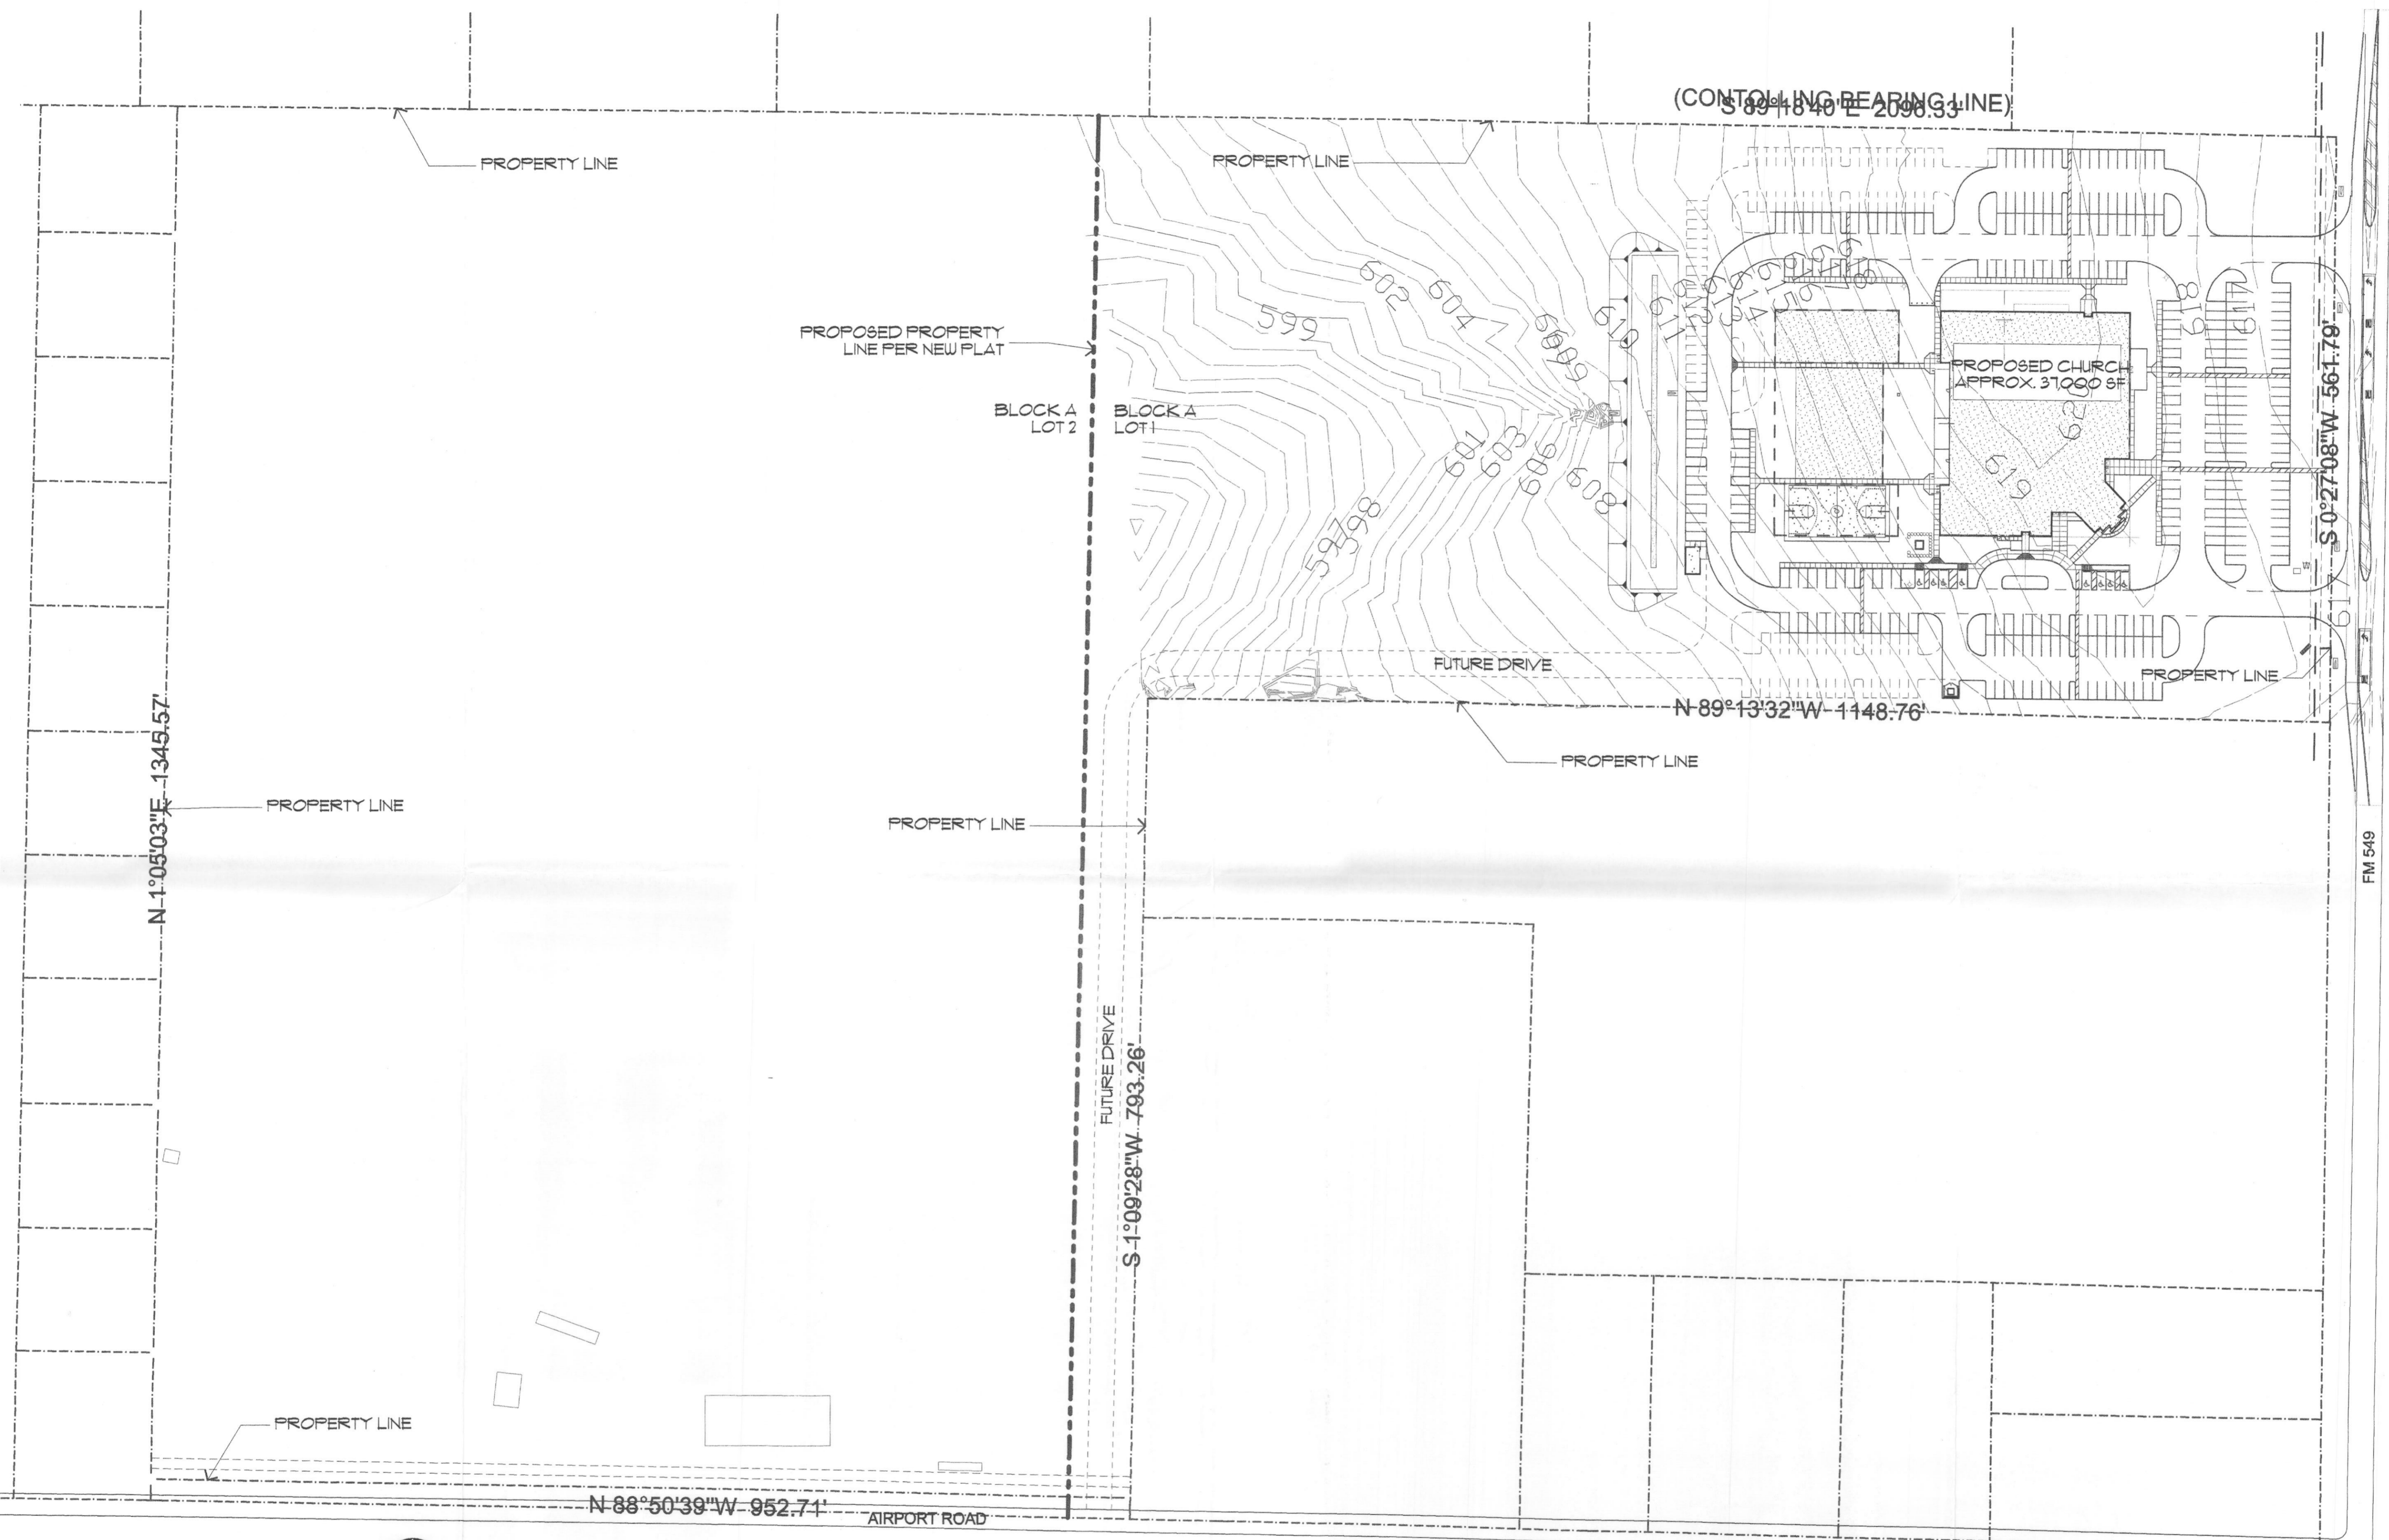


01 **SITE PLAN**
Scale: 1" = 80'-0"

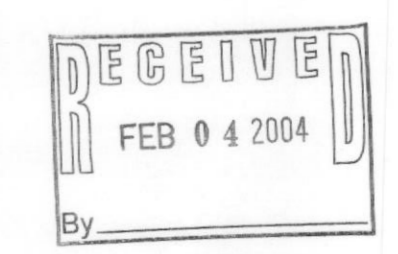


2004-001

FILE COPY (APPROVED SITE PLAN)


Copyright 2004 By Hallum Architects, Inc.

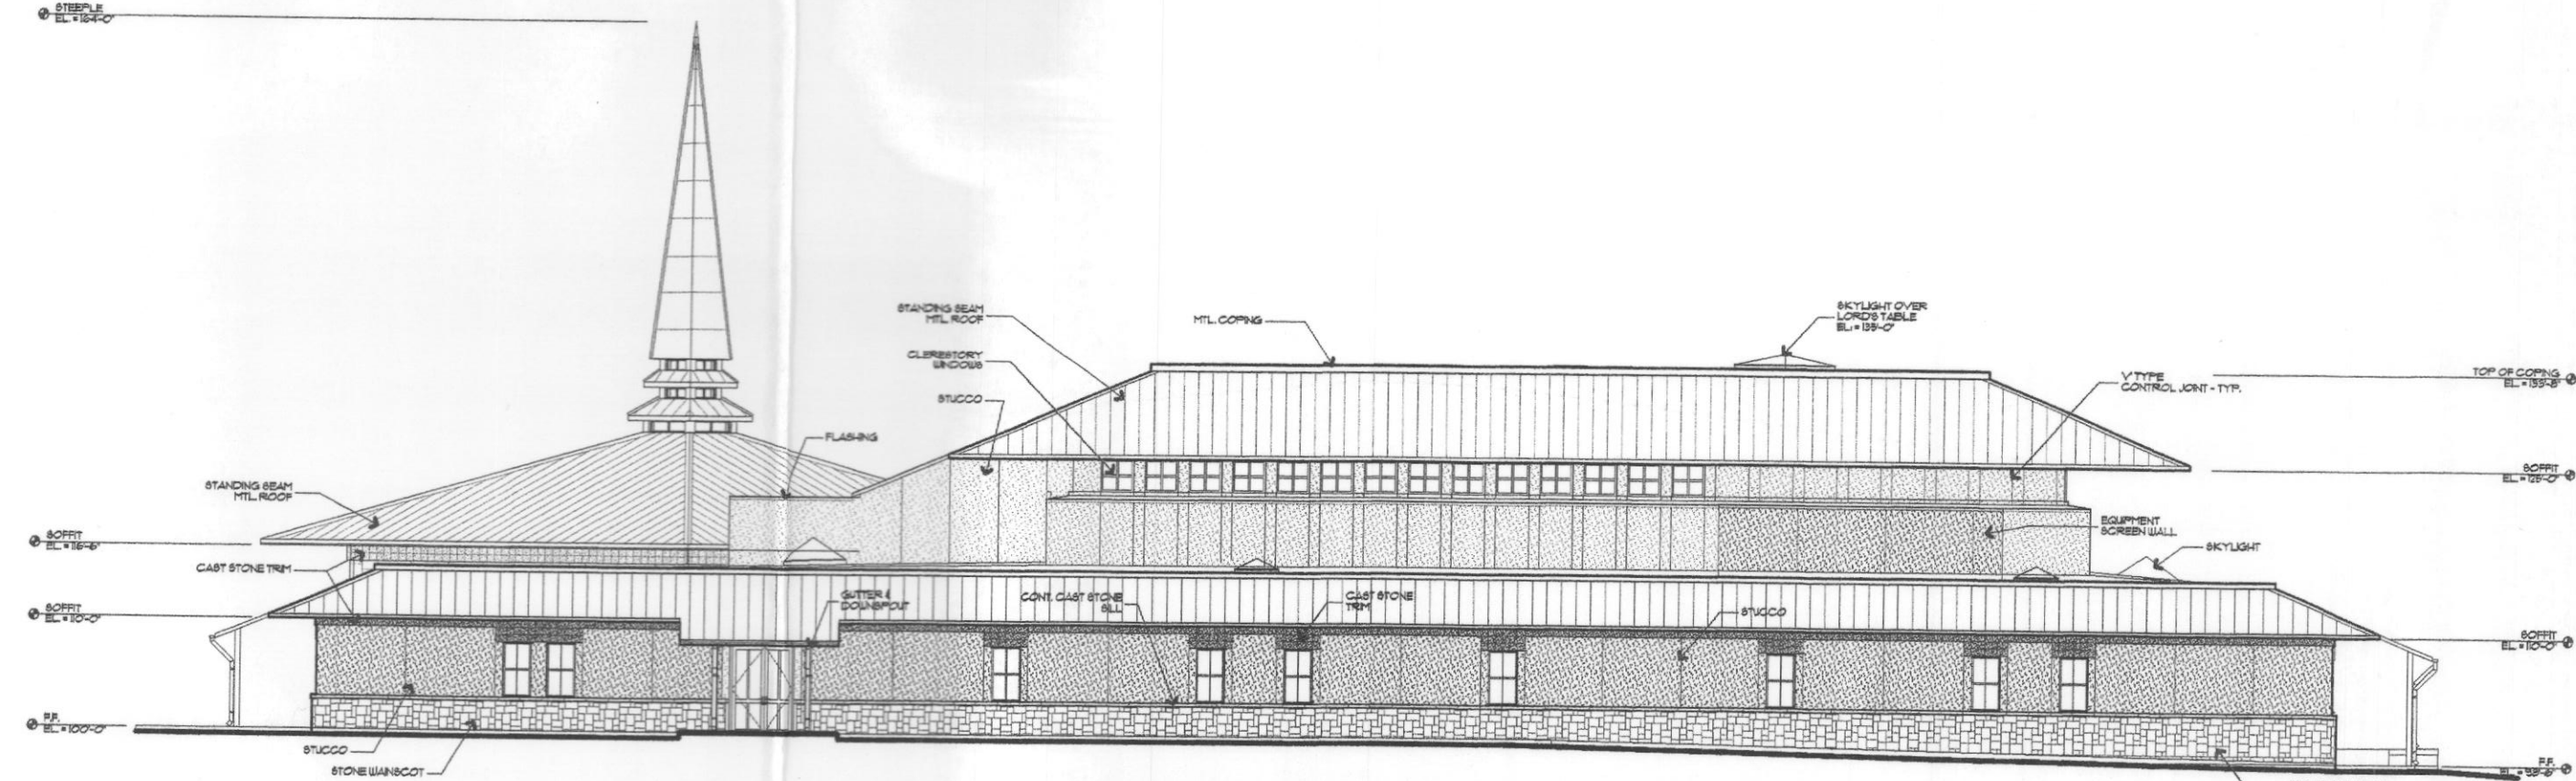


01 NORTH ELEVATION
Scale: 1/16" = 1'-0" 0 2 4 8 16 24'

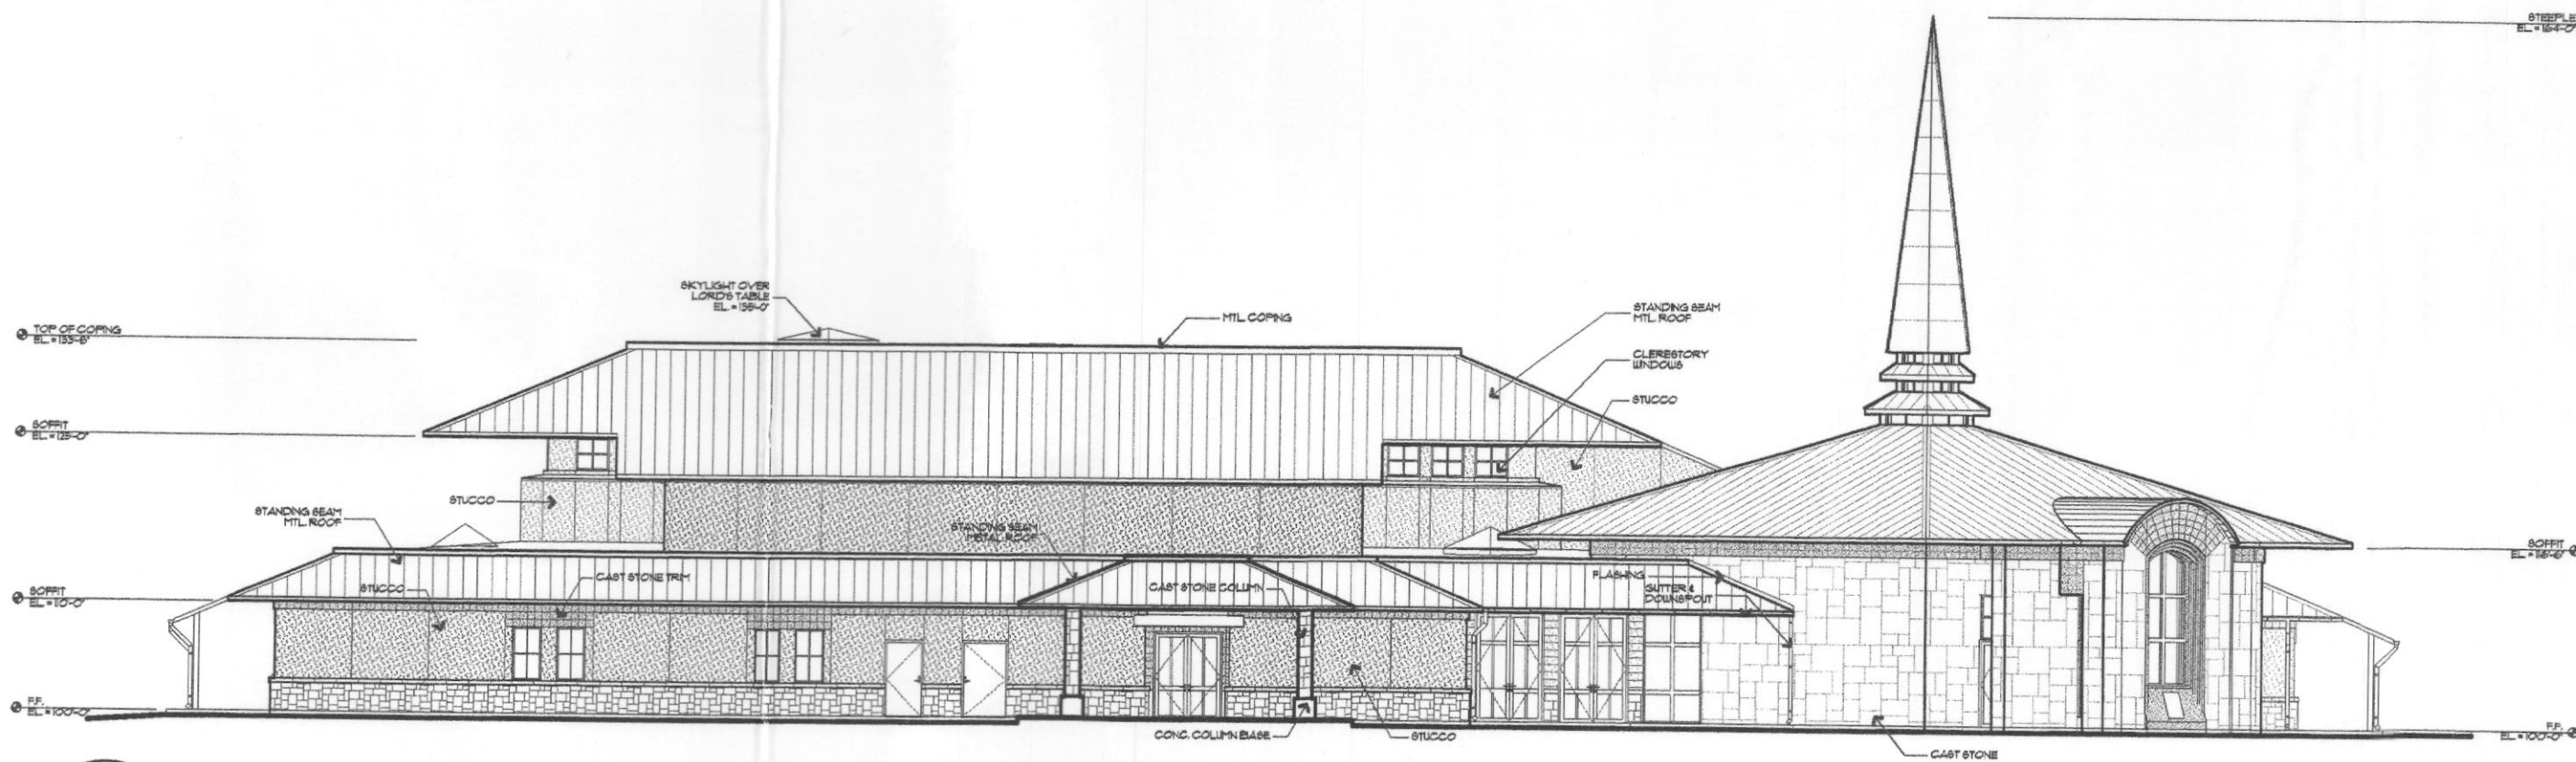


02 SOUTH ELEVATION
Scale: 1/16" = 1'-0" 0 2 4 8 16 24'

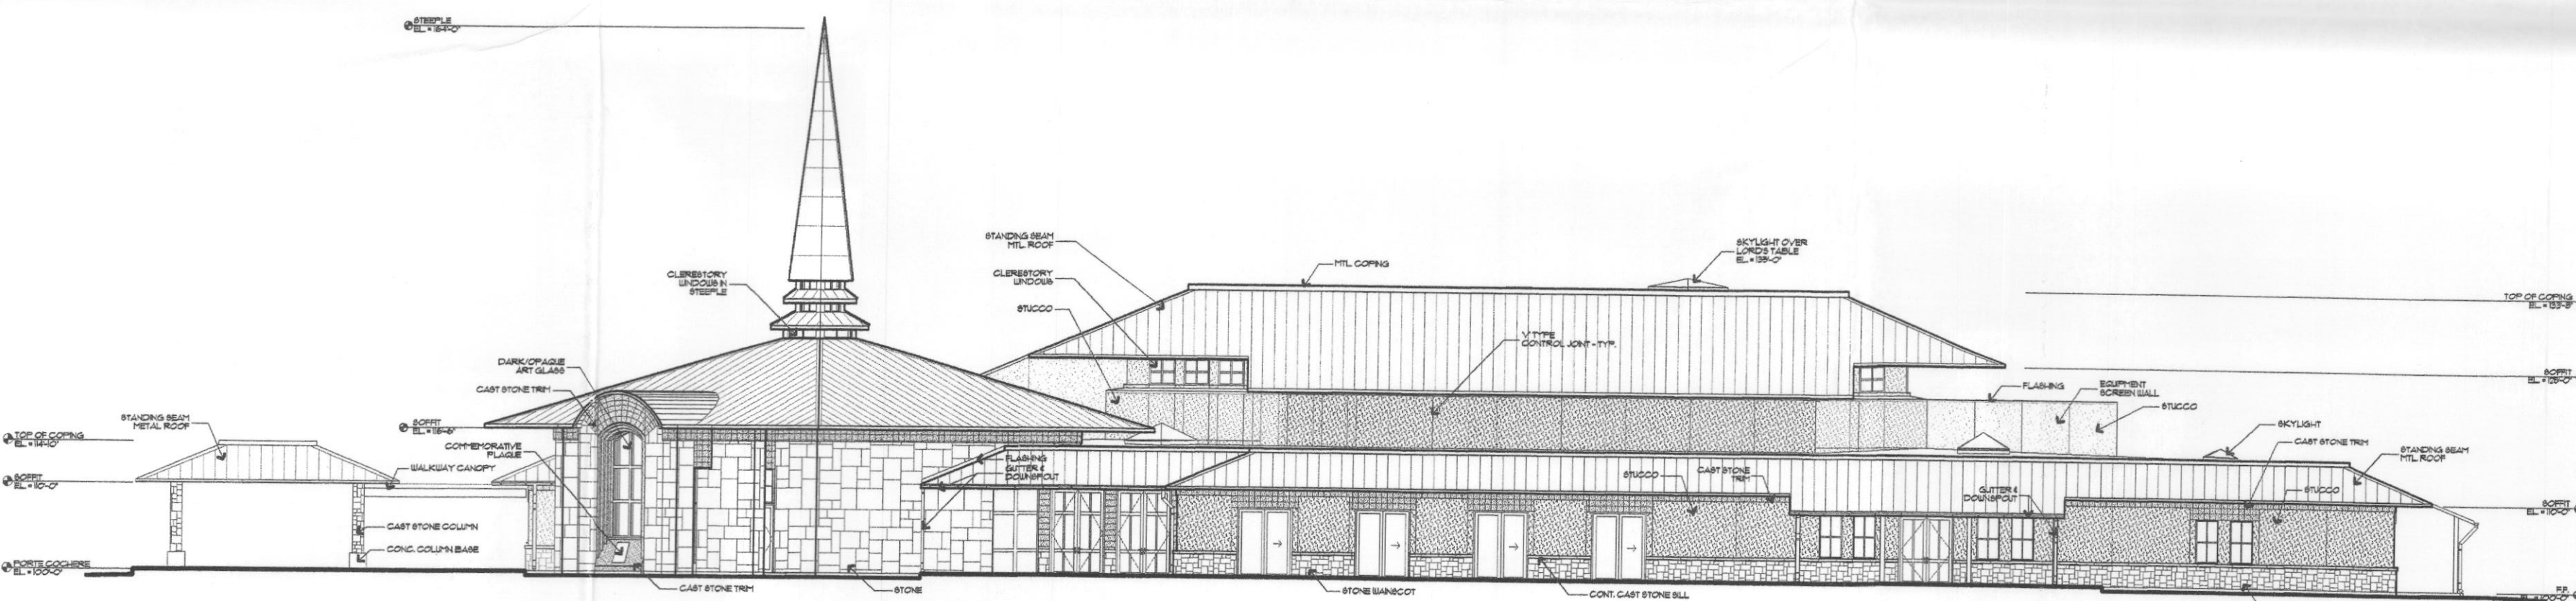


03 EAST ELEVATION
Scale: 1/16" = 1'-0" 0 2 4 8 16 24'

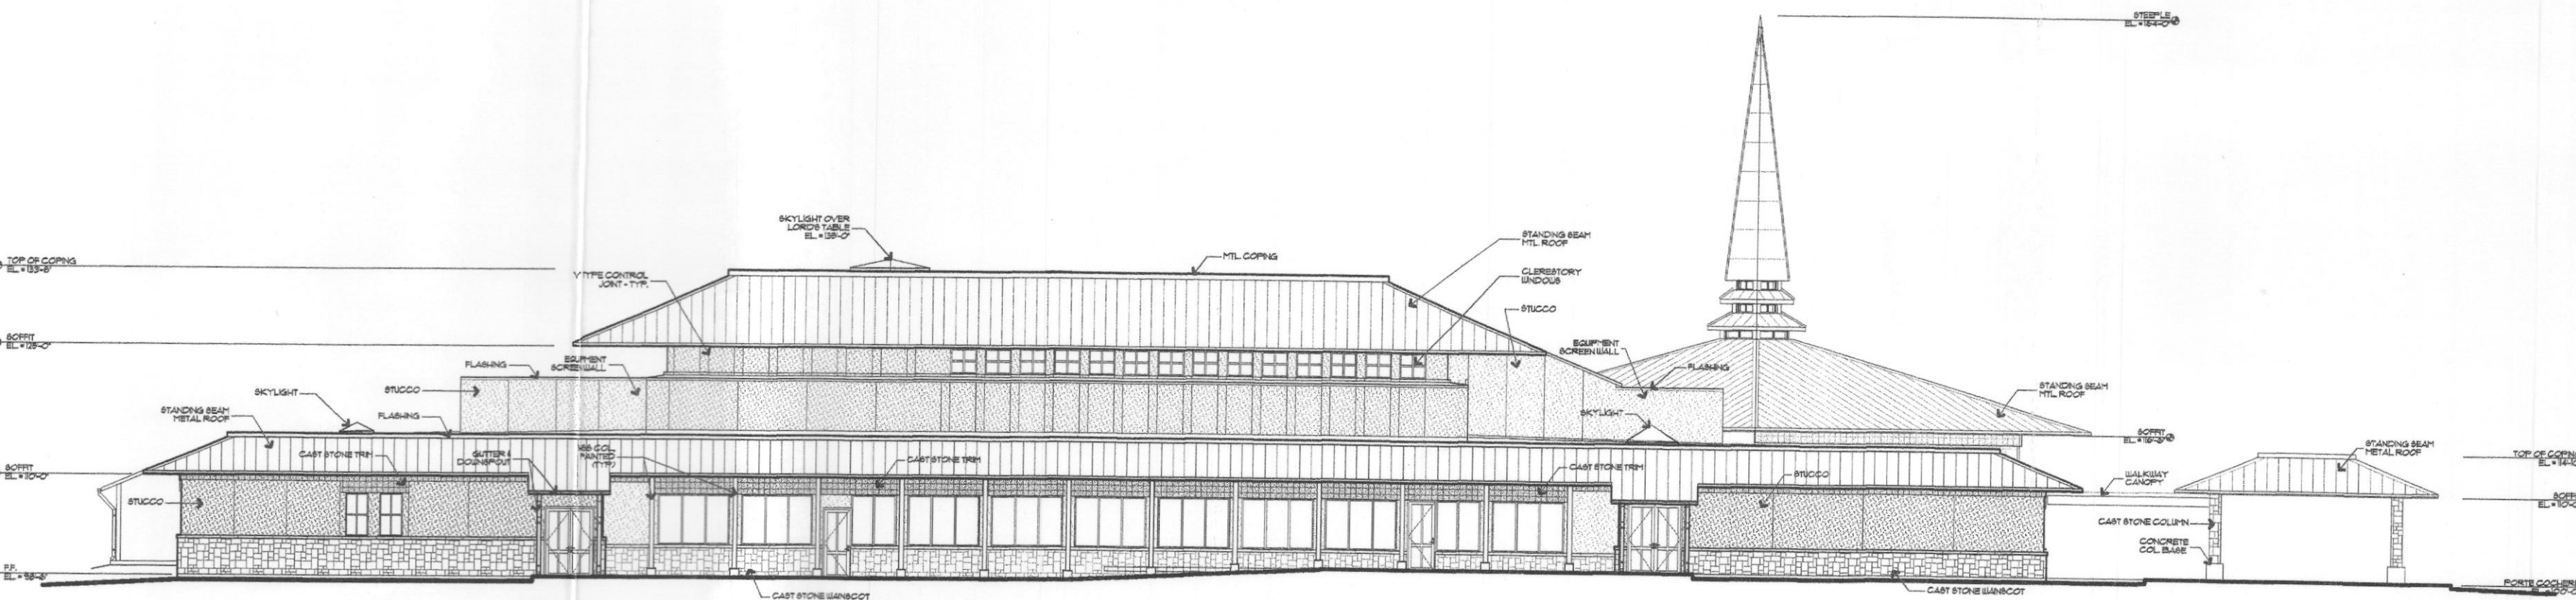

04 WEST ELEVATION
Scale: 1/16" = 1'-0" 0 2 4 8 16 24'

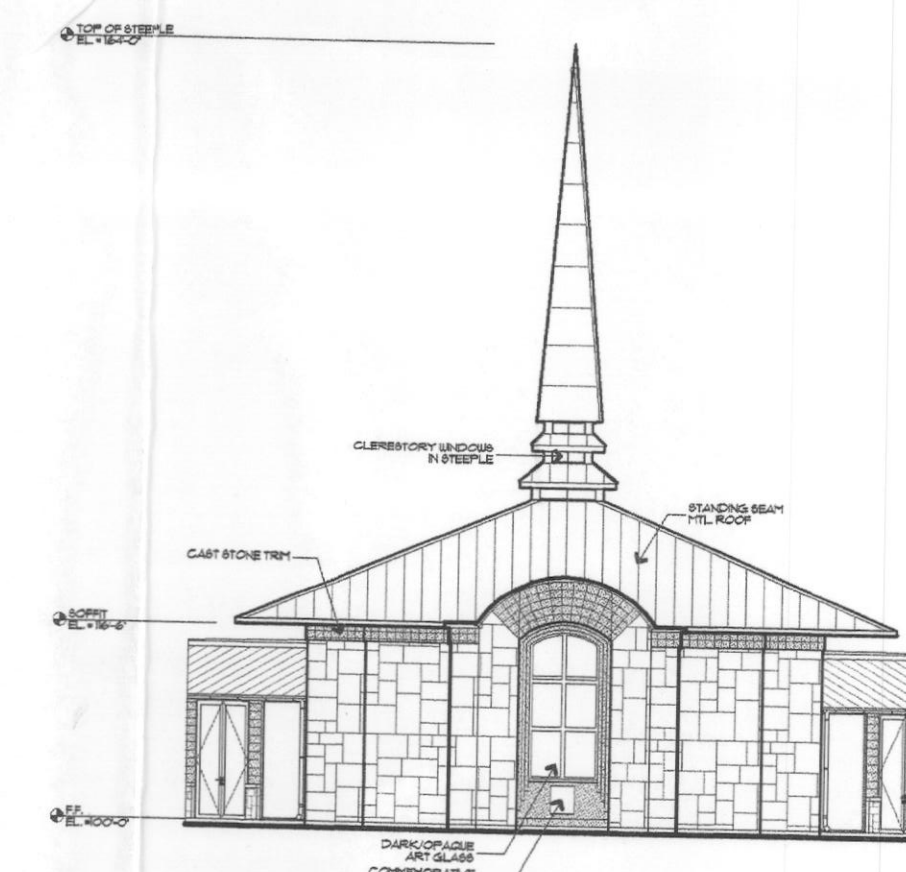


05 CHAPEL ELEVATION
Scale: 1/16" = 1'-0" 0 2 4 8 16 24'

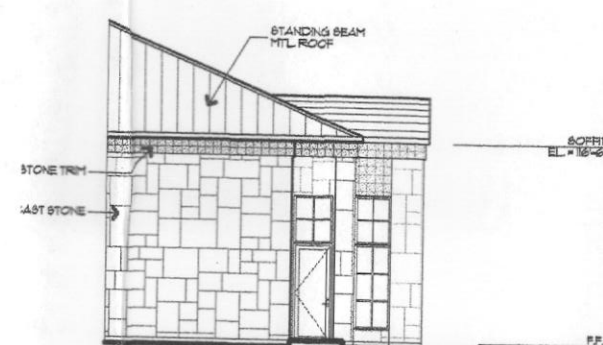


06 CHAPEL ELEVATION
Scale: 1/16" = 1'-0" 0 2 4 8 16 24'

RECEIVED
FEB 04 2004
By _____

2004-001
FILE COPY
Copyright 2004 By Hallum Architects, Inc.
(APPROVED SITE PLAN)

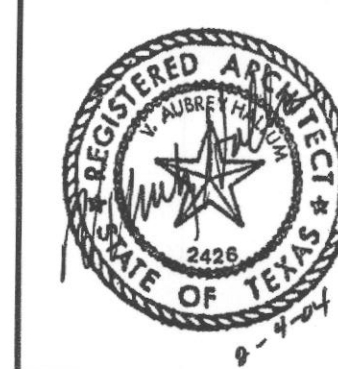

Revisions:

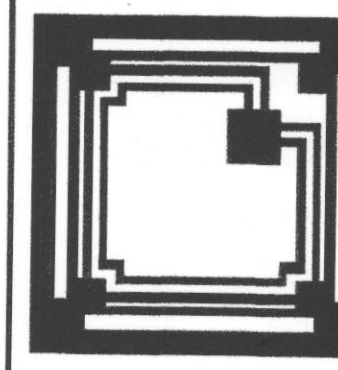


HALLUM ARCHITECTS, INC.
2501 PARKVIEW DRIVE SUITE 430
FORT WORTH, TEXAS 76102
PHONE: 817.332.2422 FAX: 817.338.1949
email: info@hallumarch.com

Rockwall Lakeside Church of Christ
New Auditorium and Education Facilities
485 North FM 549, Rockwall, Texas 75087

EXTERIOR ELEVATIONS
PRELIMINARY
These documents are incomplete and may not be used for regulatory approval, permit, or construction purposes.
Date 2/4/2004

Date: 1/15/04
Scale:
Drawn:
Job: 2002-10
Sheet Number:
P3

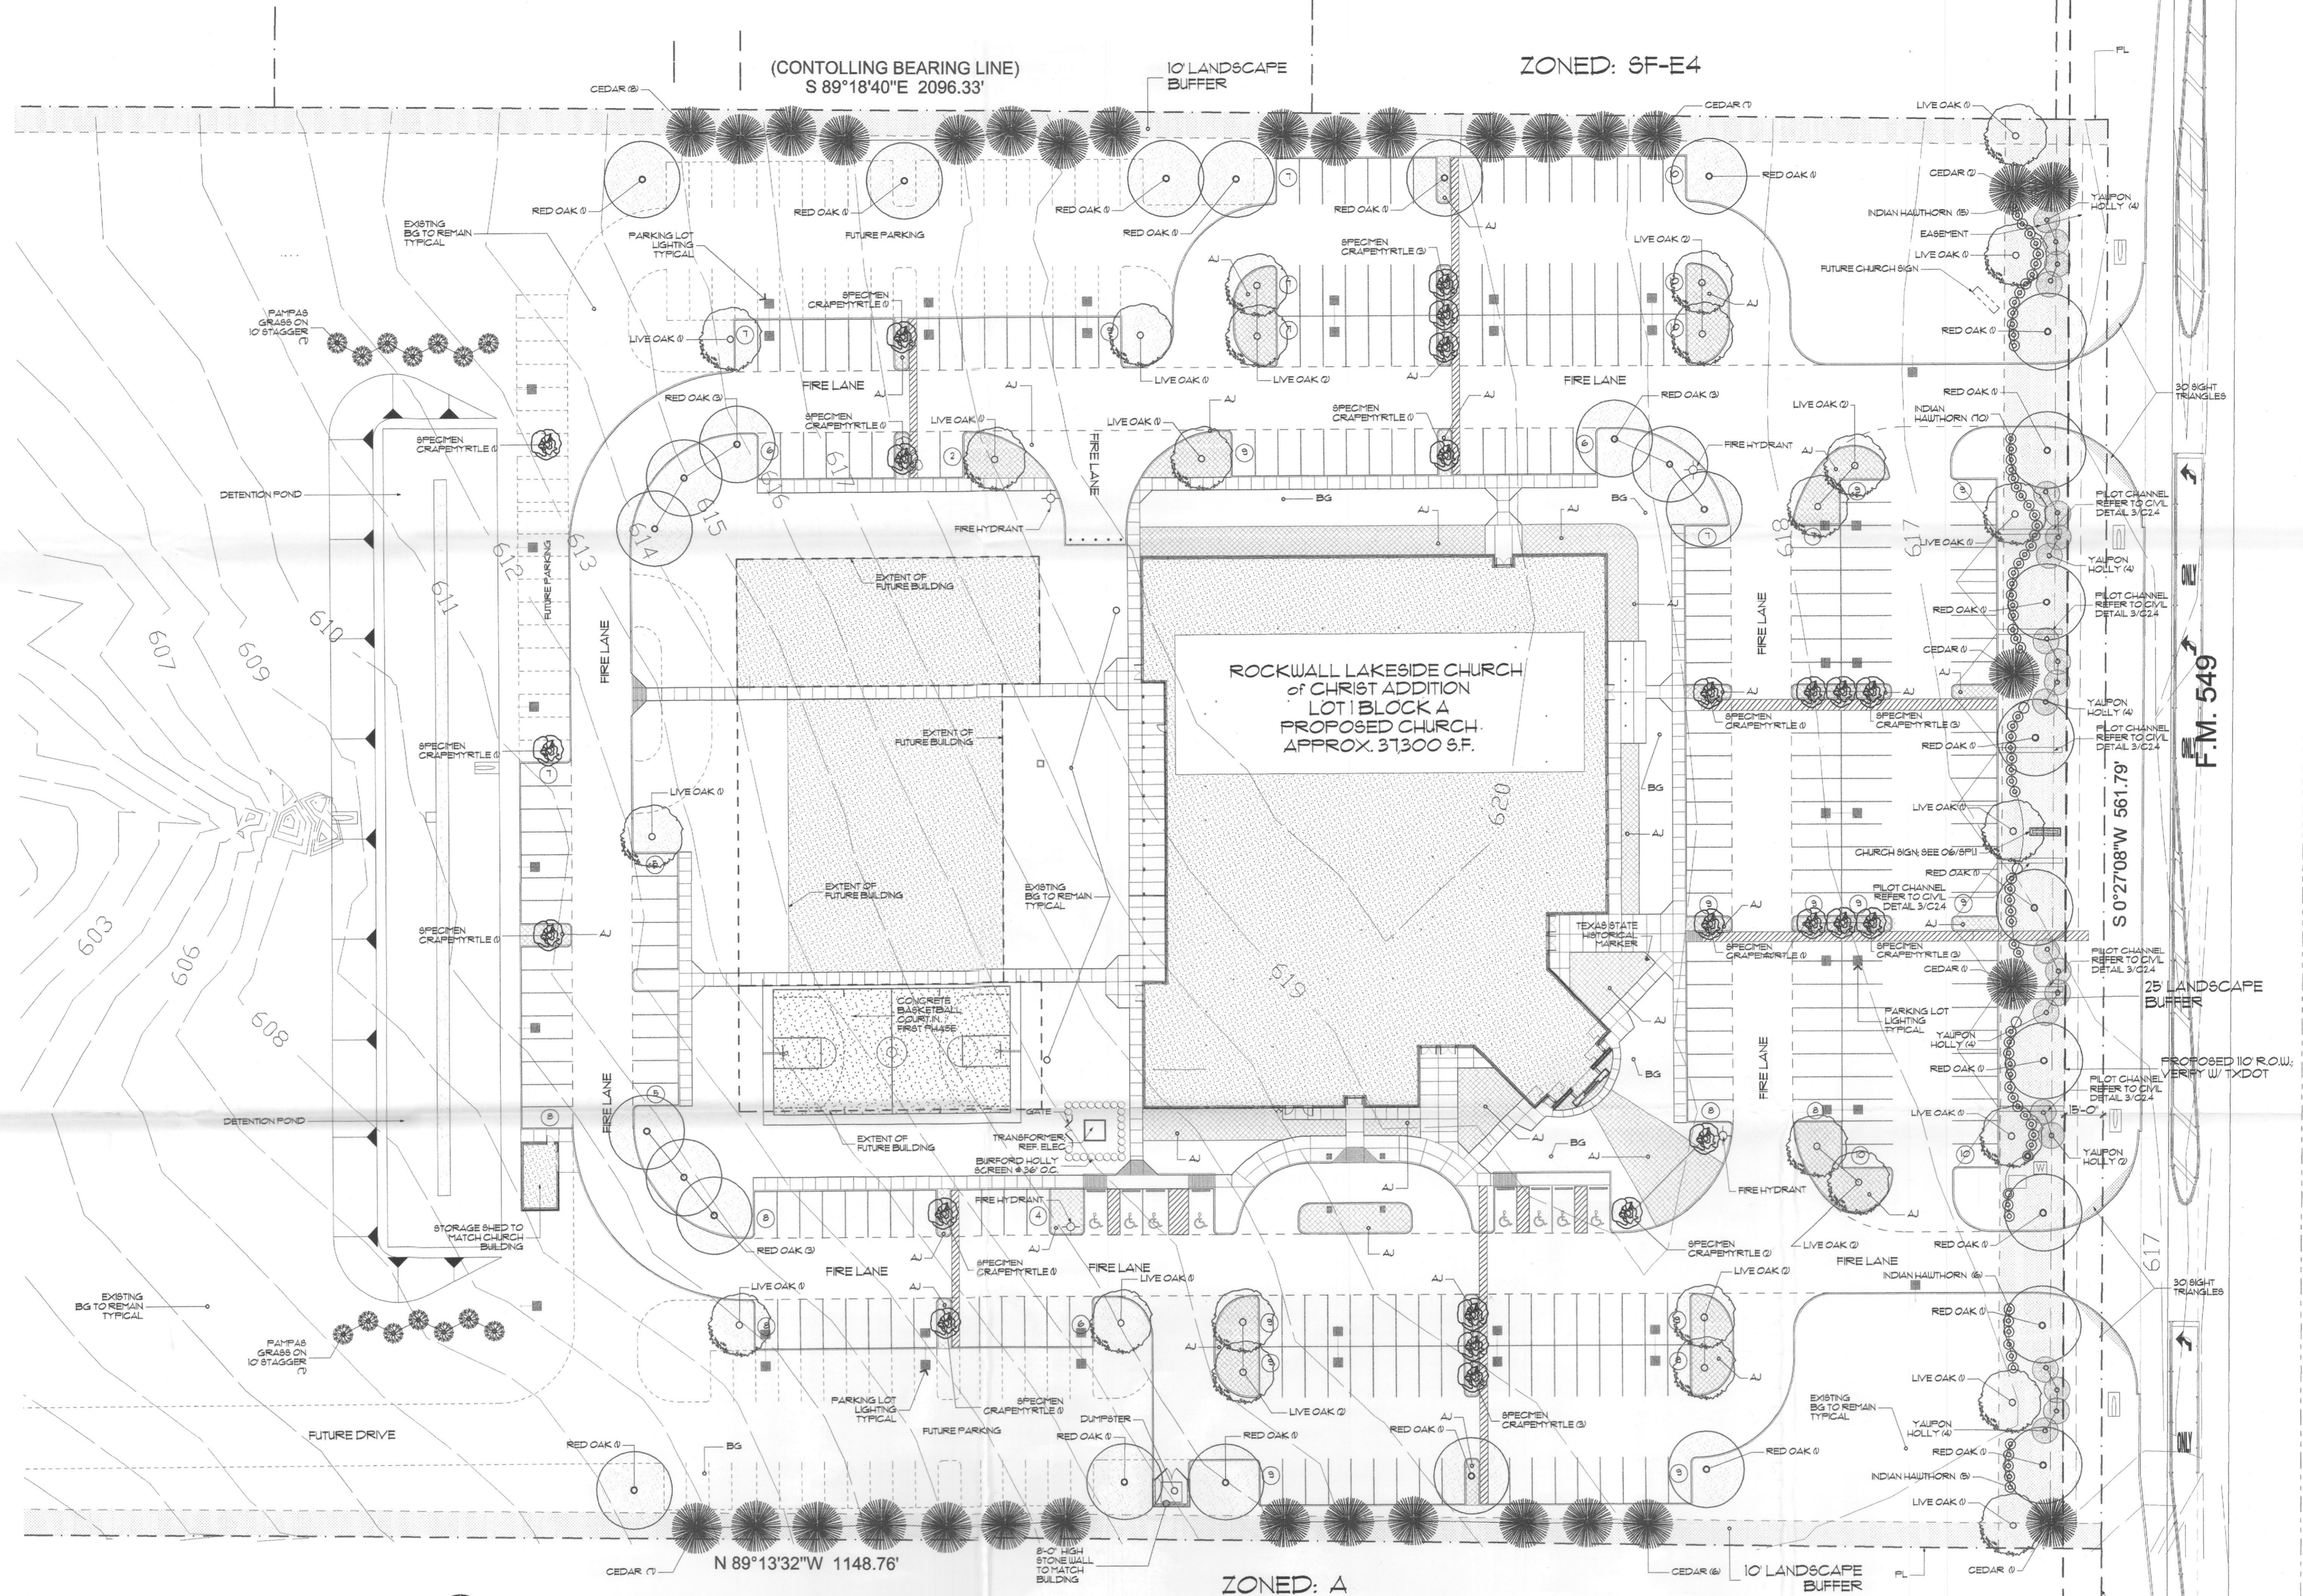

01 LANDSCAPE PLAN
Scale: 1" = 30'-0"

OWNER:
ROCKWALL LAKESIDE CHURCH OF CHRIST
485 North FM 549
Rockwall, TX 75087
Phone: (972) 711-9161

MR. BRAD HOLLAND - OWNER REPRESENTATIVE

PREPARER:
HALLUM ARCHITECTS, INC.
2501 Parkview Drive Suite 430
Fort Worth, Texas 76102
Phone: (817) 332-2422


JEFFREY HUNTER HALLUM, Assoc. AIA

EXISTING ACREAGE w/o R.O.W.: 14.555 Acres
EXISTING ACREAGE w/ R.O.W.: 15.748 Acres


BUILDING AREA: 31,000 SF 05%
PARKING AREA: 126,244 SF 20%
INTERNAL AREA: 42,600 SF 06%

LANDSCAPE TABLE			
COMMON NAME	LATIN NAME	QTY	SPACING
TREES			
LIVE OAK	Quercus virginiana	26	Ref. Plan
RED OAK	Quercus shumardii Texensis	29	Ref. Plan
CRAPENYRTLE	Lagerstroemia indica	24	
EASTERN RED CEDAR	Juniperus virginiana	33	Ref. Plan
YALPON HOLLY	Ilex vomitoria " (25% male)	22	Ref. Plan
SHRUBS			
INDIAN HAWTHORN	Raphiolepis indica 'Pinky'	88	5 Gal.
BURFORD HOLLY	Ilex cornuta 'Burfordii'	24	5 Gal.
PAMPAS GRASS	Cortaderia selloana	14	10 Gal.
GROUNDCOVER			
ASIAN JASMINE	Trachelospermum selaticum	4' C	12' o.c.s.w.
BERMUDAGRASS	Cynodon dactylon	-	8'0"
" Native			

PARKING REQUIREMENTS			
PHASE	SEATING	SPACES	H.C. SPACES (Included V.S.P)
I	897		
REQUIRED		299	7.0
PROVIDED		299	7.0
II	276		
REQUIRED		92	1 ADDITIONAL (0 ADD)
PROVIDED		94	0 ADDITIONAL (0 ADD)
TOTAL	1173		
REQUIRED		391	8.0
PROVIDED		393	8.0

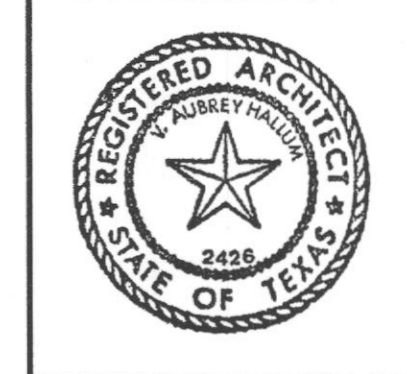


Revisions:

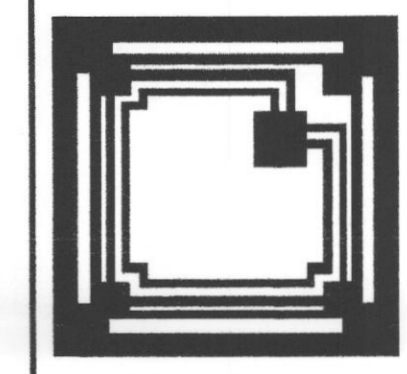


HALLUM ARCHITECTS, INC.
2501 PARKVIEW DRIVE SUITE 430
FORT WORTH, TEXAS 76102
PHONE: 817.332.2422 FAX: 817.338.1949
email: info@hallumarch.com

Rockwall Lakeside Church of Christ
New Auditorium and Education Facilities
485 North FM 549, Rockwall, Texas 75087

LANDSCAPE PLAN
Date: 5/4/2004
Scale:
Drawn:
Job: 2002-10
Sheet Number:
LP1.1

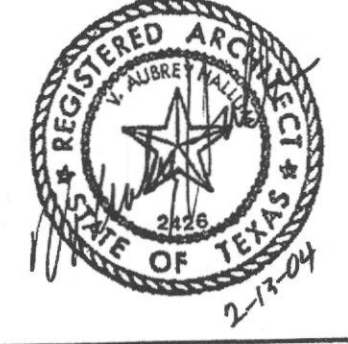

Revisions:

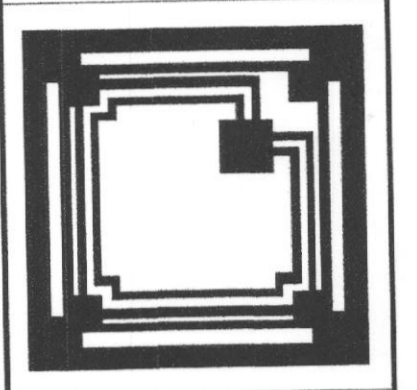


HALLUM ARCHITECTS, INC.
 2501 PARKVIEW DRIVE SUITE 430
 FORT WORTH, TEXAS 76102
 PHONE: 817.332.2422 FAX: 817.338.1949
 email: info@hallumarch.com

Rockwall Lakeside Church of Christ
 New Auditorium and Education Facilities
 485 North FM 549, Rockwall, Texas 75087

LANDSCAPE PLAN

Date: 1/15/04
 Scale:
 Drawn:
 Job: 2002-10
 Sheet Number:
P2

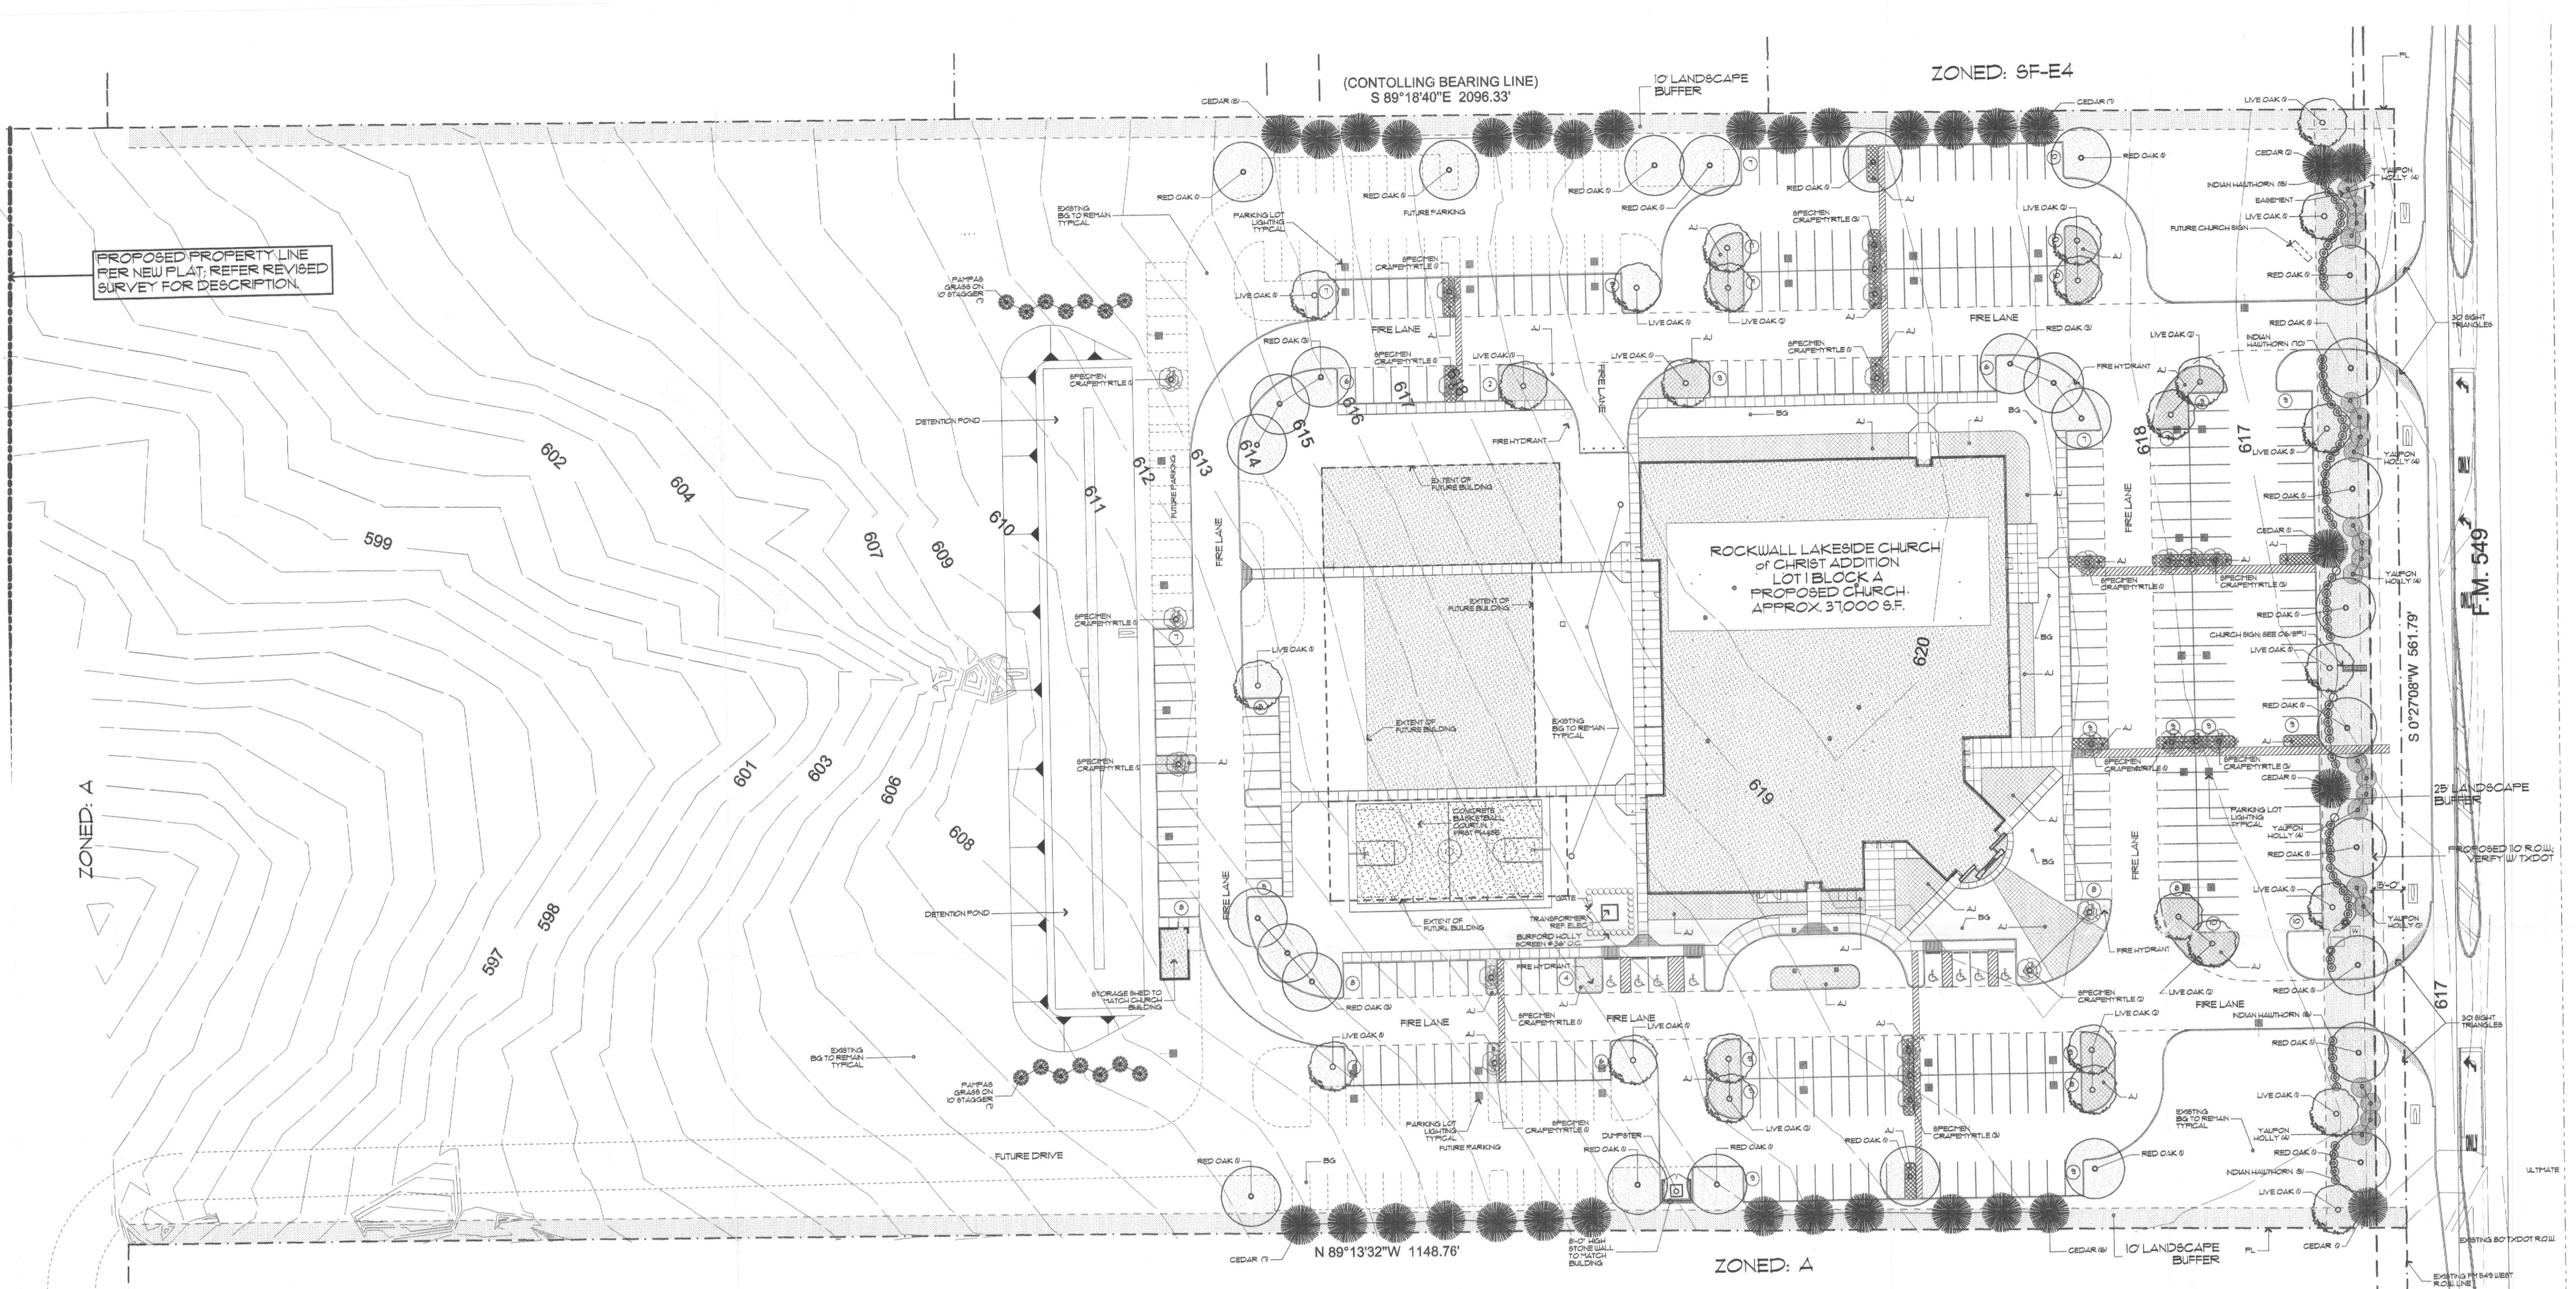

01 LANDSCAPE PLAN
 Scale: 1" = 40'-0"

OWNER:
 ROCKWALL LAKESIDE CHURCH OF CHRIST
 485 North FM 549
 Rockwall, TX 75087
 Phone: (972) 771-9161

MR. BRAD HOLLAND - OWNER REPRESENTATIVE

PREPARER:
 HALLUM ARCHITECTS, INC.
 2501 Parkview Drive Suite 430
 Fort Worth, Texas 76102
 Phone: (817) 332-2422


JEFFREY HUNTER HALLUM, Assoc. AIA

EXISTING ACREAGE w/o R.O.W.: 14.555 Acres
 EXISTING ACREAGE w/ R.O.W.: 15.748 Acres

BUILDING AREA: 31,000 SF 05%
 PARKING AREA: 126,244 SF 20%
 INTERNAL AREA: 42,600 SF 06%

LANDSCAPE TABLE			
COMMON NAME	LATIN NAME	QTY	SPACING
TREES			
LIVE OAK	Quercus virginiana	26	Ref. Plan
RED OAK	Quercus shumardii Texensis	29	Ref. Plan
CRAPENYRTLE	Lagerstroemia indica	24	
EASTERN RED CEDAR	Juniperus virginiana	33	Ref. Plan
YAUPON HOLLY	Ilex vomitoria "25% male"	22	Ref. Plan
SHRUBS			
INDIAN HAWTHORN	Raphiolepis indica 'Pinkie'	88	5 Gal.
BURFORD HOLLY	Ilex cornuta Burfordii	24	5 Gal.
PAMPAS GRASS	Cortaderia seloana	14	10 Gal.
GROUNDCOVER			
ASIAN JASMINE	Trachelospermum asiaticum	4' C	12' o.c.s.w.
BERMUDAGRASS	Cynodon dactylon	-	SOD
" Native			


PARKING REQUIREMENTS			
PHASE	SEATING	SPACES	H.C. SPACES (Included Var)
I	897		
REQUIRED		299	70
PROVIDED		299	70
II	276		
REQUIRED		92	1 ADDITIONAL (0 ADD)
PROVIDED		94	0 ADDITIONAL (0 ADD)
TOTAL	1173		
REQUIRED		391	80
PROVIDED		393	80

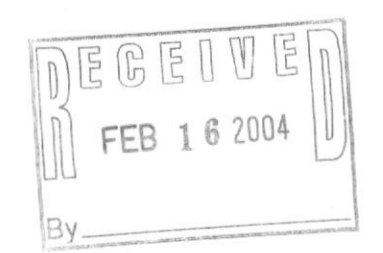

FILE COPY
 2004-001



(APPROVED SITE PLAN)
 w/ conditions

Copyright 2004 By Hallum Architects, Inc.

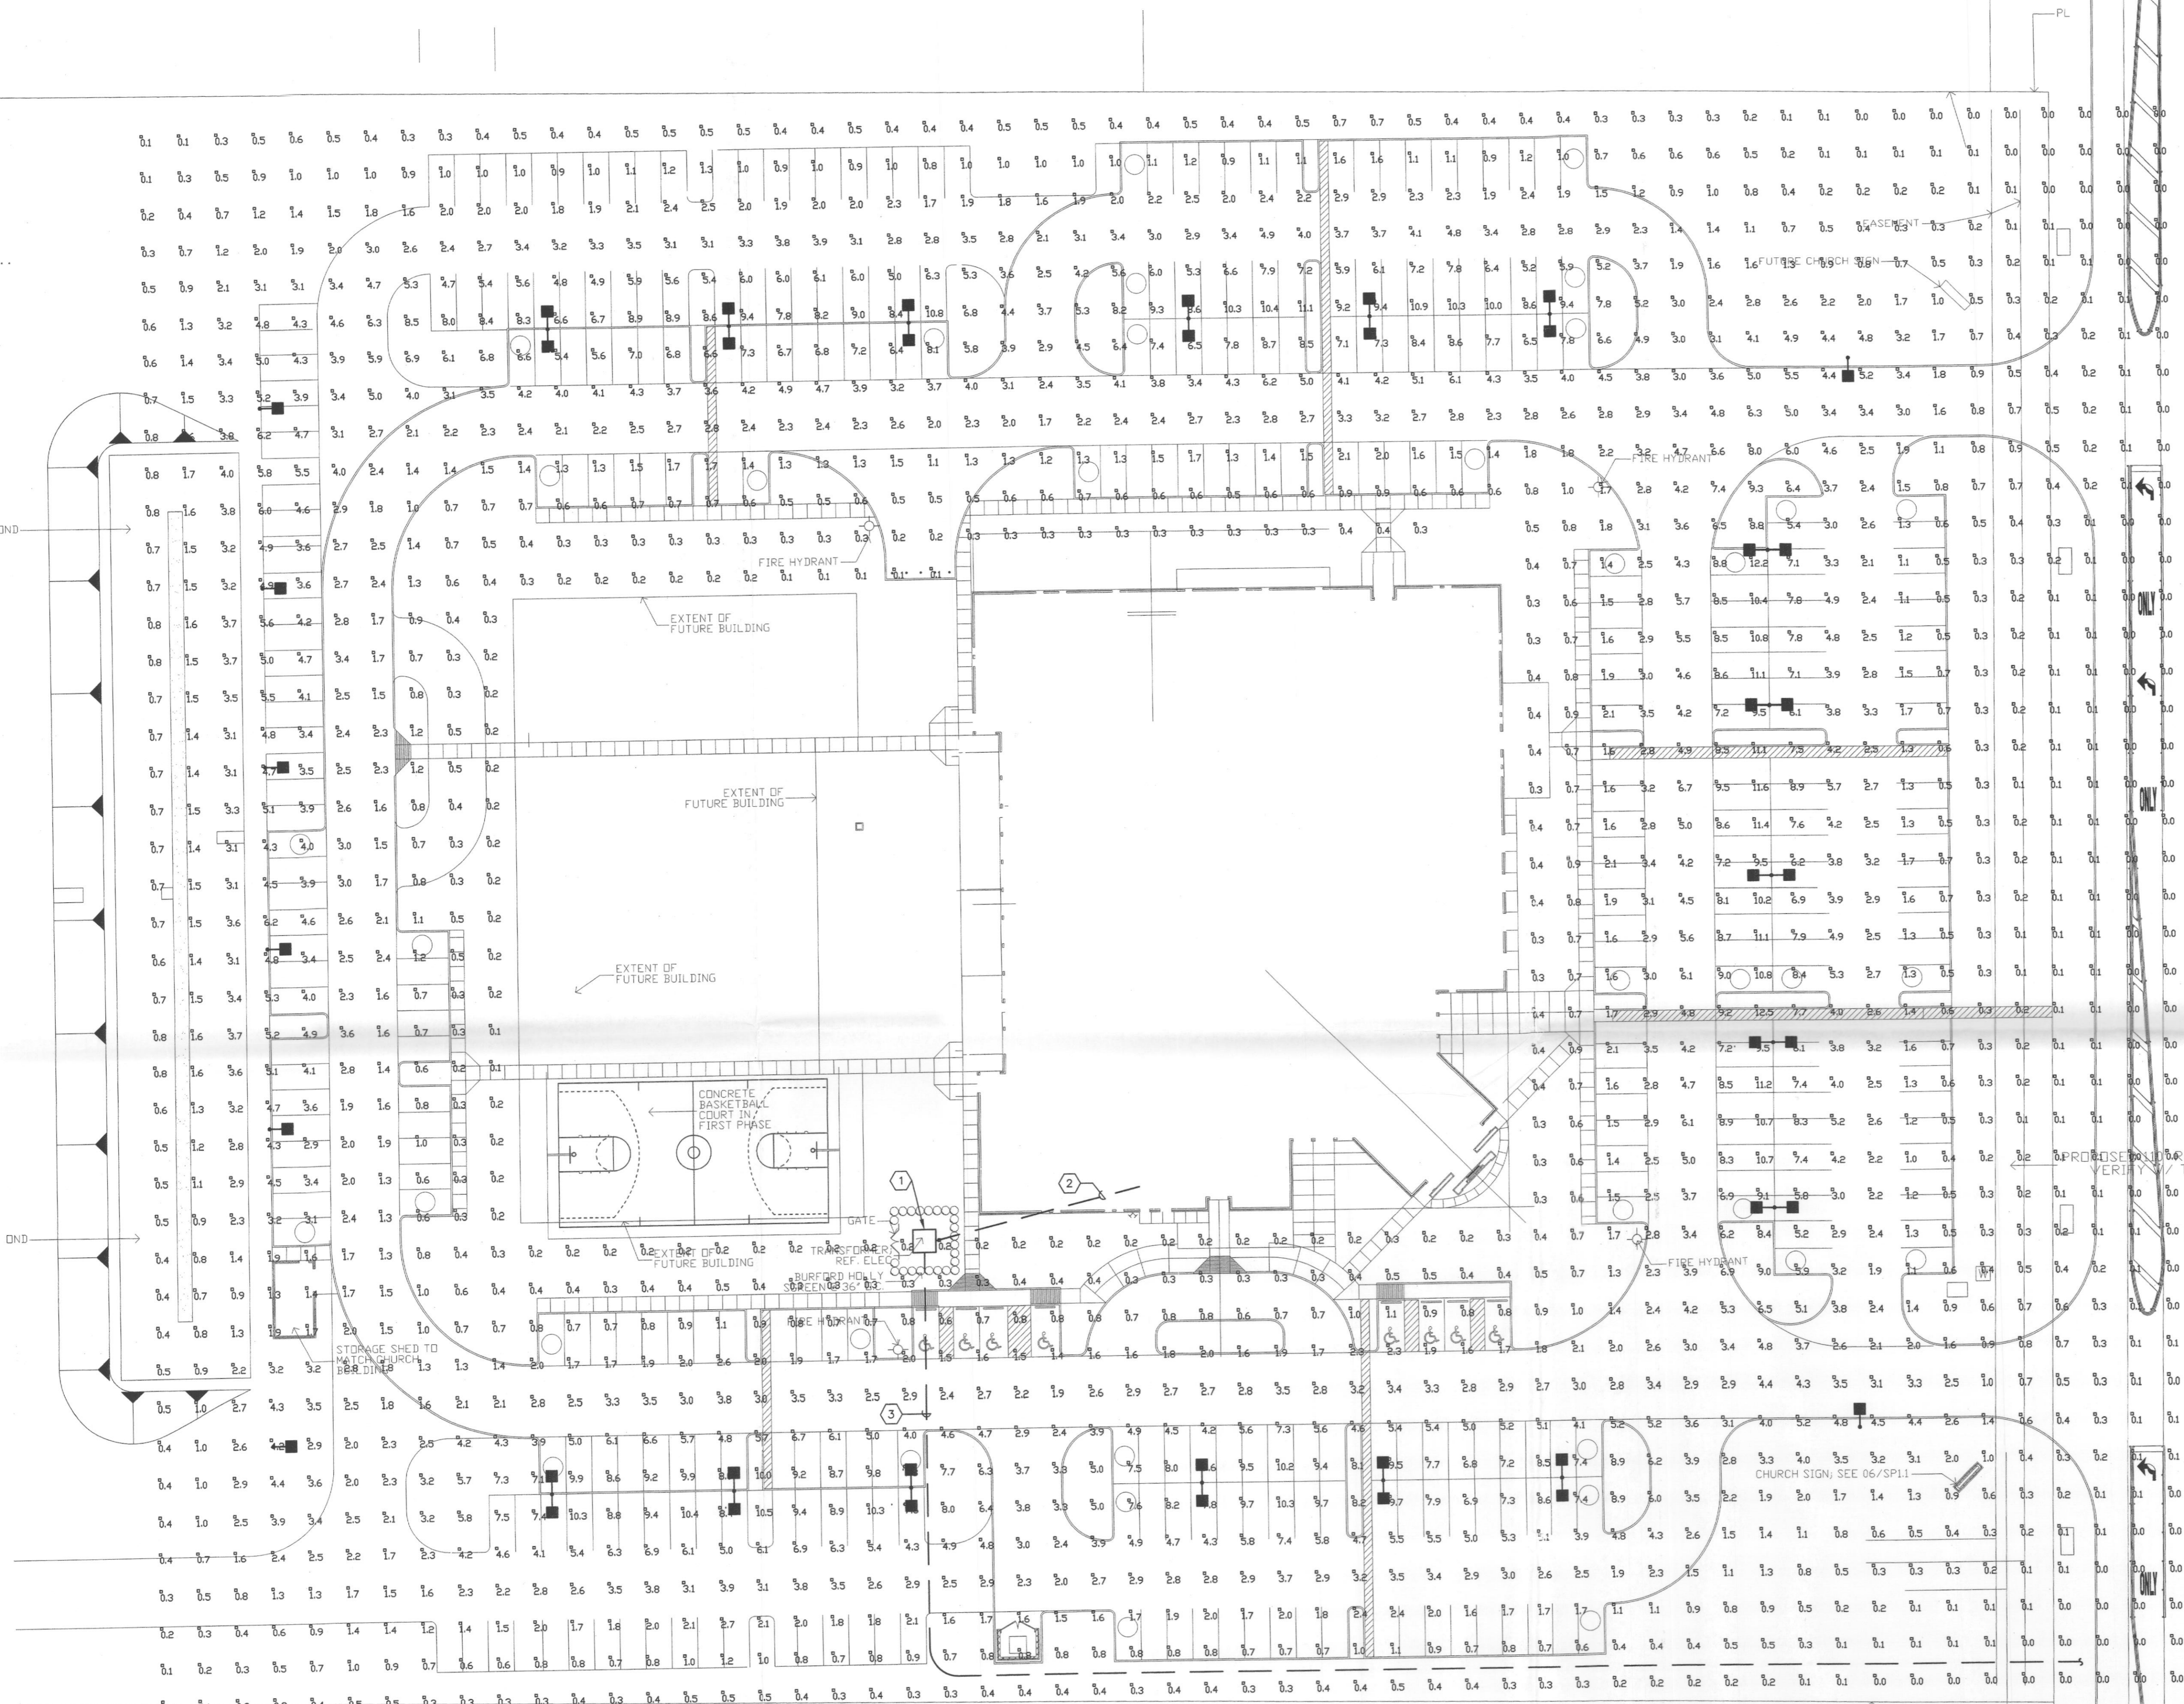

Luminaire Location Summary					
Project: All Projects					
SeqNo	Label	X	Y	Z	Orient
1	S1	724.9	97.4	27.5	90
2	S1	719	47.4	27.5	270
3	S1	170	97.6	27.5	0
4	S1	170	210.1	27.5	0
5	S1	170	272.3	27.5	0
6	S1	170	343.1	27.5	0
7	S1	170	407.9	27.5	0
8	S1	170	470.5	27.5	0
9	S2	266.1	81.7	27.5	90
10	S2	391	81.7	27.5	90
11	S2	328.7	81.7	27.5	90
12	S2	493.2	81.9	27.5	90
13	S2	552.9	81.9	27.5	90
14	S2	628.1	81.9	27.5	90
15	S2	691	172.1	27.5	0
16	S2	691	232.4	27.5	0
17	S2	691	292.4	27.5	0
18	S2	691	352.4	27.5	0
19	S2	691	412.4	27.5	0
20	S2	493.5	489.7	27.5	90
21	S2	555.6	489.7	27.5	90
22	S2	618.5	489.7	27.5	90
23	S2	394.7	489.5	27.5	90
24	S2	242.5	489.5	27.5	90
25	S2	322.9	489.5	27.5	90

- GENERAL NOTES:
- REFER TO SHEET E101 FOR RELAY PANEL "RP" SCHEDULE.
 - REFER TO SHEET E301 FOR RISER DIAGRAM AND PANELBOARD SCHEDULES.
 - REFER TO SHEET E302 FOR ELECTRICAL SYMBOLS.
- NOTES BY SYMBOL: "◇" "◇"
- NEW UTILITY COMPANY TRANSFORMER AND METER BY UTILITY COMPANY.
 - TRANSFORMER SECONDARY TO PANEL "MDP", REFER TO RISER DIAGRAM FOR ADDITIONAL INFORMATION.
 - TWO 4" CONDUITS PER UTILITY COMPANY SPECIFICATIONS.
 - INSTALL POLE BASE PER POLE BASE DETAIL THIS SHEET - TYPICAL.

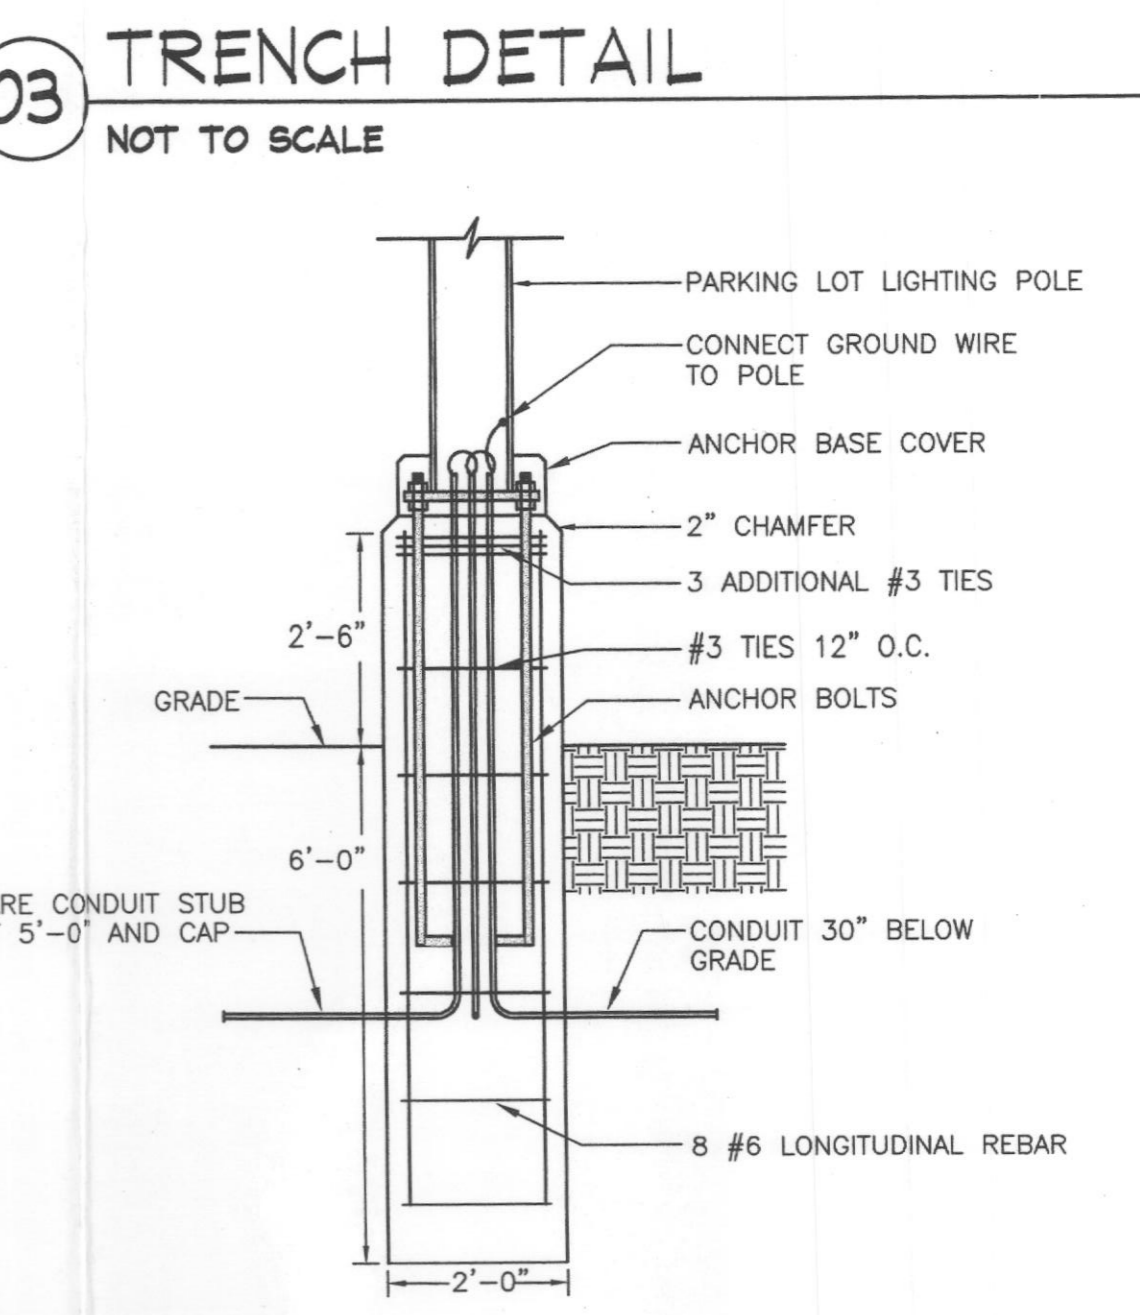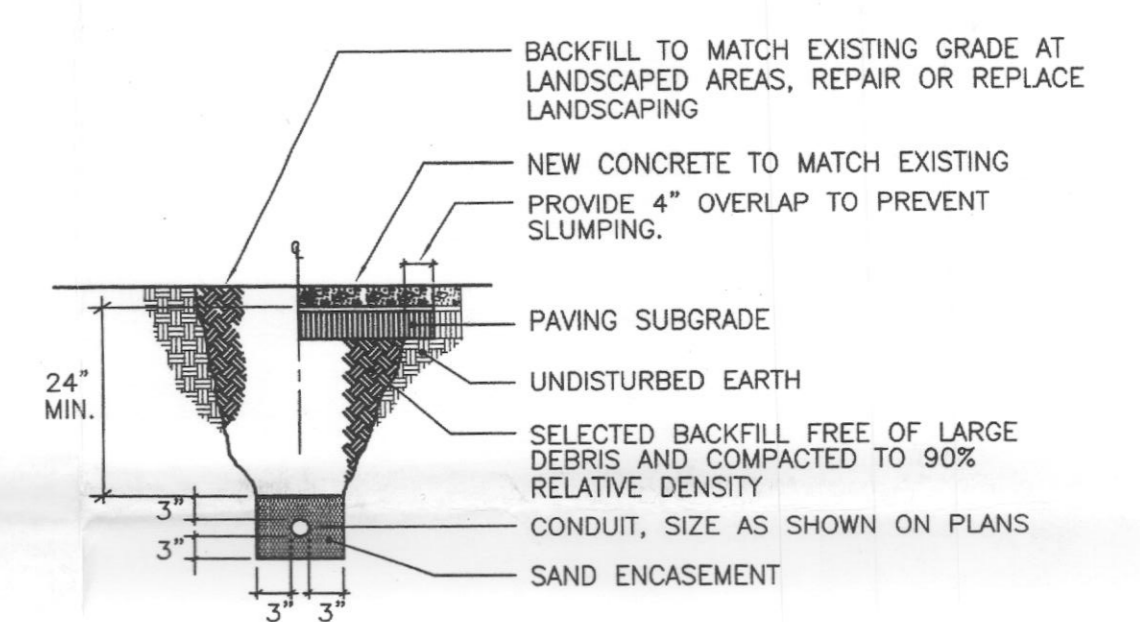

LIGHTING FIXTURE SCHEDULE		
TYPE	DESCRIPTION	LAMPS
S1	SITE LIGHT, 400W METAL HALIDE, DIE-CAST ALUMINUM HOUSING, TYPE III DISTRIBUTION, BRONZE FINISH, LISTED FOR WET LOCATION, FULL CUTOFF, DARK SKY COMPLIANT, 277V, INVUE #AEM-400-MH-277-3S-BZ WITH 6 1/2" ARM, #VA1055. INSTALL ON 15' SQUARE STRAIGHT POLE, COOPER LIGHTING #SSX4A15SBZ2, NUMBER OF ARMS PER PLAN.	ONE 400 WATT MH


NOTES:
1.

Luminaire Schedule						
Project: All Projects						
Symbol	Qty	Label	Arrangement	Lumens	LLF	Description
⊞	17	S2	BACK-BACK	36000	0.750	AEM-400-MH-XX-3S
⊞	8	S1	SINGLE	36000	0.750	AEM-400-MH-XX-3S

Numeric Summary									
Project: All Projects									
Label	CalcType	Units	Avg	Max	Min	Avg/Min	Max/Min	PtSpC/Lr	PtSpC/Tb
Entire Site	Illuminance	Fc	2.42	12.5	0.0	0.00	0.00	13	13

THIS DOCUMENT IS RELEASED FOR THE PURPOSE OF INTERIM REVIEW UNDER THE AUTHORITY OF MERLIN HAMPTON, P.E., 38418 ON 02-04-04. IT IS NOT TO BE USED FOR CONSTRUCTION, BIDDING, OR PERMIT PURPOSES.

Bald, Hampton & Brown, Inc.
Engineering & Surveying
308 W. 7th St., Ste. 500 Ft. Worth, TX 76102 Tel (817)338-1277 Fax (817)338-9245 E-Mail: mhb@bhbinc.com

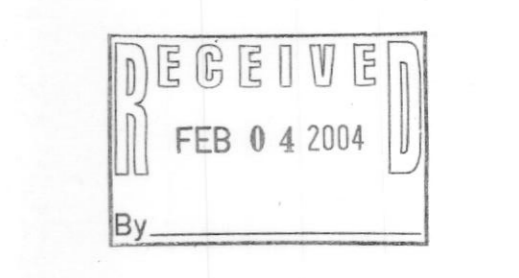

2004-001
Copyright 2004 By Hallum Architects, Inc.

HALLUM ARCHITECTS, INC.
2501 PARKVIEW DRIVE SUITE 430
FORT WORTH, TEXAS 76102
PHONE: 817.332.2422 FAX: 817.338.1949
email: info@hallumarch.com

Rockwall Lakeside Church of Christ
New Auditorium and Education Facilities
485 North FM 549, Rockwall, Texas 75087

SITE PHOTOMETRICS

Date: 2-04-2004
Scale: 1" = 30'-0"
Drawn: SG
Job: 2002-10
Sheet Number: **E001**

FILE COPY (APPROVED SITE PLAN)