


Ridge Road

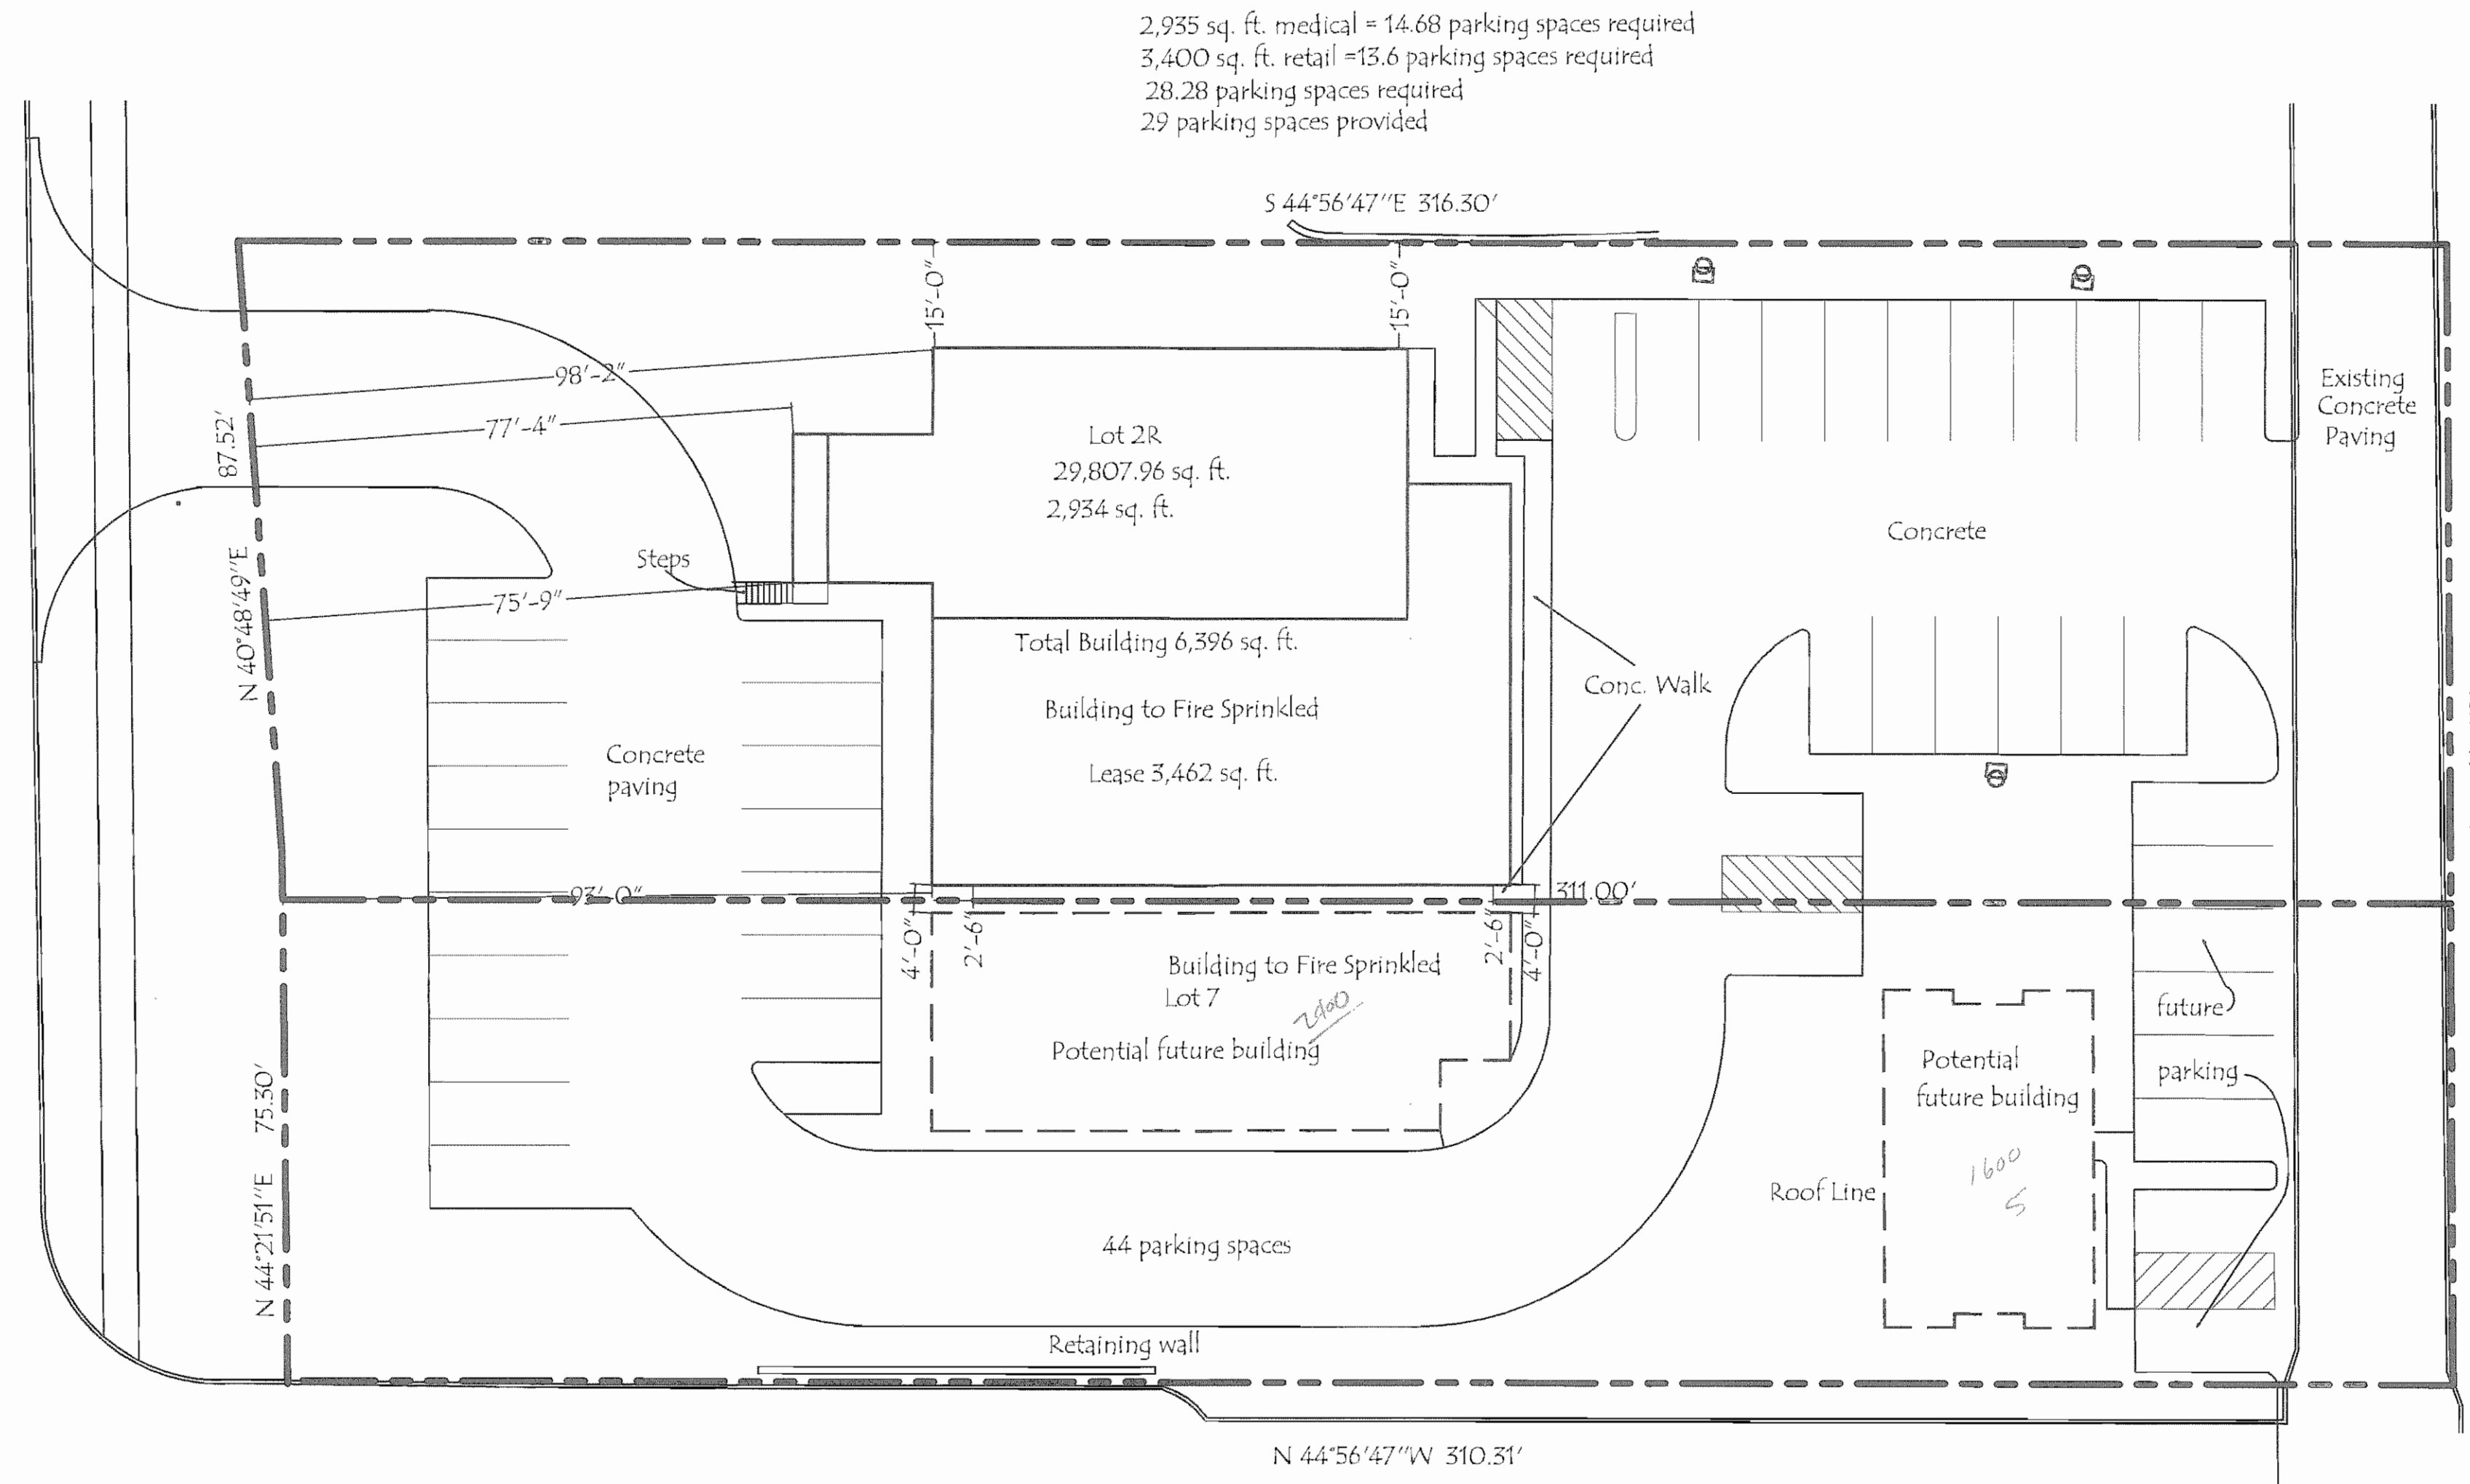

2,935 sq. ft. medical = 14.68 parking spaces required
 3,400 sq. ft. retail = 13.6 parking spaces required
 28.28 parking spaces required
 29 parking spaces provided


Site Plan

SCALE 1" = 20'

FILE COPY


2004-013

RECEIVED
 AUG 04 2004
 By _____

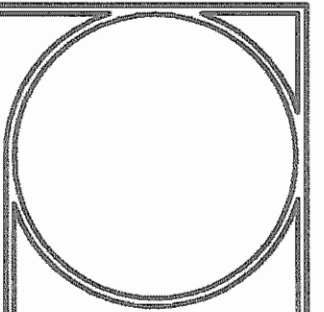

**RAMSAY
 IVY COMPANY, LC**

2235 RIDGE ROAD, SUITE 104
 ROCKWALL, TEXAS 75087
 PH: 972.771.1030

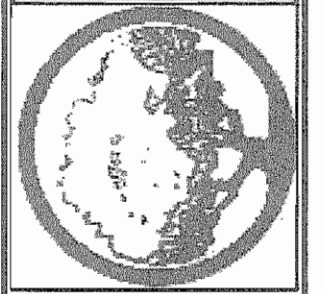

Apple Orthodontix

2245 Ridge Road
 Rockwall Texas

DATE
 August 3, 2004
 PROJECT
 0303

A2




**RAMSAY
IVY COMPANY, LC**
ROCKWALL, TEXAS 75087
2255 RIDGE ROAD, SUITE 104
PH: 972.771.1050


Apple Orthodontix
2245 Ridge Road
Rockwall, Texas

DATE
Sep. 7, 2005
PROJECT
0303


A2

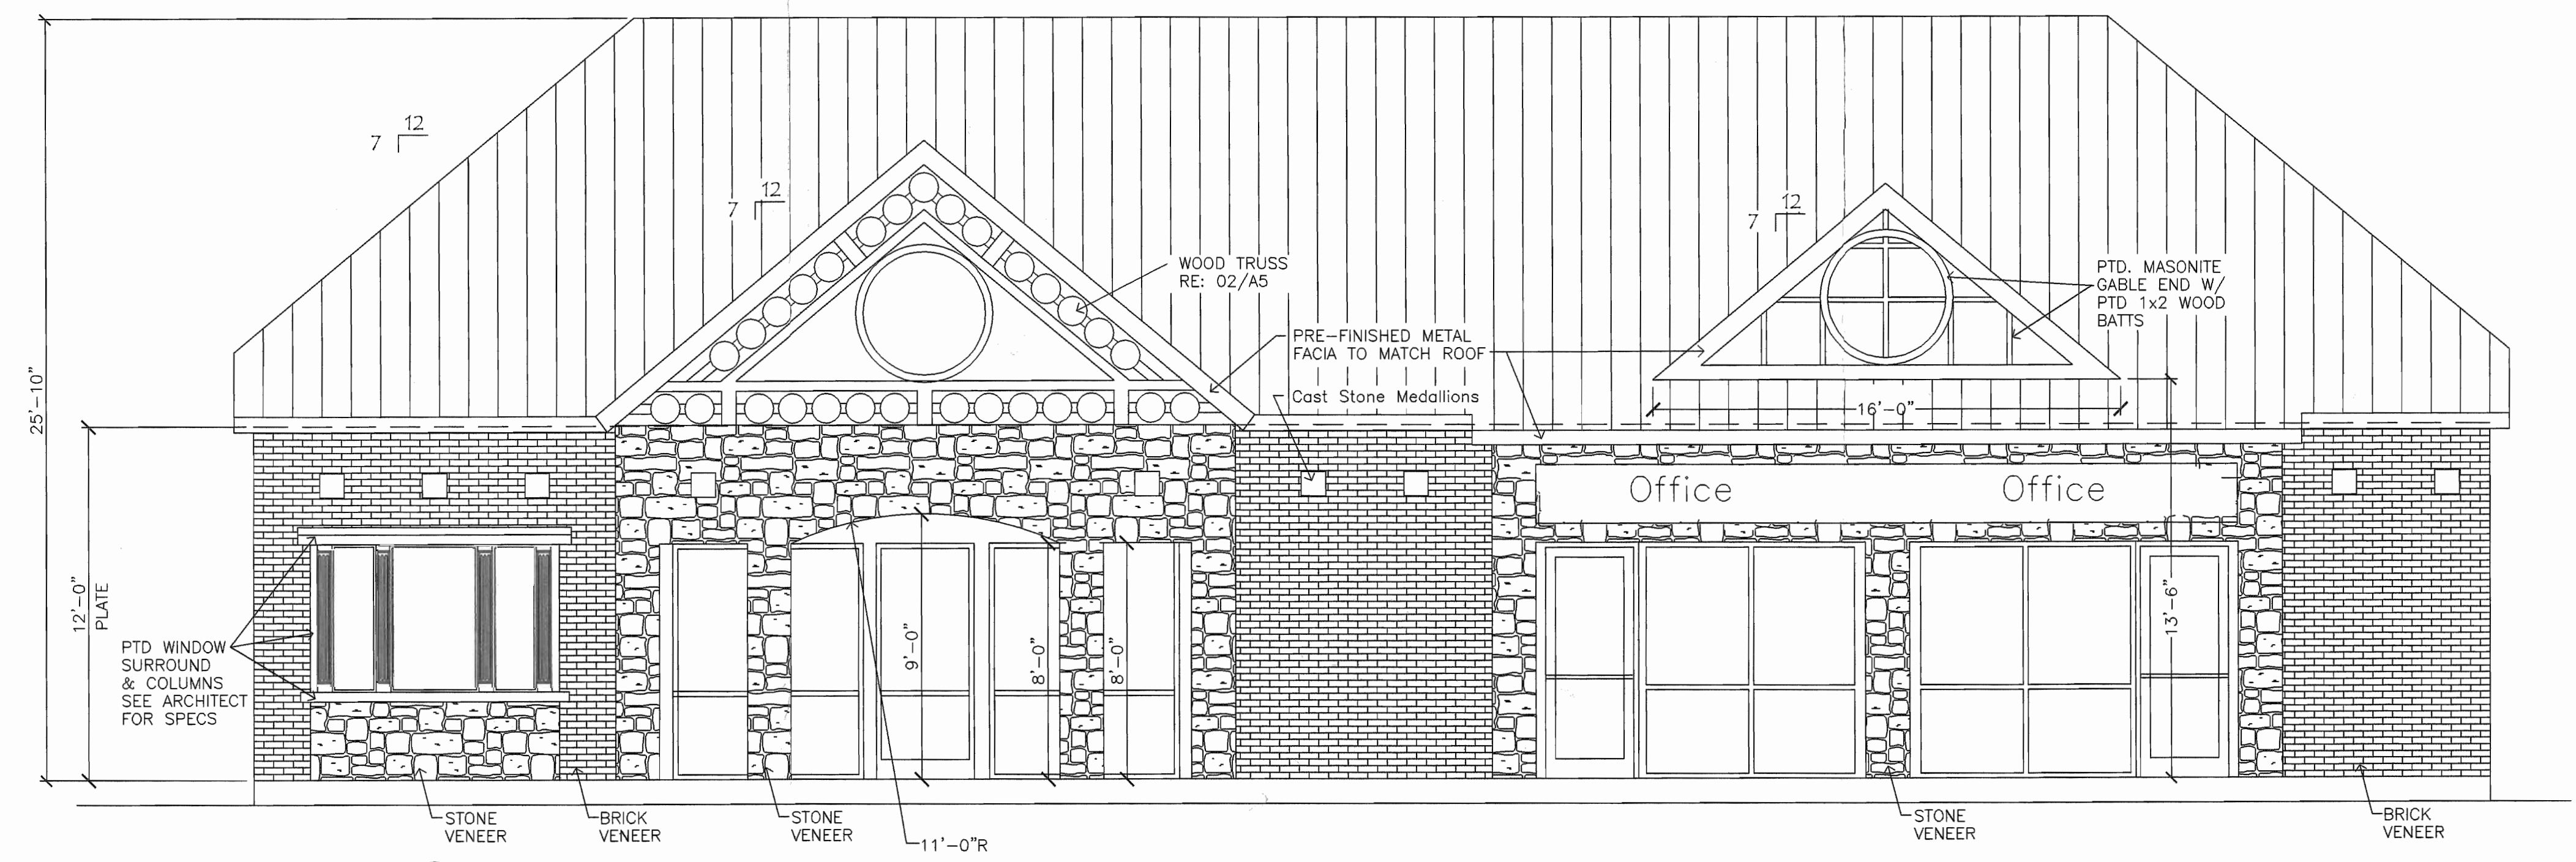


01 FRONT ELEVATION
SCALE: 1/4" = 1'-0"

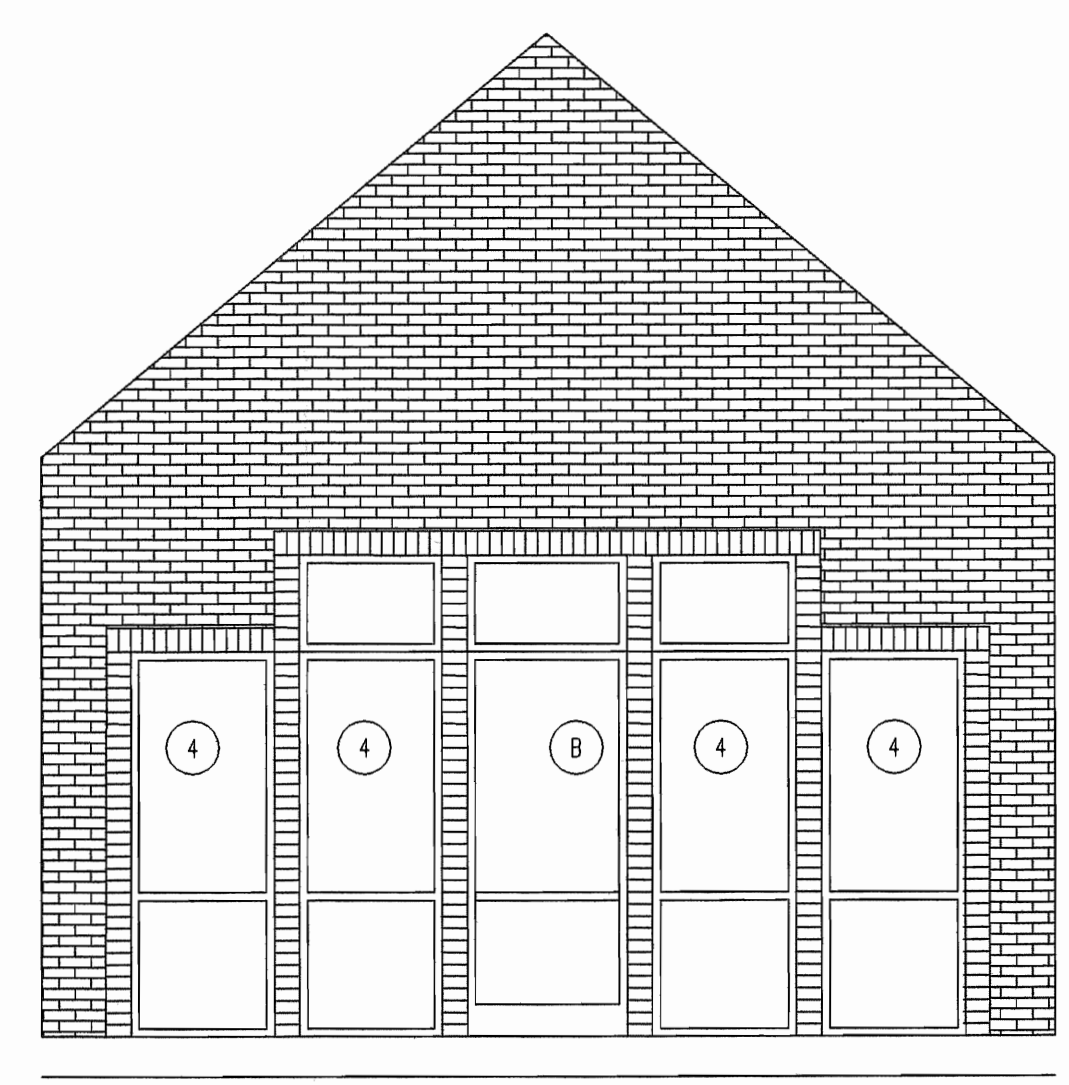


04 PORCH ELEVATION
SCALE: 1/4" = 1'-0"

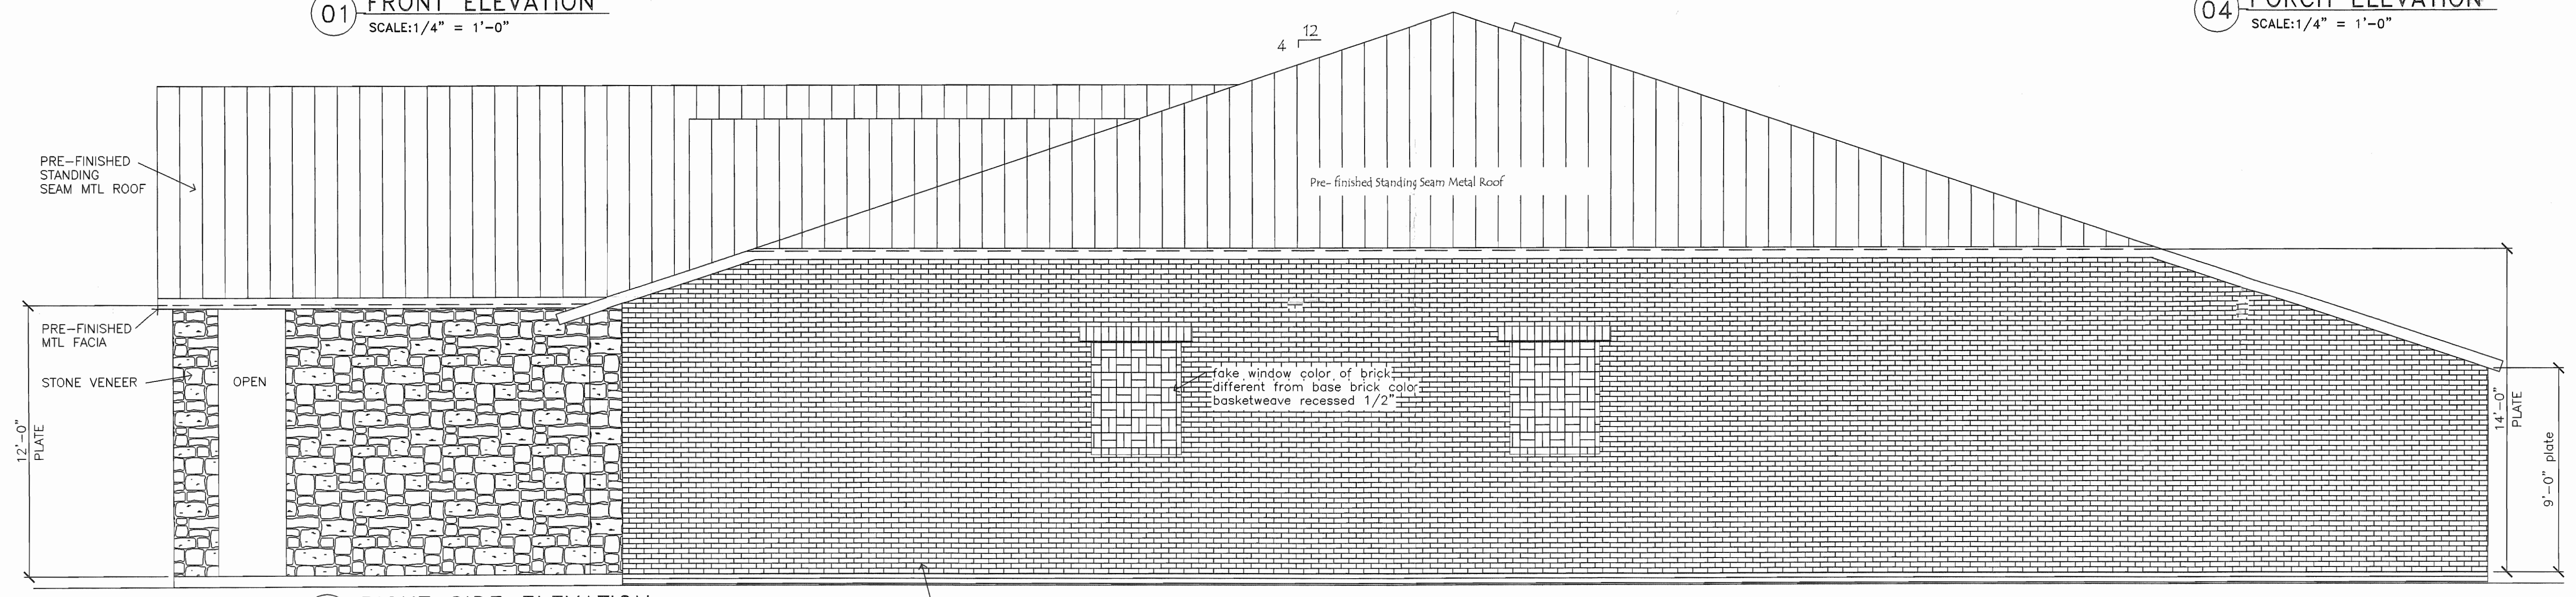


02 RIGHT SIDE ELEVATION
SCALE: 1/4" = 1'-0"

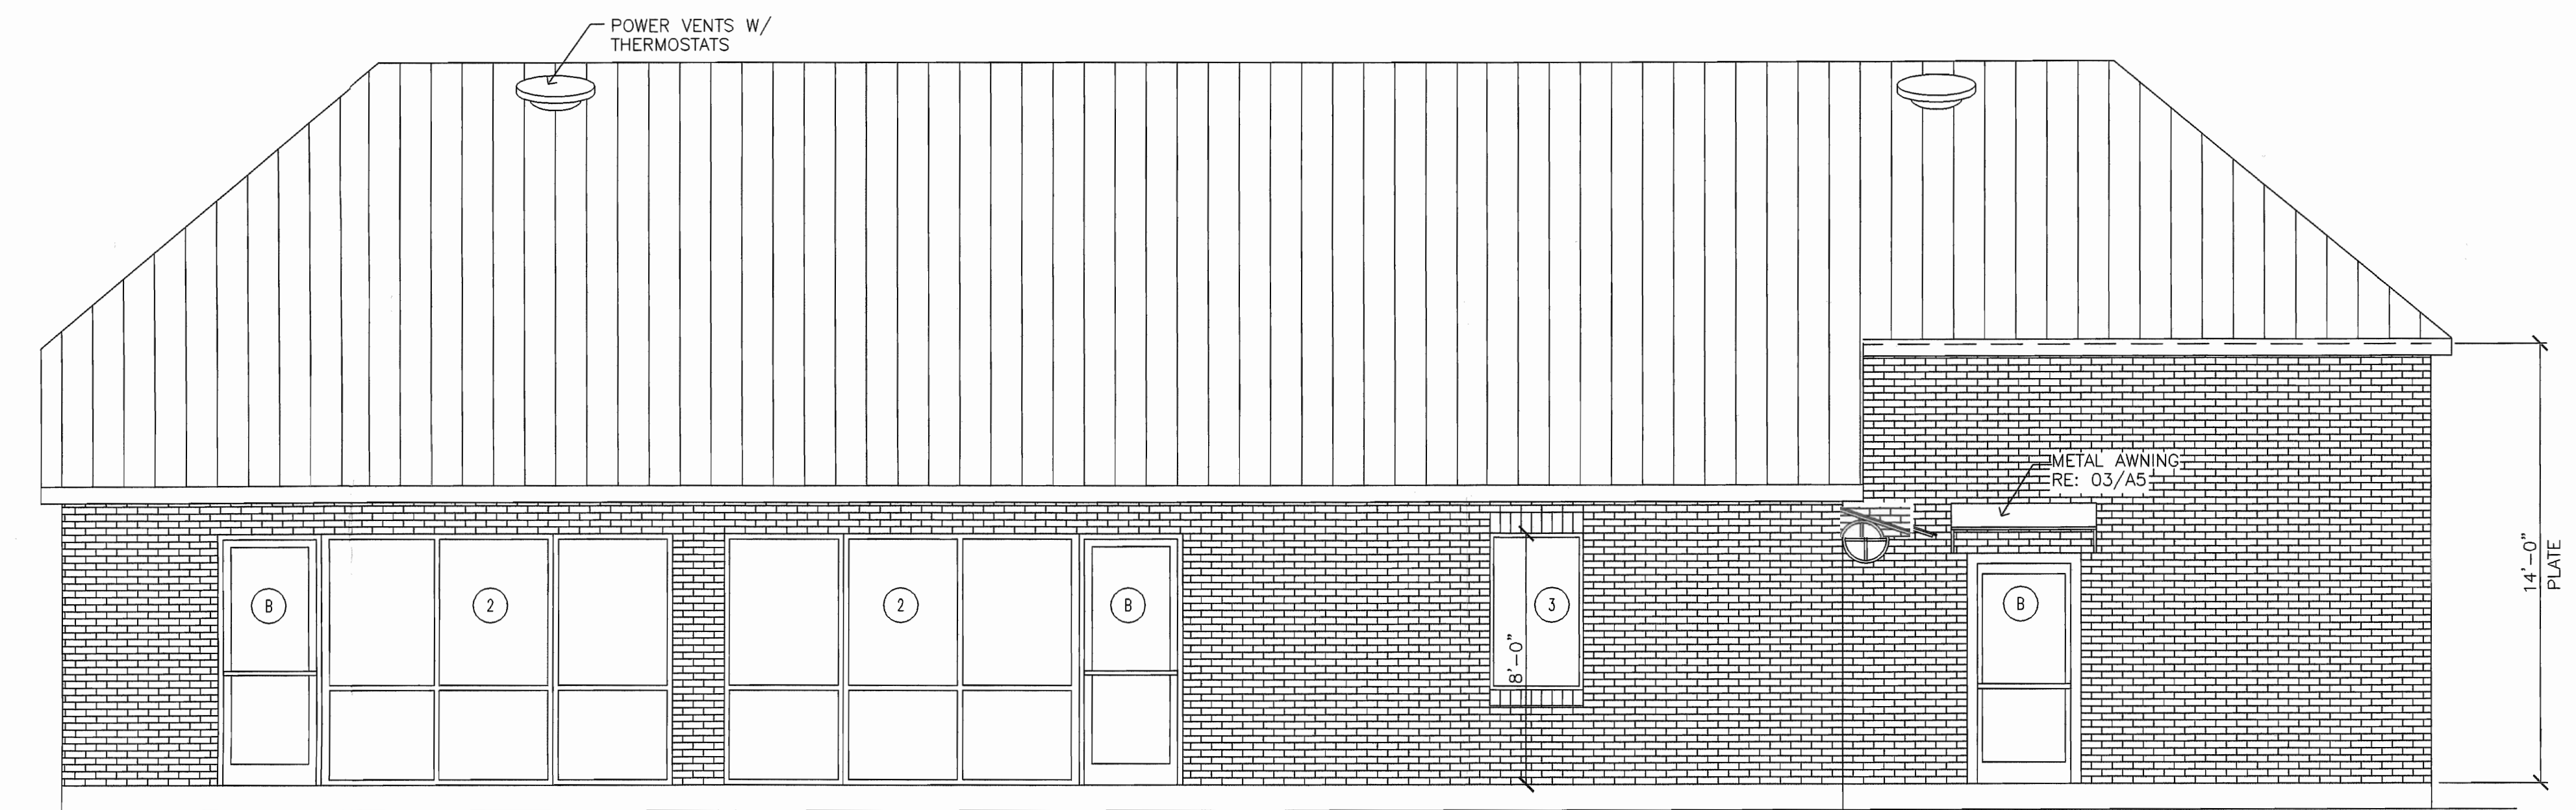

03 REAR ELEVATION
SCALE: 1/4" = 1'-0"

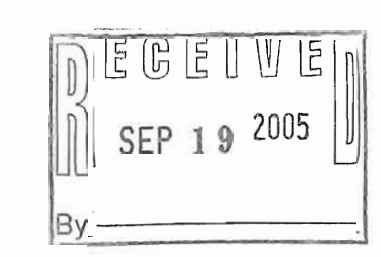


Total Square footage: 29,807
 Landscape square footage: 7,544
 Percentage of Landscape coverage: 25.4
 Percentage of landscaping required: 15%
 2 - 3" Cedar elm provided
 1 - 2" little gem magnolia provided
 2 - 2" Red Oak provided
 1 - 3" Southern magnolia provided

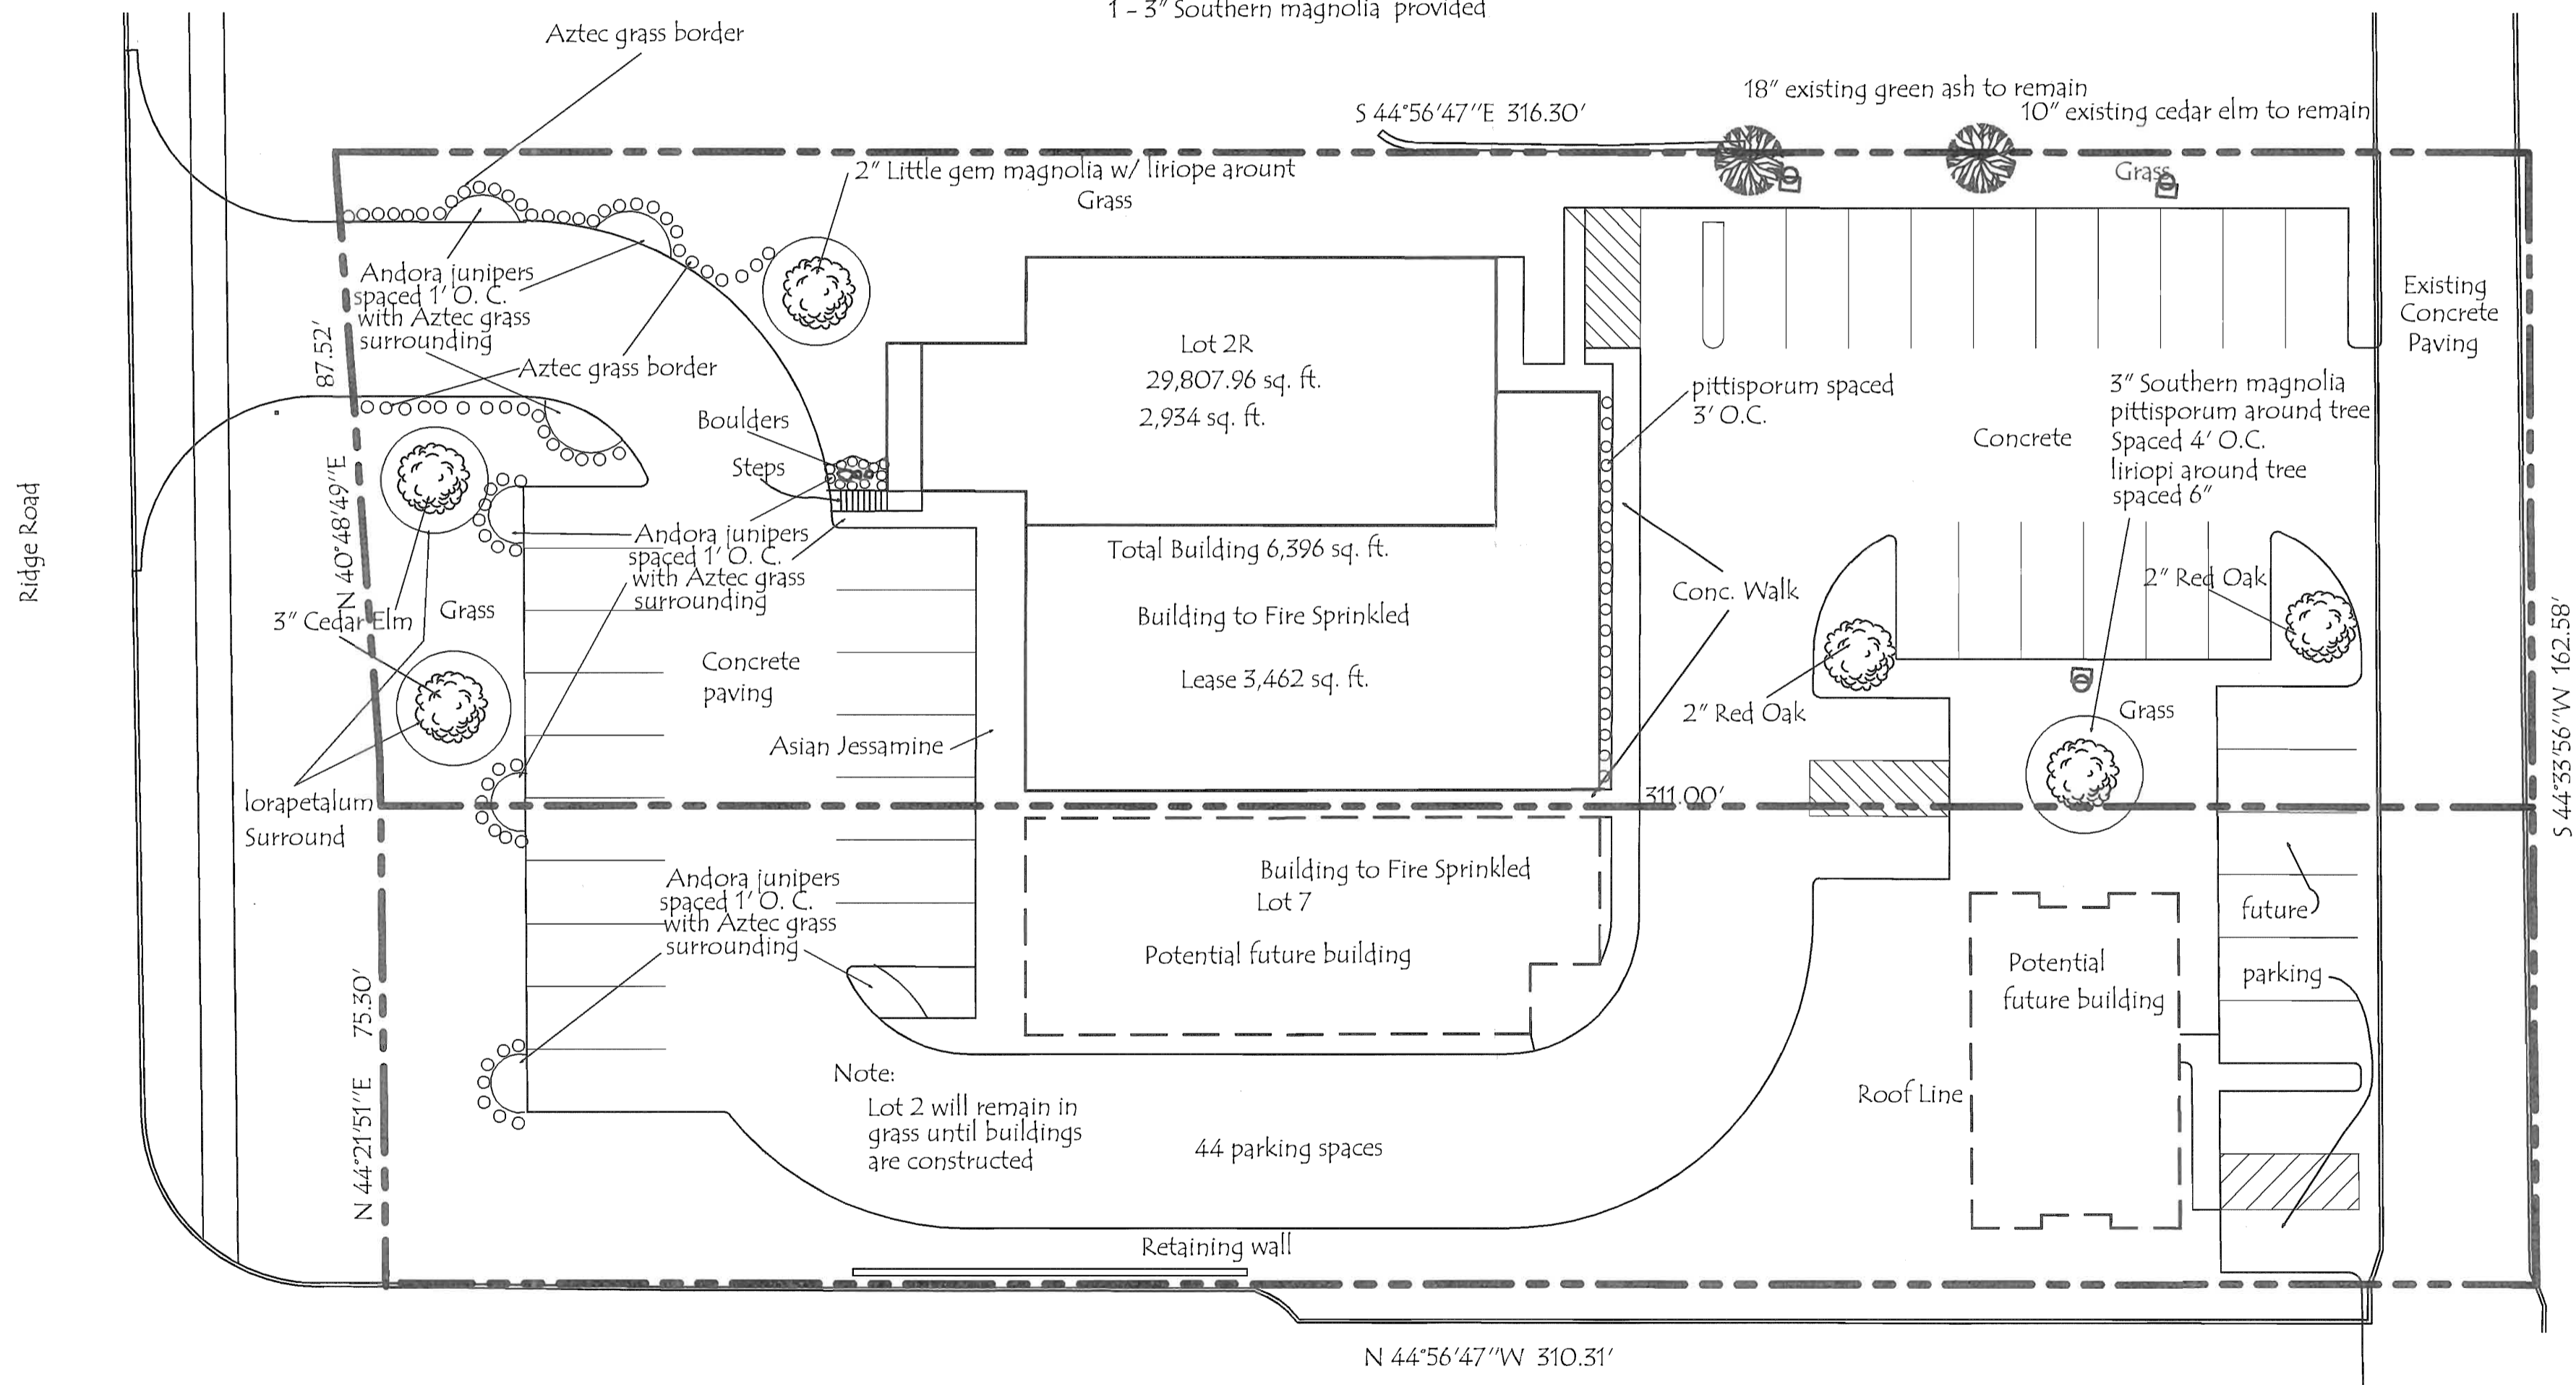

Landscape Plan

SCALE 1" = 20'

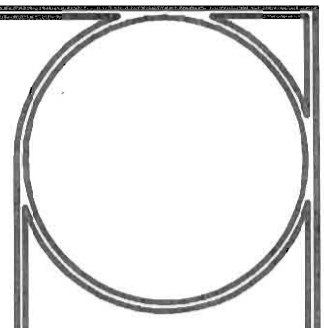


**RAMSAY
 IVY COMPANY, LC**
 2235 RIDGE ROAD, SUITE 104
 ROCKWALL, TEXAS 75087
 PH: 972.771.1030



Apple Orthodontix
 2245 Ridge Road
 Rockwall Texas

DATE
 August 3, 2004
 PROJECT
 0303
A2

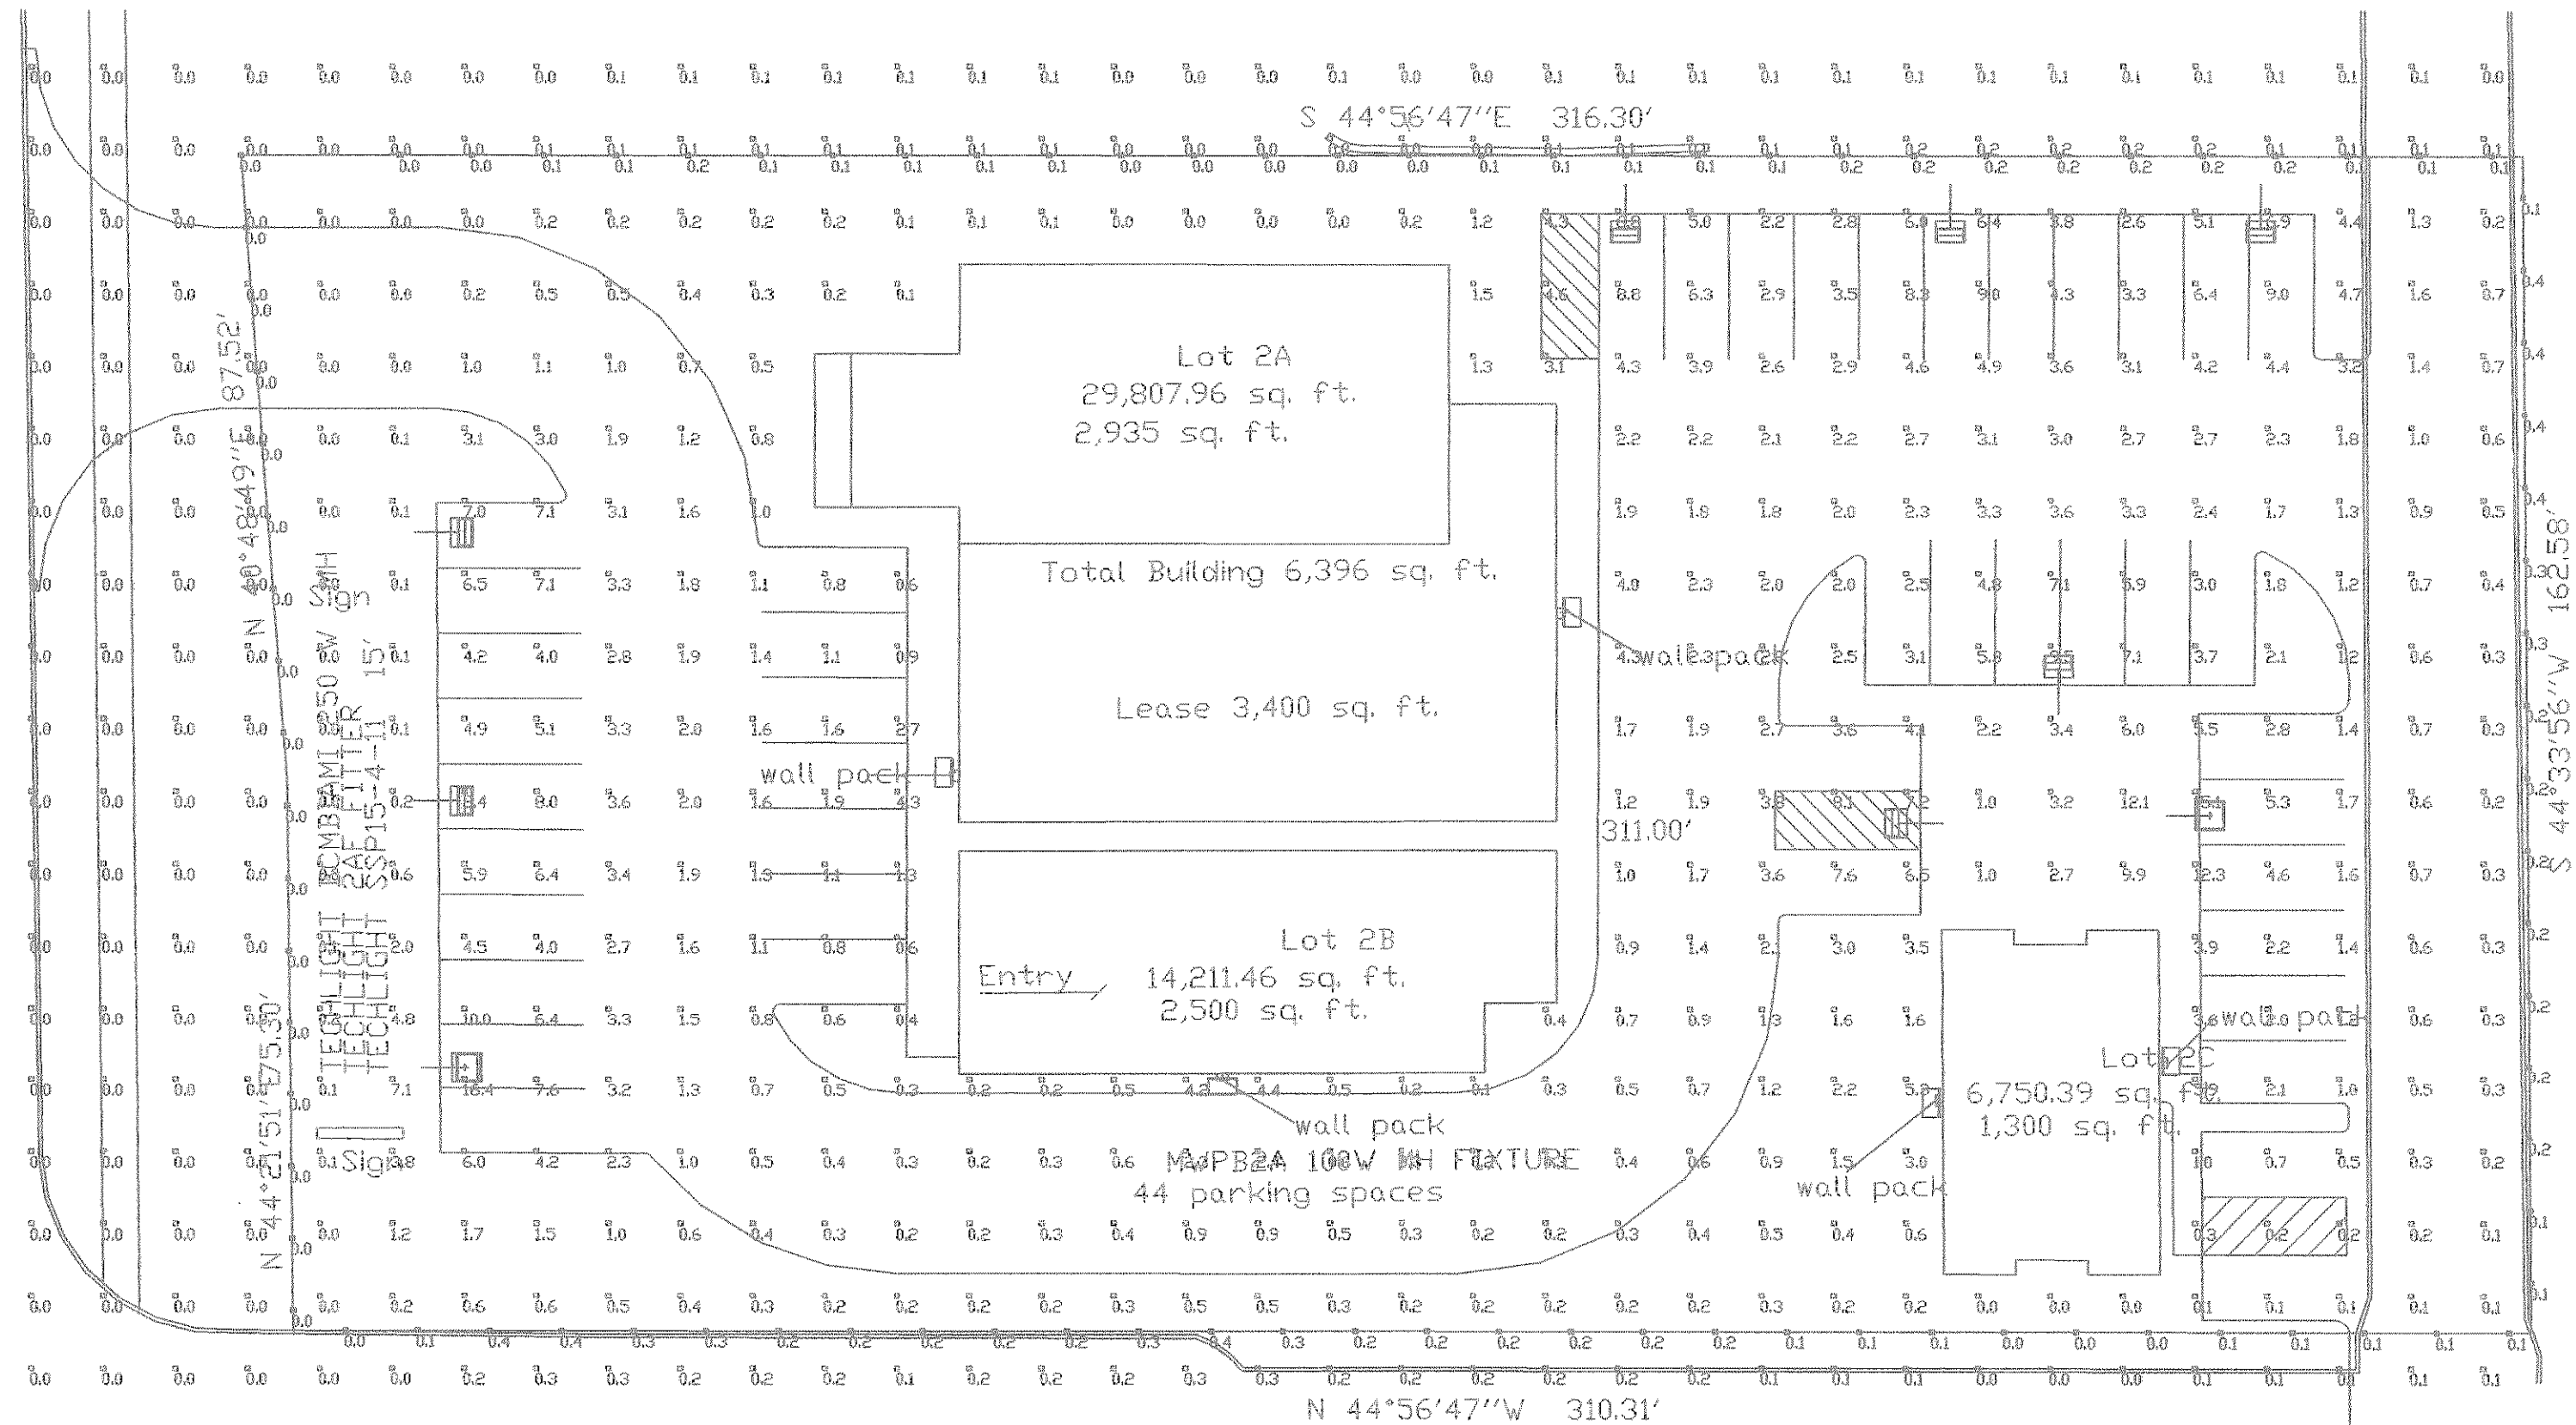

Numeric Summary							
Project: All Projects							
Label	CalcType	Units	Avg	Max	Min	Avg/Min	Max/Min
SITE AREA	Illuminance	Fc	1.51	16.4	0.0	0.00	0.00
PROPERTY LINES	Illuminance	Fc	0.13	0.4	0.0	0.00	0.00

Luminaire Schedule						
Project: All Projects						
Symbol	Qty	Label	Arrangement	Lumens	LLF	Description
	9	F	SINGLE	20000	0.760	DCMBIAMI - 250W MH FLOOD
	5	W	SINGLE	9000	0.760	MWPB2A - 100W MH WALL PACK

Luminaire Location Summary					
Project: All Projects					
Label	X	Y	Z	Orient	Tilt
F	-12	385	17	0	60
F	216	369	17	90	60
F	200	345	17	180	60
F	156	433	17	270	60
W	100	310	10	270	0
W	63	352	10	180	0
W	147	374	10	0	0
W	200	306	10	180	0
W	230	312	10	0	0
F	201	433	17	270	60
F	231	346	17	0	0
F	244	433	17	270	60
F	-12	348	17	0	60
F	-11	311	17	0	30

TECHLIGHT
2707 SATSUMA
DALLAS, TEXAS 75229

APPLE ORTHODONTIX

FILE:
RAMSAY.A32

6-18-04

PARKING LIGHTING

POLARIS SERIES

HOUSING

The fixture housing is constructed of formed aluminum. All seams are welded and siliconed for a weather tight seal. Top cap for convenient maintenance and easy access.

DOOR FRAME


Door frame is fabricated from a single piece of aluminum. A silicone gasket provides a weather tight seal.

LENS

The glass sag lens is clear, heat treated, and tempered with a minimum thickness of .125". A clear, heat, and impact resistant tempered flat lens is also available with a reduced jacketed lamp.

OPTICS

SEGMENTED Type-II Horizontal
SEGMENTED Type-III
SEGMENTED Type-IV
SEGMENTED Type-V

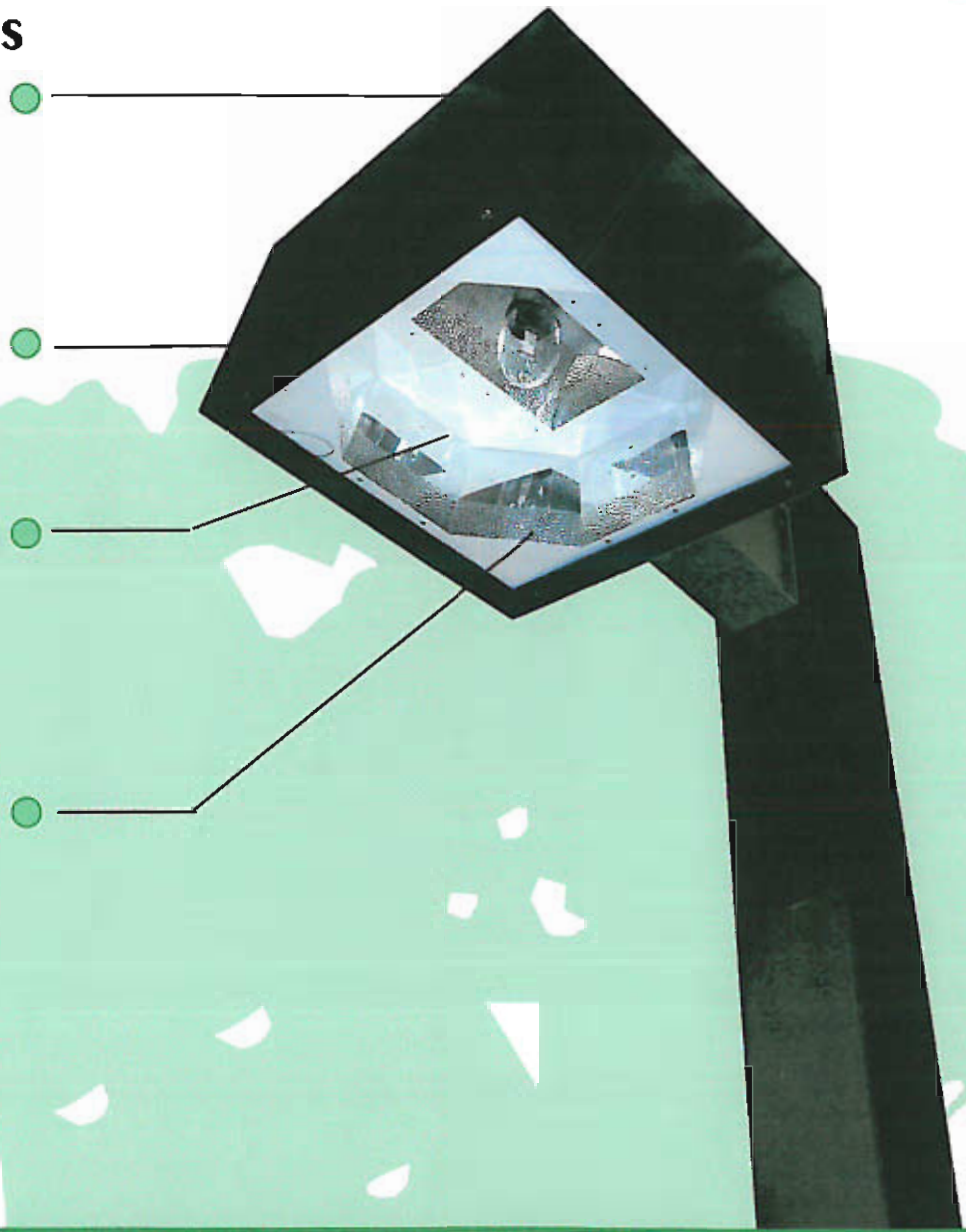

TITAN SERIES



POLARIS SERIES



POLARIS SERIES
YOKEMOUNTED