



THIS DOCUMENT ISSUED
JUNE 3, 2014
IS FOR REGULATORY APPROVAL
ONLY UNDER THE AUTHORITY OF
DAVID DUMAN, AIA
TEXAS REGISTRATION #14305.
IT IS NOT TO BE USED FOR
PERMITTING, CONSTRUCTION OR
FABRICATION PURPOSES

PROJECT NO. 11031
DATE: 05/27/2014
FILE NAME:


PATRIOT PAWS
254 RANCH TRAIL
ROCKWALL, TEXAS

REVISIONS:


CASE NUMBER:
SP2014-009

SHEET TITLE:
SITE PLAN


AS-101

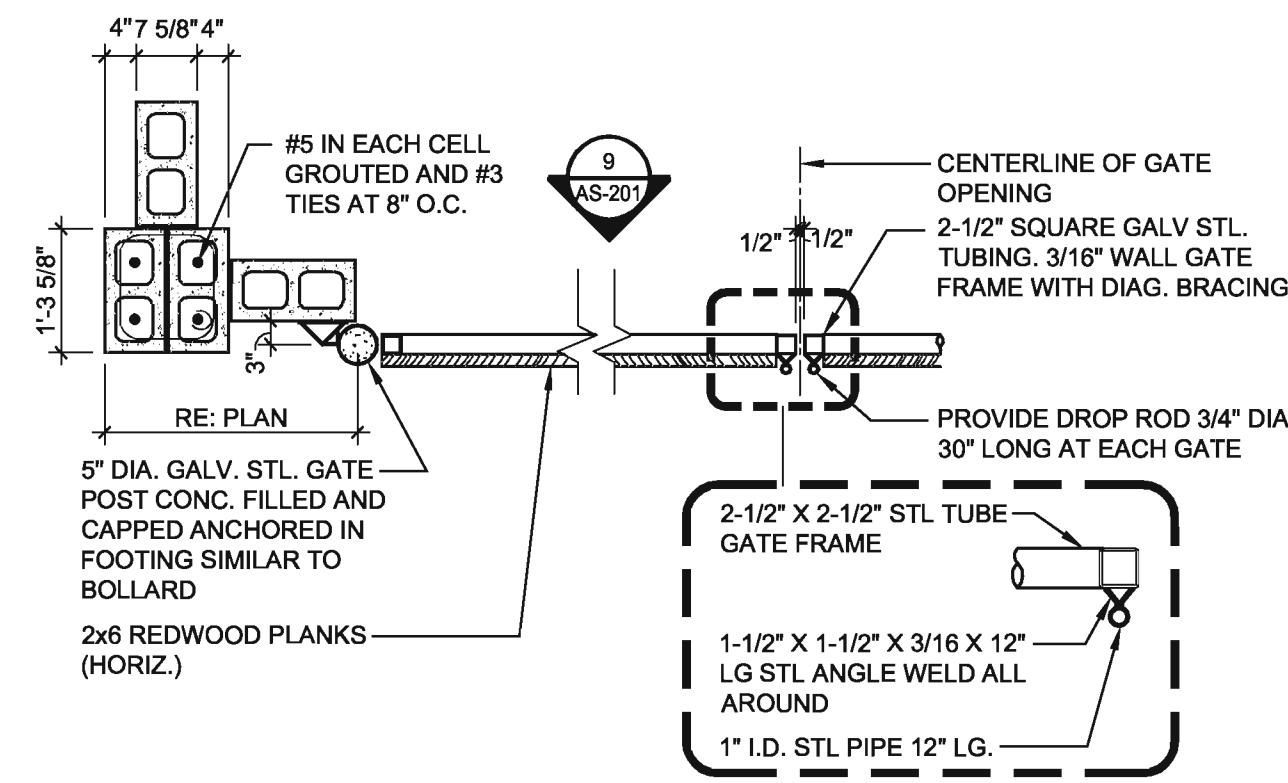


DUMPSTER ENCLOSURE GATE 4
SCALE: 1/2" = 1'-0"

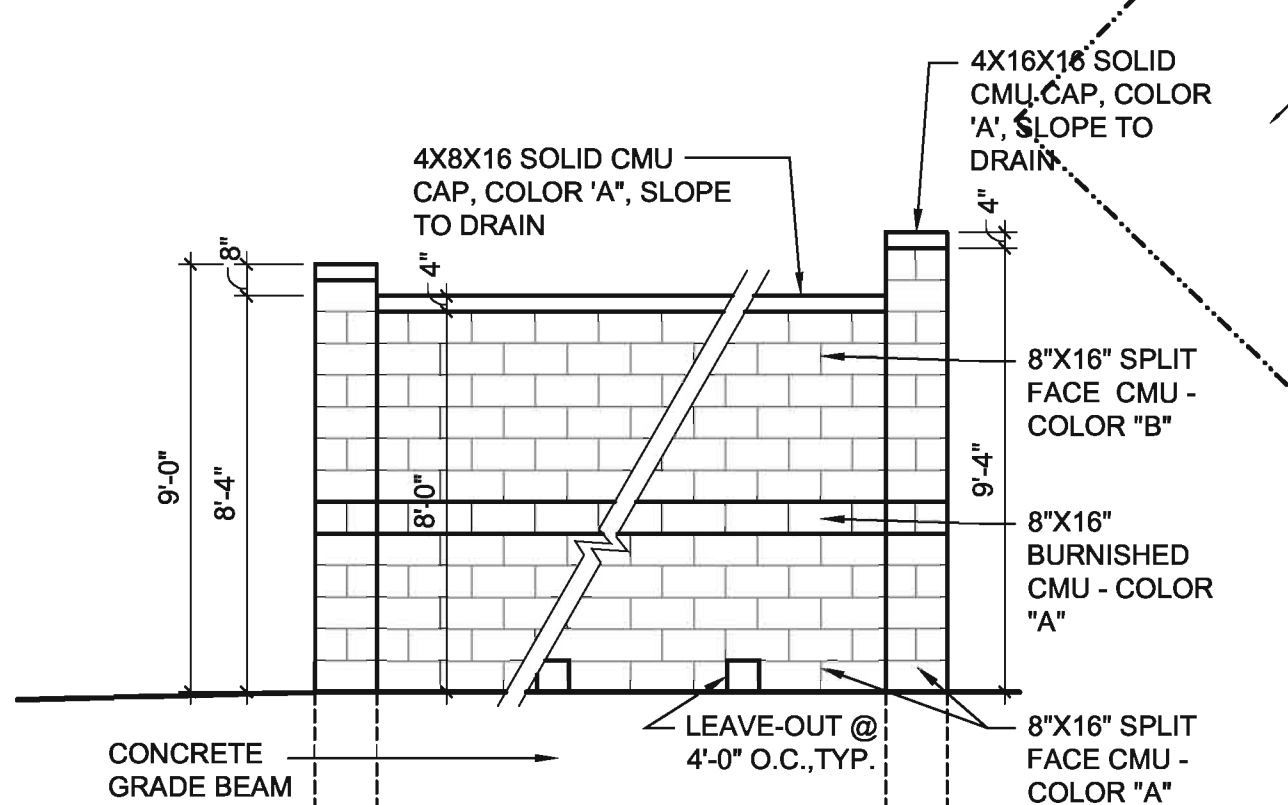

DUMPSTER ENCLOSURE ELEV. 3
SCALE: 1/4" = 1'-0"

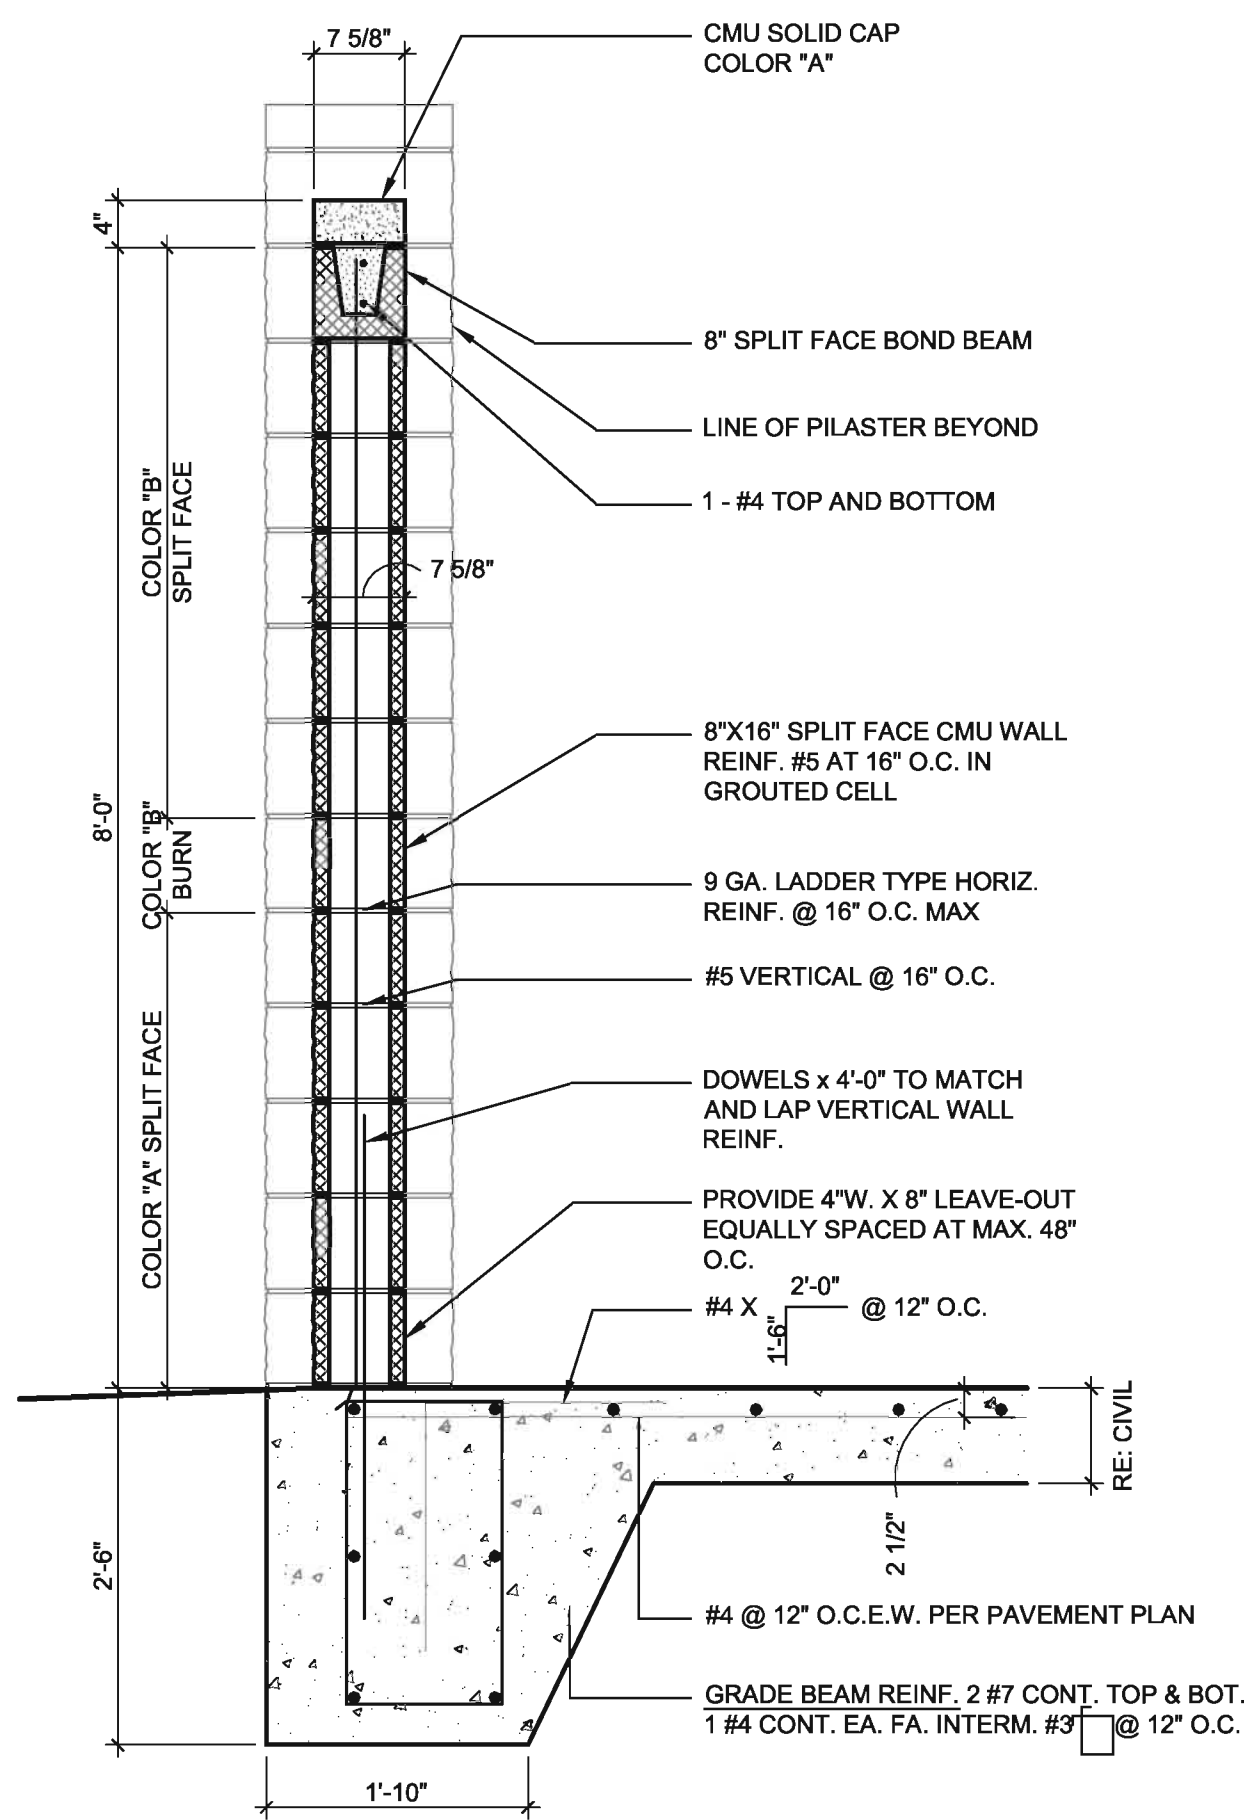

DUMPSTER ENCLOSURE SECT. 2
SCALE: 3/4" = 1'-0"

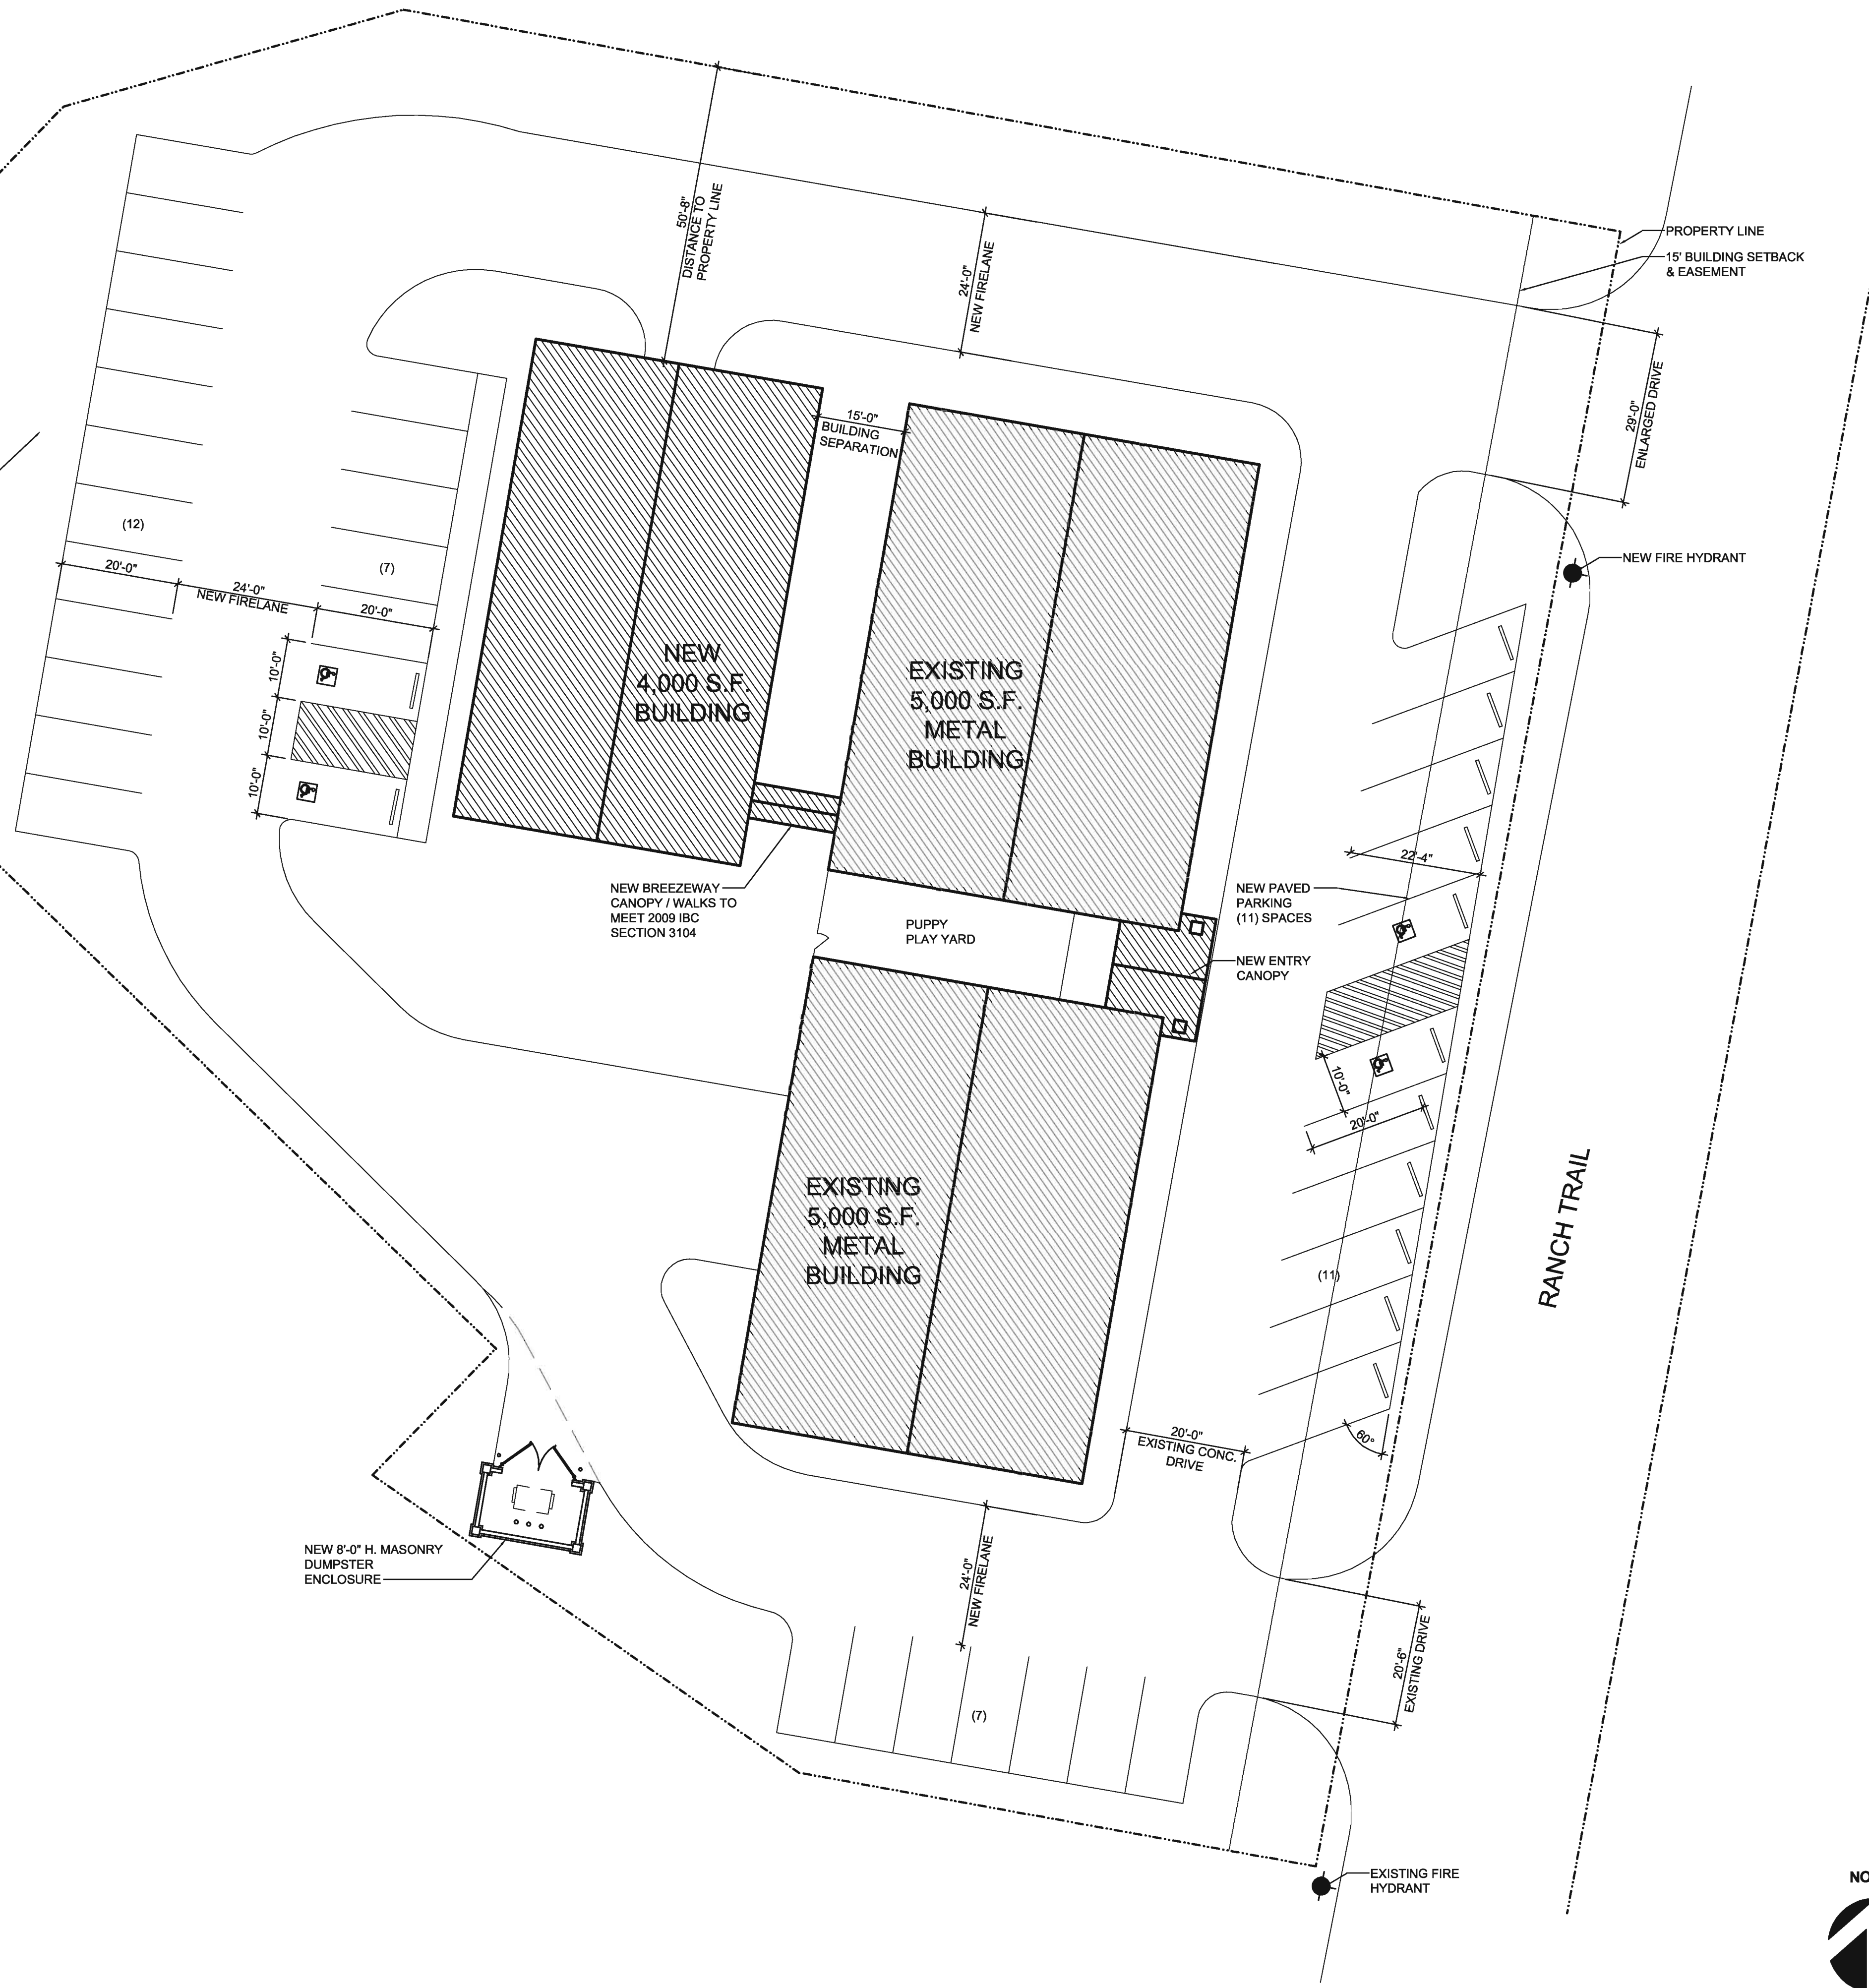

SITE PLAN
SCALE: 1/16" = 1'-0"





D. G. Duman Digitally signed by David Duman
Date: 2014.05.29 11:13:37 -0500

THIS DOCUMENT ISSUED
JUNE 3, 2014
IS FOR REGULATORY APPROVAL
ONLY UNDER THE AUTHORITY OF
DAVID DUMAN, AIA
TEXAS REGISTRATION #14305.
IT IS NOT TO BE USED FOR
PERMITTING, CONSTRUCTION OR
FABRICATION PURPOSES

PROJECT NO. 11031
DATE 05/27/2014
FILE NAME:

PATRIOT PAWS
254 RANCH TRAIL
ROCKWALL, TEXAS

REVISIONS:

CASE NUMBER:
SP2014-009
SHEET TITLE:


LANDSCAPE PLAN
L-100


1. INSTALL 4" LAYER OF HARDWOOD MULCH TO ALL PLANTING BEDS.
2. BED PREPARATION TO BE COMPOSTED COTTON BURR MIX. 12" DEPTH FOR SHRUBS.
3. INSTALL 4" STEEL EDGING BETWEEN ALL SHRUB BEDS AND GRASS AREAS.

LANDSCAPE NOTES

PLANTING LEGEND

	LIVE OAK		ASIAN JASMINE 18" SPACING
	SHUMARD OAK		ARTIFICIAL FIELD TURF (PUPPY PLAY YARD ONLY)
	TREE YAUPON		
	GRAPEMYRTLE		
	DWARF BURFORD HOLLY		
	DWARF YAUPON HOLLY		

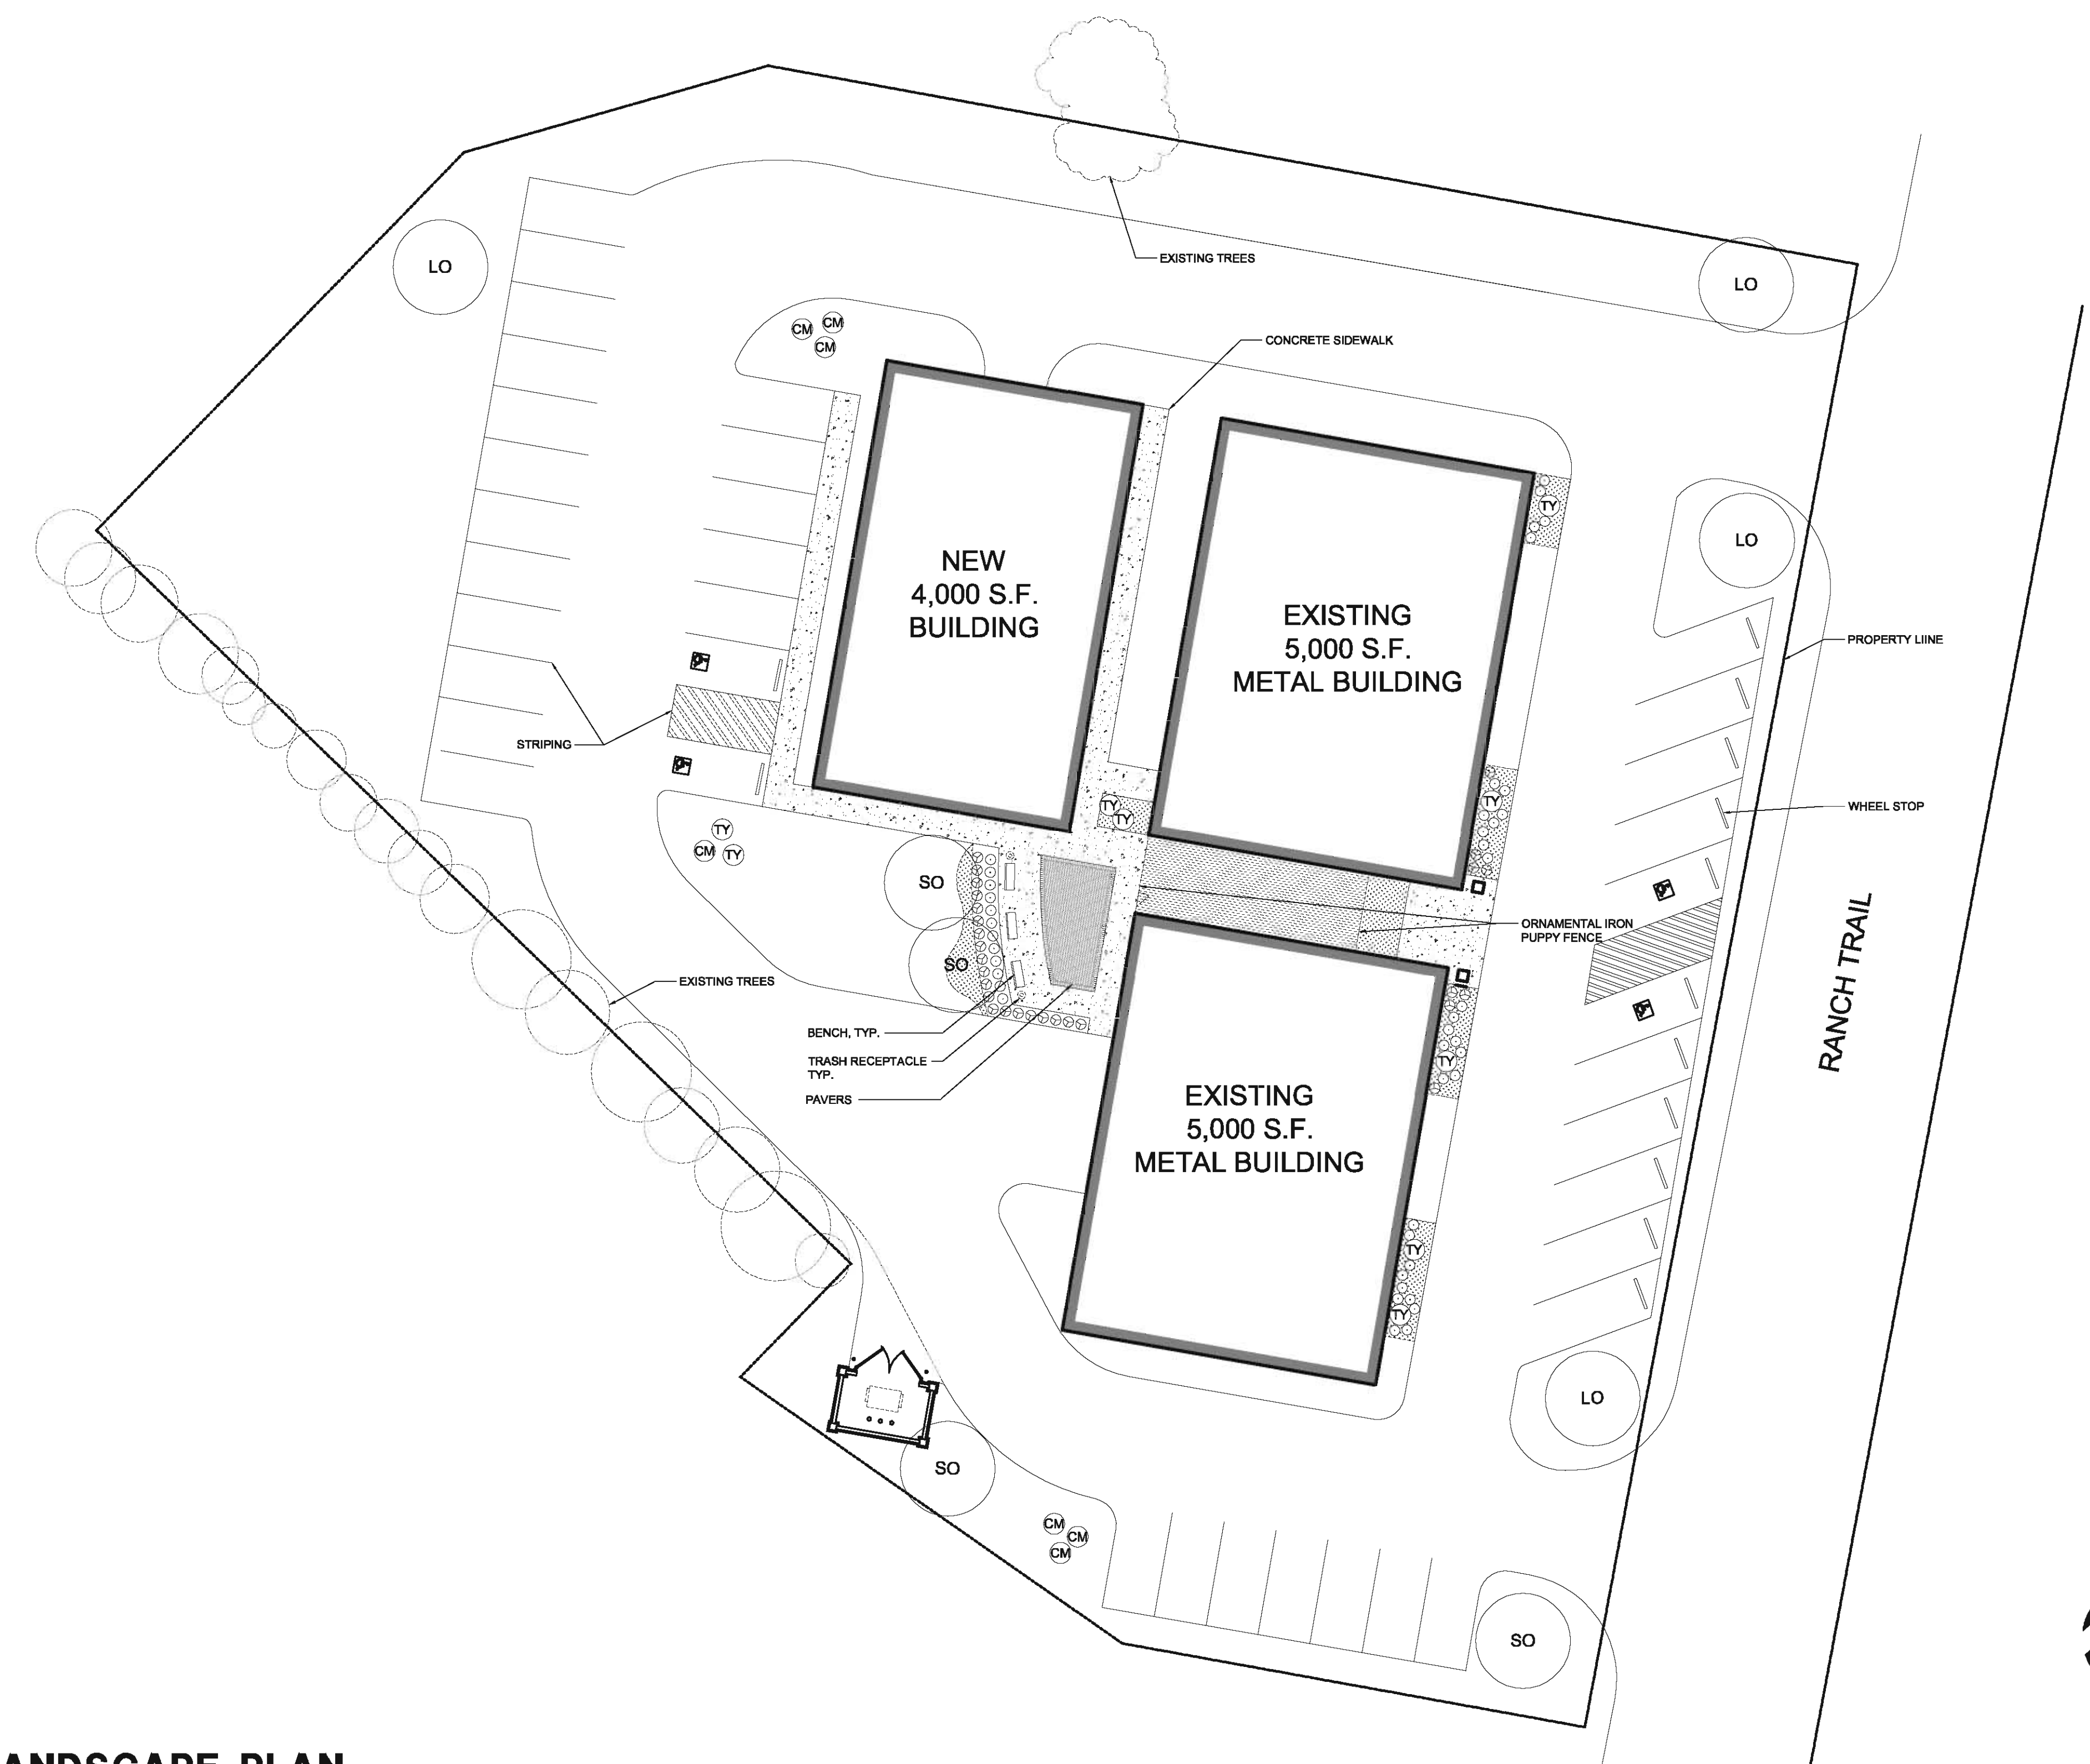

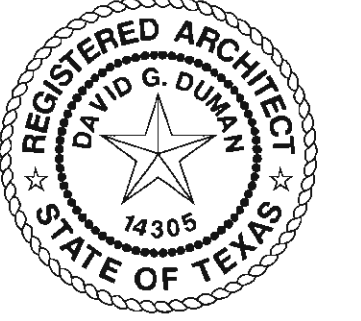

D. G. Duman Digitally signed by David G. Duman
Date: 2014.06.03 11:15:02 -0500

THIS DOCUMENT ISSUED
MAY 27, 2014
IS FOR REGULATORY APPROVAL
ONLY UNDER THE AUTHORITY OF
DAVID DUMAN, AIA
TEXAS REGISTRATION #14305.
IT IS NOT TO BE USED FOR
PERMITTING, CONSTRUCTION OR
FABRICATION PURPOSES



EXTERIOR ELEVATION - EAST - EXISTING BUILDING

1



EXTERIOR ELEVATION - WEST - EXISTING BUILDING

2



**EXTERIOR ELEVATION - WEST
NEW BUILDING**

3



**EXTERIOR ELEVATION - SOUTH
NEW BUILDING**

4



**EXTERIOR ELEVATION - EAST
NEW BUILDING**

5



**EXTERIOR ELEVATION - NORTH
NEW BUILDING**

6

PROJECT NO. 11031
DATE: 05/27/2014
FILE NAME:

PATRIOT PAWS
254 RANCH TRAIL
ROCKWALL, TEXAS

REVISIONS:

CASE NUMBER:
SP2014-009

SHEET TITLE:

EXTERIOR ELEVATIONS


A-200

LUMINAIRE SCHEDULE				
Label	Catalog Number	Description	Lamp	Watts
SW	WST 150M FT (PULSE START)	ARCHITECTURAL SCONCE WITH FORWARD THROW DISTRIBUTION WITH CLEAR, FLAT GLASS LENS. CLEAR LAMP. MEETS THE NIGHTTIME FRIENDLY CRITERIA	ONE 150-WATT CLEAR ED17 PULSE START METAL HALIDE HORIZONTAL POS.	189
D	KAD 400M R3 HS (PULSE START)	Area Luminaire, 400W MH, R3 Reflector, Full Cutoff, HouseSide Shield MEETS THE NIGHTTIME FRIENDLY CRITERIA	ONE 400-WATT CLEAR ED17 PULSE START METAL HALIDE HORIZONTAL POSITION.	456

STATISTICS						
Description	Symbol	Avg	Max	Min	Max/Min	Avg/Min
Property Line	+	0.0 fc	0.2 fc	0.0 fc	N / A	N / A
Site	+	3.1 fc	18.2 fc	0.0 fc	N / A	N / A

NOTES

1. WALL MOUNTED FIXTURES MOUNTED AT 10'
2. POLE MOUNTED FIXTURES MOUNTED ON 20' POLE WITH 2.5' BASE

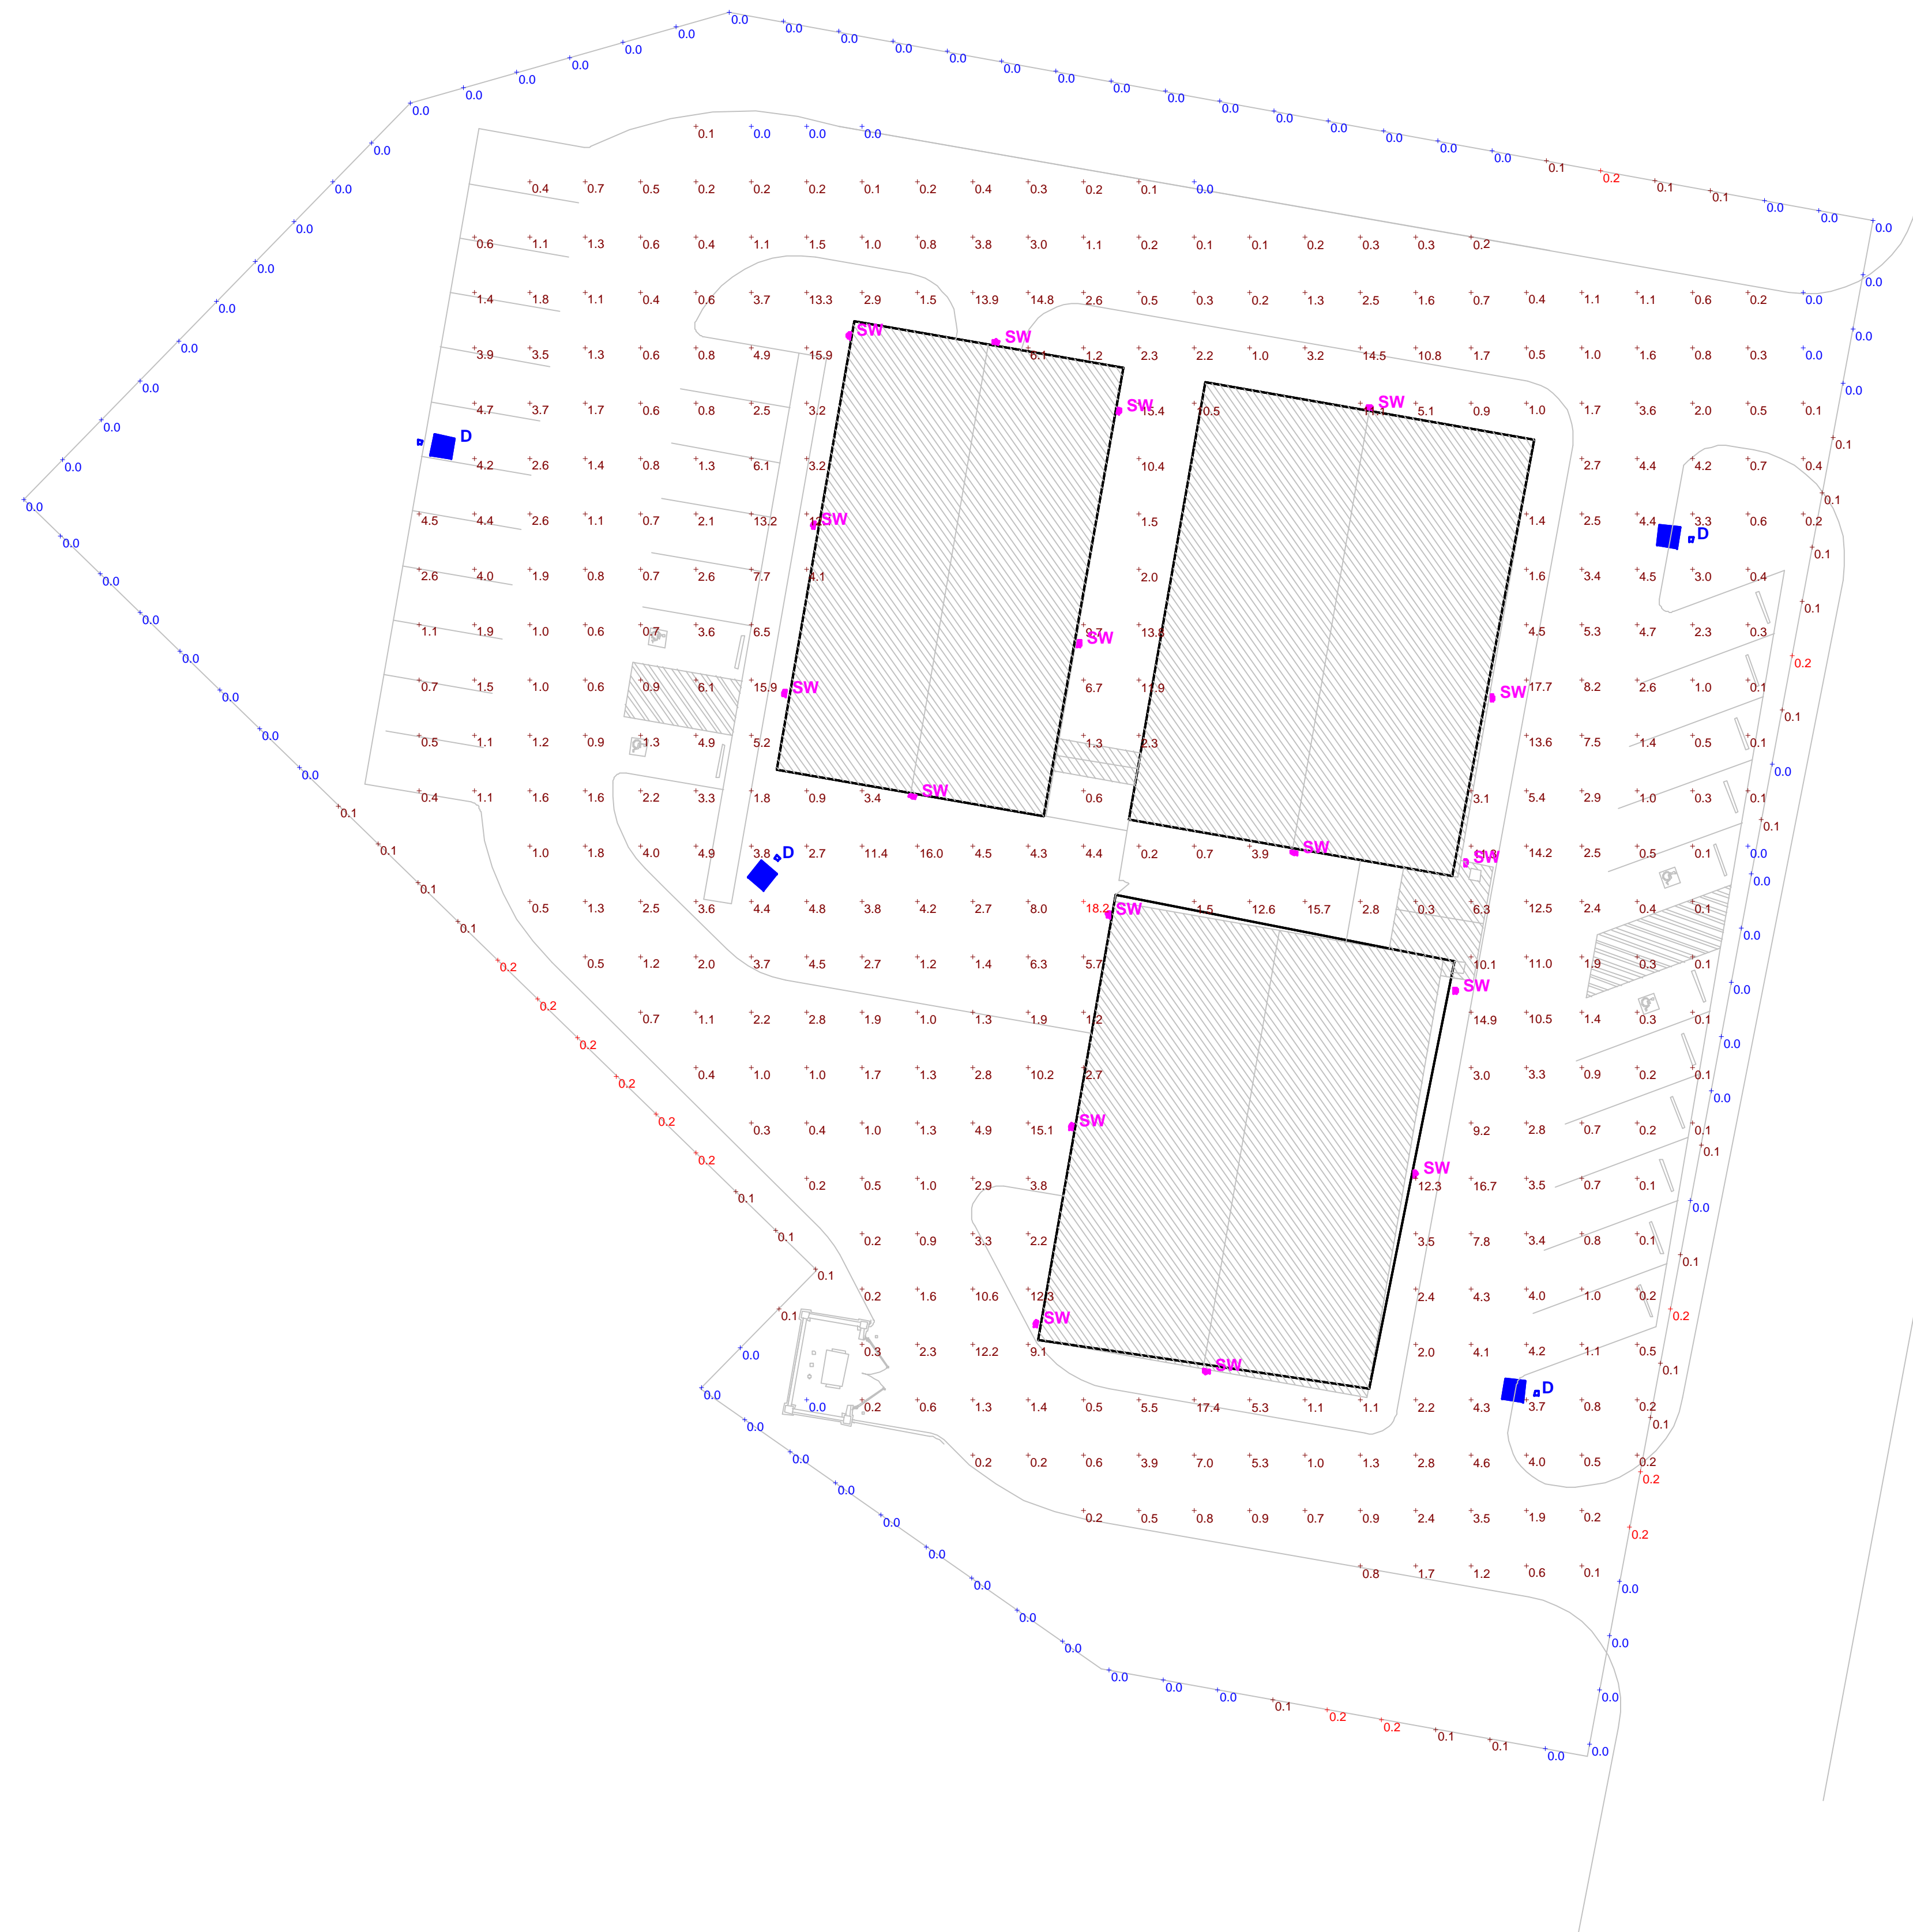

Plan View
Scale 1" = 20'



PATRIOT PAWS

Designer

LS

Date

May 15 2014

Scale

Drawing No.

Calculated values include direct and interreflected components.